

GENERAL NOTES

- ALL SANITARY WORKS INCLUDED HEREIN SHALL BE EXECUTED ACCORDING TO THE PROVISIONS OF THE NATIONAL PLUMBING CODE OF THE PHILIPPINES AND THE NATIONAL BUILDING CODE OF THE PHILIPPINES AND ITS IMPLEMENTING RULES AND REGULATIONS.
- COORDINATE THE DRAWING WITH OTHER RELATED DRAWINGS AND SPECIFICATIONS. THE ARCHITECT AND/OR THE ENGINEER SHALL BE NOTIFIED IMMEDIATELY OF ANY DISCREPANCY FOUND THEREIN. HIS/HER DECISION SHALL BE FINAL.
- ALL PIPES SHALL BE INSTALLED AS INDICATED. ANY RELOCATION REQUIRED FOR PROPER EXECUTION OF OTHER TRADES SHALL BE WITH PRIOR APPROVAL FROM THE ARCHITECT AND/OR ENGINEER.
- PROPOSED SANITARY UTILITIES SHALL CONFORM TO THE ACTUAL LOCATION, DEPTH AND INVERT ELEVATION OF EXISTING PIPES AND STRUCTURES AS VERIFIED BY THE CONTRACTOR.
- THE CONTRACTOR SHALL BE RESPONSIBLE FOR ALL THE REQUIRED FLOOR AND WALL OPENINGS.
- ALL SLOPES FOR HORIZONTAL STORM WATER DRAINAGE SHALL MAINTAIN 1% MINIMUM UNLESS OTHERWISE NOTED.
- ALL SLOPES FOR SANITARY LINES AND VENT PIPES SHALL MAINTAIN 2% SLOPE.
- SIZE OF WATER SUPPLY PIPES TO FIXTURE SHALL BE IN ACCORDANCE WITH THE MANUFACTURER'S INSTRUCTIONS.
- ALL FIXTURES SHALL BE PROPERLY VENTED UNLESS OTHERWISE NOTED.
- THE WORK THROUGHOUT SHALL BE EXECUTED IN THE BEST AND MOST THOROUGH MANNER KNOWN TO THE TRADE AND TO THE SATISFACTION OF THE ARCHITECT AND/OR THE ENGINEER.
- THE CONTRACTOR SHALL VERIFY ALL EXISTING UTILITIES AT SITE AND COORDINATE WORKS WITH SEWER EFFLUENT DISPOSAL AND WATERLINE SERVICE CONNECTING POINT.
- ALL PIPE SIZES SHOWN IN THE PLANS ARE IN "DN" (DIAMETER NOMINAL)

LEGEND:

FOR SANITARY WASTE AND VENT:

#SP/#WP	SOIL/WASTE PIPE
#DP	DRAIN PIPE
#VP	VENT PIPE
(AC)	PIPE ABOVE CEILING
(US)/(UG)	PIPE UNDER SLAB/GROUND
#CDP	CONDENSATE DRAIN PIPE
(OFF.)	PIPE OFFSET
COO	CEILING CLEAN OUT
FOO	FLOOR CLEAN OUT
#SS/#VS	SOIL/WASTE STACK
#VS	VENT STACK
#VSTR	VENT STACK THRU ROOF
#VSTE	VENT STACK THRU EAVES
#VSTHRU WALL	VENT STACK THRU WALL
#DS	DOWNSPOUT
RD	ROOF DRAIN
TD	TRENCH DRAIN
FD/DD	FLOOR DRAIN/DECK DRAIN
BD/CD	BALCONY DRAIN/CANOPY DRAIN
CHD	CHAIN DRAIN
WM	WASHING MACH. DRAIN STUBOUT
AD	AREA DRAIN/CATCH BASIN

FOR WATERLINE:

#CWL	COLD WATER LINE
#HWL	HOT WATER LINE
(AC)	PIPE ABOVE CEILING
(US)/(UG)	PIPE UNDER SLAB/GROUND
(RW-CWL)	RECYCLED CWL (NON-POTABLE)
(OFF.)	PIPE OFFSET
#CWR	COLD WATER RISER
#CWF	COLD WATER DOWNFEED
WM	WATER METER
GV	GATE VALVE
CV	CHECK VALVE
UP	UNION PATENTE
HB	HOSE BIBB
BS	BIDET SPRAY

PLUMBING FIXTURES:

KS/ SNK	KITCHEN/ LAUNDRY SINK
LAV	LAVATORY
WC	WATER CLOSET
SHD	SHOWER
BT	BATHTUB


MATERIAL SPECIFICATIONS

ASTM-D-2729	uPVC PIPES & FITTINGS (SERIES 1000) (MOLDEX OR APPROVED EQUIVALENT)	DOWNSPOUT & STORM DRAIN (INSIDE/OUTSIDE BLDG)
ASTM-D-2729	uPVC PIPES & FITTINGS (SERIES 1000) (MOLDEX OR APPROVED EQUIVALENT)	SANITARY, WASTE & VENT
	CONCRETE DRAIN PIPES	STORM DRAIN >300MMØ (OUTSIDE BLDG)
	POLYPROPYLENE (PPR) PIPES & FITTINGS (PN 20)	WATERLINES

PIPE SUPPORT SPACING (FOR PLASTIC PIPES)


PIPE DIAMETER	HORIZONTAL PIPES (mm)	VERTICAL PIPES (mm)
15mmØ	600	1200
20mmØ	700	1400
25mmØ	750	1500
32mmØ	800	1600
40mmØ	900	1800
50mmØ	1050	2100
82mmØ	1350	2700
110mmØ	1500	3000
160mmØ	1800	3600

PIPE SIZE	FLAT BAR	ROUND BAR	EXPANSION SHIELD WITH BOLT
25 TO 50mmØ	25mm X 3mm	12mmØ	10mmØ
65 TO 100mmØ	40mm X 3mm	12mmØ	12mmØ
125 TO 150mmØ	50mm X 5mm	16mmØ	16mmØ

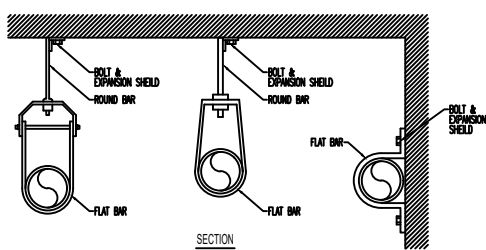


4
P 01
TYPICAL PIPE HANGER DETAIL

SCALE NTS

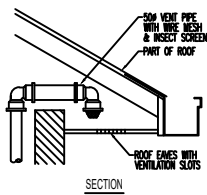



5
P 01
VENT STACK THRU EAVE (VSTE) DETAIL

SCALE NTS

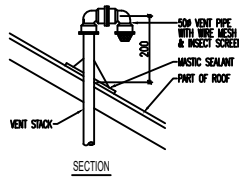

6
P 01
VENT STACK THRU ROOF (VSTR) DETAIL


SCALE NTS

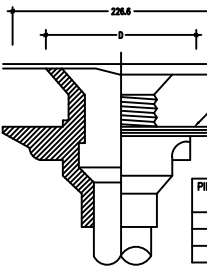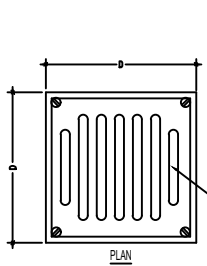

3
P 01
TYP. BASE OF SOIL/WASTE & VENT STACK DETAIL


SCALE NTS

PIPE SIZE (A)	C	D
50	38.1	101.6
75	38.1	127.0
100	40.1	152.4

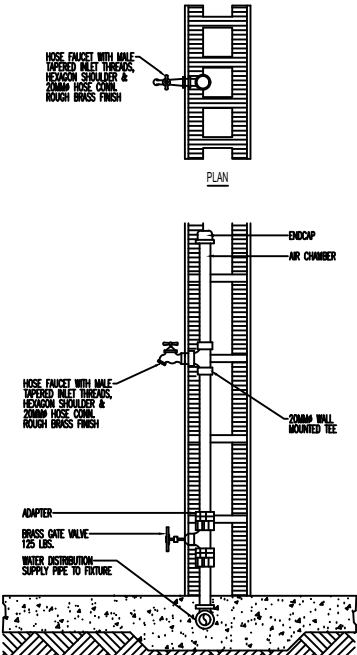


1
P 01
TYP. HOSE BIBB DETAIL

SCALE NTS

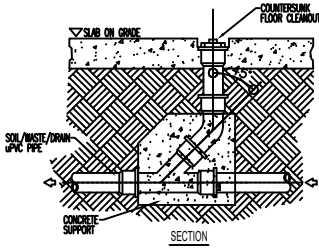


7
P 01
TYP. (FCO) FLOOR CLEANOUT DETAIL

SCALE NTS

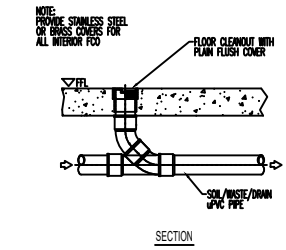



8
P 01
TYP. (FCO) FLOOR CLEANOUT DETAIL WITH COVERPLATE

SCALE NTS

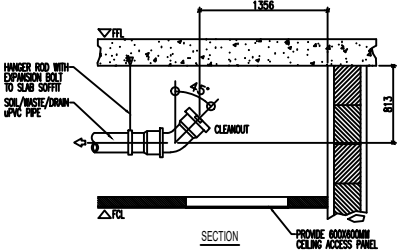


9
P 01
TYP. (CCO) CEILING CLEANOUT DETAIL

SCALE NTS

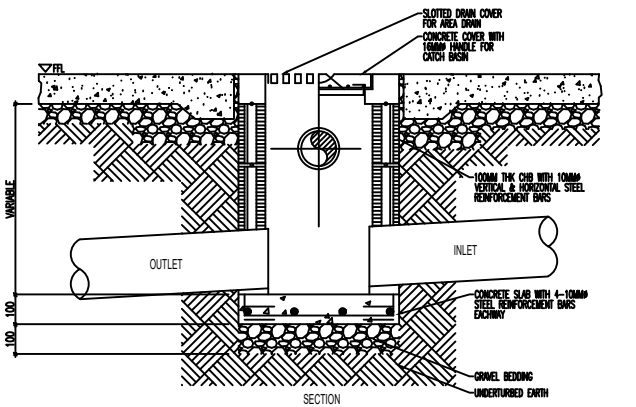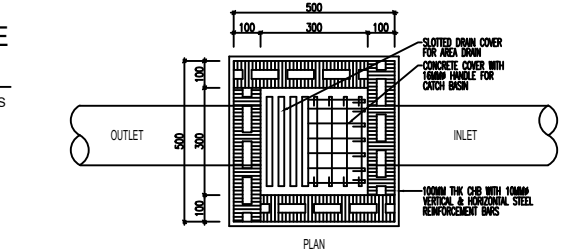

10
P 01
TYP. AREA DRAIN/CATCH BASIN DETAIL

SCALE NTS

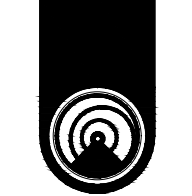

Radius
ARCHITECTURE

108 PEREA ST., MEZZANINE
FLOOR, GREENBELT MANSION,
LEGAZPI VILLAGE, MAKATI CITY
1229 PHILIPPINES
(02)256-4984 @radiusarchitecture

PROJECT TITLE:

SPEEDEDGE -
SHOOTING RANGE

PROJECT TYPE:

2-STOREY COMMERCIAL
BUILDING

ADDRESS:

LOT 30 BLOCK 1, WEST RD.,
ALABANG WEST, LAS PINAS
CITY

CLIENT:

MR. EDWARD RIVERA

R.A. 9286 (ARCHITECTURE LAW OF 2004) SECTION 33:
DRAWINGS AND SPECIFICATIONS AND OTHER CONTRACT
DOCUMENTS "DULY SIGNED, STAMPED OR SEALED," AS
INSTRUMENTS OF SERVICE, ARE THE INTELLECTUAL PROPERTY
AND DOCUMENTS OF THE ARCHITECT. WHETHER THE OBJECT
FOR WHICH THEY ARE MADE IS EXECUTED OR NOT, IT SHALL BE
UNLAWFUL FOR ANY PERSON TO DUPLICATE OR TO MAKE
COPIES OF SAID DOCUMENTS FOR USE IN THE REPRODUCTION
OF AND FOR OTHER PROJECTS OR BUILDINGS, WHETHER
EXECUTED PARTIALLY OR IN WHOLE, WITHOUT THE WRITTEN
CONSENT OF ARCHITECT OR AUTHOR OF SAID DOCUMENTS.

MASTER PLUMBER
NEIL KARLO C. DEL MUNDO

PRC NO.: 6294
PTR NO.: 2441289

DRAWN BY:

CHECKED BY:

DATE:

06-02-2025

REVISION NO.:

01

SHEET CONTENTS:

AS SHOWN

SHEET NUMBER:

P-01

01 OF 13

IMPORTANT NOTES:

ALL PLUMBING FIXTURES WITHOUT THEIR OWN INTEGRATED OR BUILT-IN TRAPS SHALL BE PROVIDED WITH ADEQUATELY SIZED P-TRAPS TO PREVENT SEWER GASES BACKING UP.

PROVIDE PROPER VENT PIPES AS SHOWN IN THE PLUMBING PLANS TO PROTECT WATER INSIDE P-TRAPS FROM SIPHONAGE, ENSURING PROPER OPERATION TO PREVENT SEWER GASES FROM BACKING-UP.

PROVIDE CLEANOUTS AS SHOWN IN THE PLUMBING PLANS AND DETAILS TO ALLOW PROPER MAINTENANCE OF THE PIPE SYSTEM.

MAINTAIN PROPER PIPE SLOPE FOR ALL PIPES & LINES, SEE P-01 PLUMBING NOTES


PROVIDE ACCESS PANELS FOR MAINTENANCE OF ALL CLEANOUTS AS APPROVED BY THE ARCHITECT

PROVIDE ADEQUATE PIPE SUPPORTS AND HANGERS, SEE P-01 TYP. PIPE HANGER DETAIL

THE CONTRACTOR SHALL TEST ALL PIPES TO MAKE SURE THERE ARE NO LEAKS AND FOUL ODORS FROM THE PIPE SYSTEM.

ALL FIXTURE AND EQUIPMENT SPECIFICATIONS, DIMENSIONS, CLEARANCES, INSTALLATION REQUIREMENTS, NECESSARY SUBROUTS AND/OR PROVISIONS, ITEM STOCK AVAILABILITY, AND THE LINES SHALL BE VERIFIED BY THE CONTRACTOR WITH THE RESPECTIVE MANUFACTURER/SUPPLIER PRIOR TO START OF CONSTRUCTION.

PROVIDE PROPER P-TRAP FOR ALL FCU'S. FOLLOW AIRCON MANUFACTURER/SUPPLIER INSTALLATION INSTRUCTIONS.

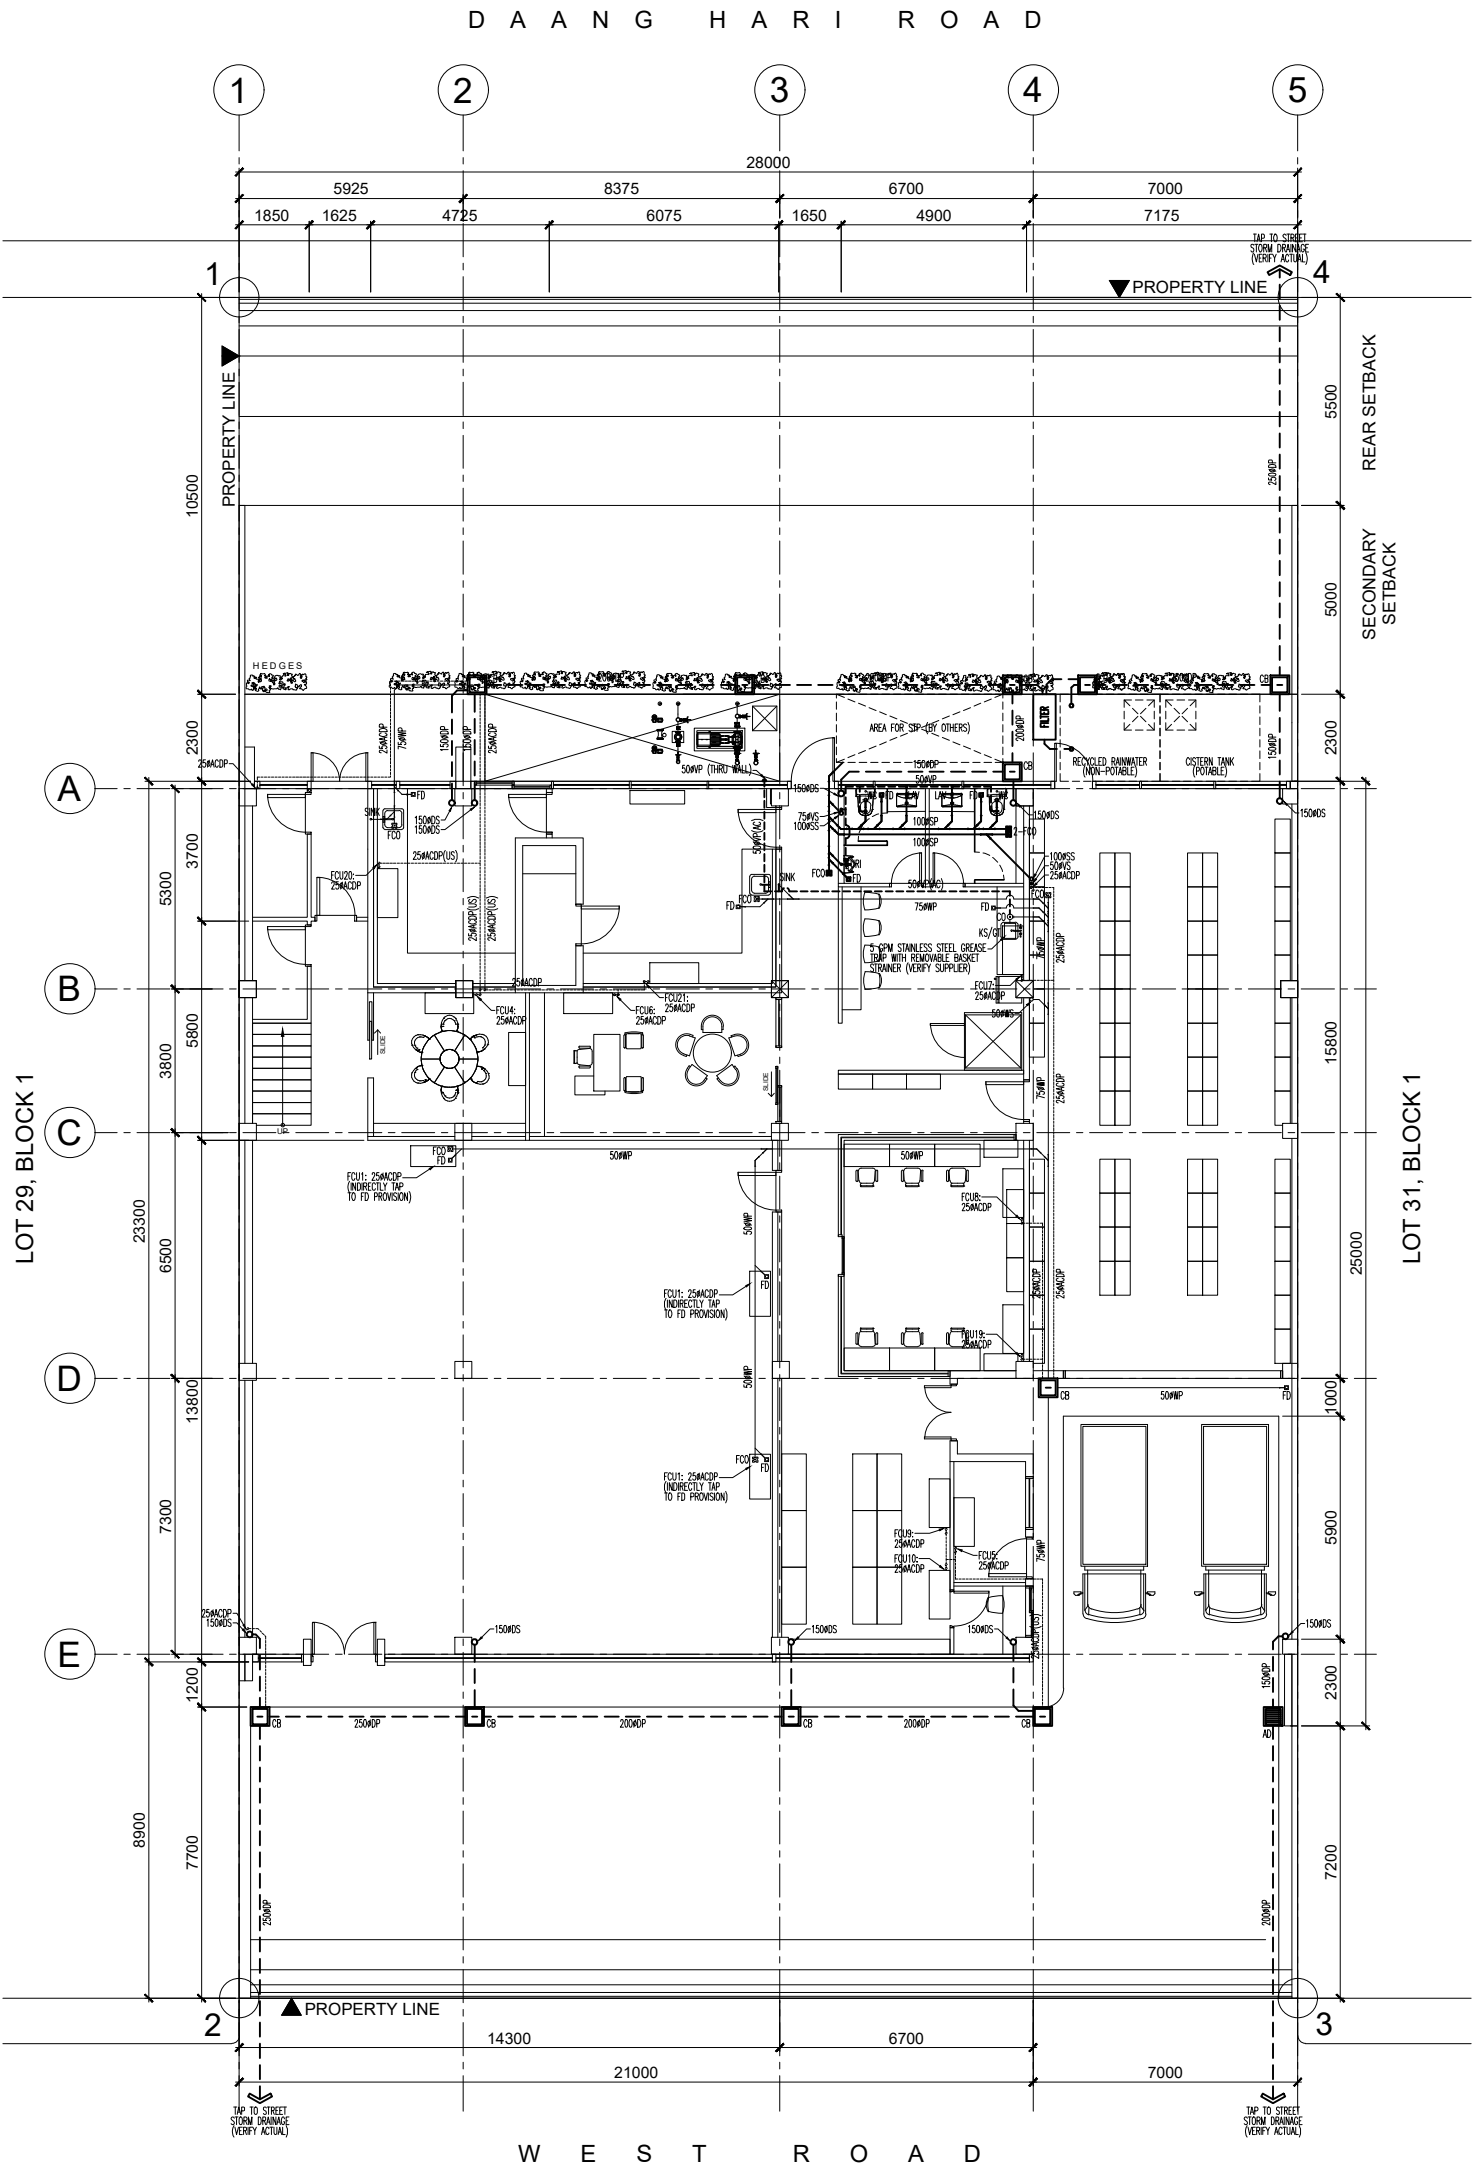

SOIL, WASTE, VENT & STORM DRAIN LAYOUT
1
P 02 GROUND FLOOR PLAN
SCALE 1:200 M



Radix
ARCHITECTURE

108 PEREA ST., MEZZANINE,
FLOOR GREENBELT TOWNION,
LEONARDO TOWNION CITY
(02)256-4984 @radixarchitecture

PROJECT TITLE:

**SPEEDEDGE -
SHOOTING RANGE**

PROJECT TYPE:

**2-STORY COMMERCIAL
BUILDING**

ADDRESS:

LOT 30 BLOCK 1 WEST RD.,
ALABANG WEST LAS PINAS
CITY

CLIENT:

MR. EDWARD RIVERA

R.A. 9286 (ARCHITECTURE LAW OF 2004) SECTION 33.

DRAWINGS AND SPECIFICATIONS AND OTHER CONTRACT DOCUMENTS, ONLY ISSUED, SIGNED OR SEALED AS REQUIRED BY THE ARCHITECT, SHALL BE THE PROPERTY OF THE ARCHITECT. THE ARCHITECT'S SIGNATURE SHALL BE REQUIRED FOR ANY PERSON TO DUPLICATE OR TO MAKE COPIES OF SAID DOCUMENTS FOR USE IN THE REPRODUCTION OF ANY DRAWING OR SPECIFICATION OR FOR ANY OTHER PURPOSE WITHOUT THE WRITTEN CONSENT OF THE ARCHITECT OR AUTHORITY OF SAID DOCUMENTS.

MASTER PLUMBER

NEIL KARLO C. DEL MUNDO

PRG NO.: 6294

PIR NO.: 2441289

DRAWN BY:

CHECKED BY:

DATE: 06-02-2025

REVISION NO.: 01

SHEET CONTENTS:
AS SHOWN

SHEET NUMBER:

P-02

02 OF 13



Radius
ARCHITECTURE

106 PEREA ST., MEZZANINE,
FLOOR GREENBELT TOWNSON,
LEONARDO 1220 PHILIPPINES
(02)256-4984 @radiusarchitecture

PROJECT TITLE:

**SPEEDEDGE -
SHOOTING RANGE**

PROJECT TYPE:

**2-STOREY COMMERCIAL
BUILDING**

ADDRESS:

LOT 30 BLOCK 1 WEST RD.,
ALABANG WEST LAS PINAS
CITY

CLIENT:

MR. EDWARD RIVERA

R.A. 9286 (ARCHITECTURE LAW) OF 2004 SECTION 33.
DRAWINGS AND SPECIFICATIONS AND OTHER CONTRACT
DOCUMENTS, ONLY ISSUED, SIGNED OR SEALED AS
REQUIRED BY THE PROFESSIONAL REGULATION ACT
AND DOCUMENTS OF THE ARCHITECT, WHETHER THE OBJECT
UNLAWFUL FOR ANY PERSON TO DUPLICATE OR TO MAKE
COPIES OF AND DOCUMENTS FOR USE IN THE PRACTICE OF
ARCHITECTURE OR ENGINEERING OR ANY OTHER
EXECUTED PARTY OR IN WHOLE, WITHOUT THE WRITTEN
CONSENT OF ARCHITECT OR AUTHOR OF SAID DOCUMENTS.

MASTER PLUMBER
NEIL KARLO C. DEL MUNDO

PRG NO.: 6294
PTR NO.: 2417289

DRAWN BY:

CHECKED BY:


DATE: **06-02-2025** REVISION NO.: **01**

SHEET CONTENTS:
AS SHOWN

SHEET NUMBER:

P-03

03 OF 13

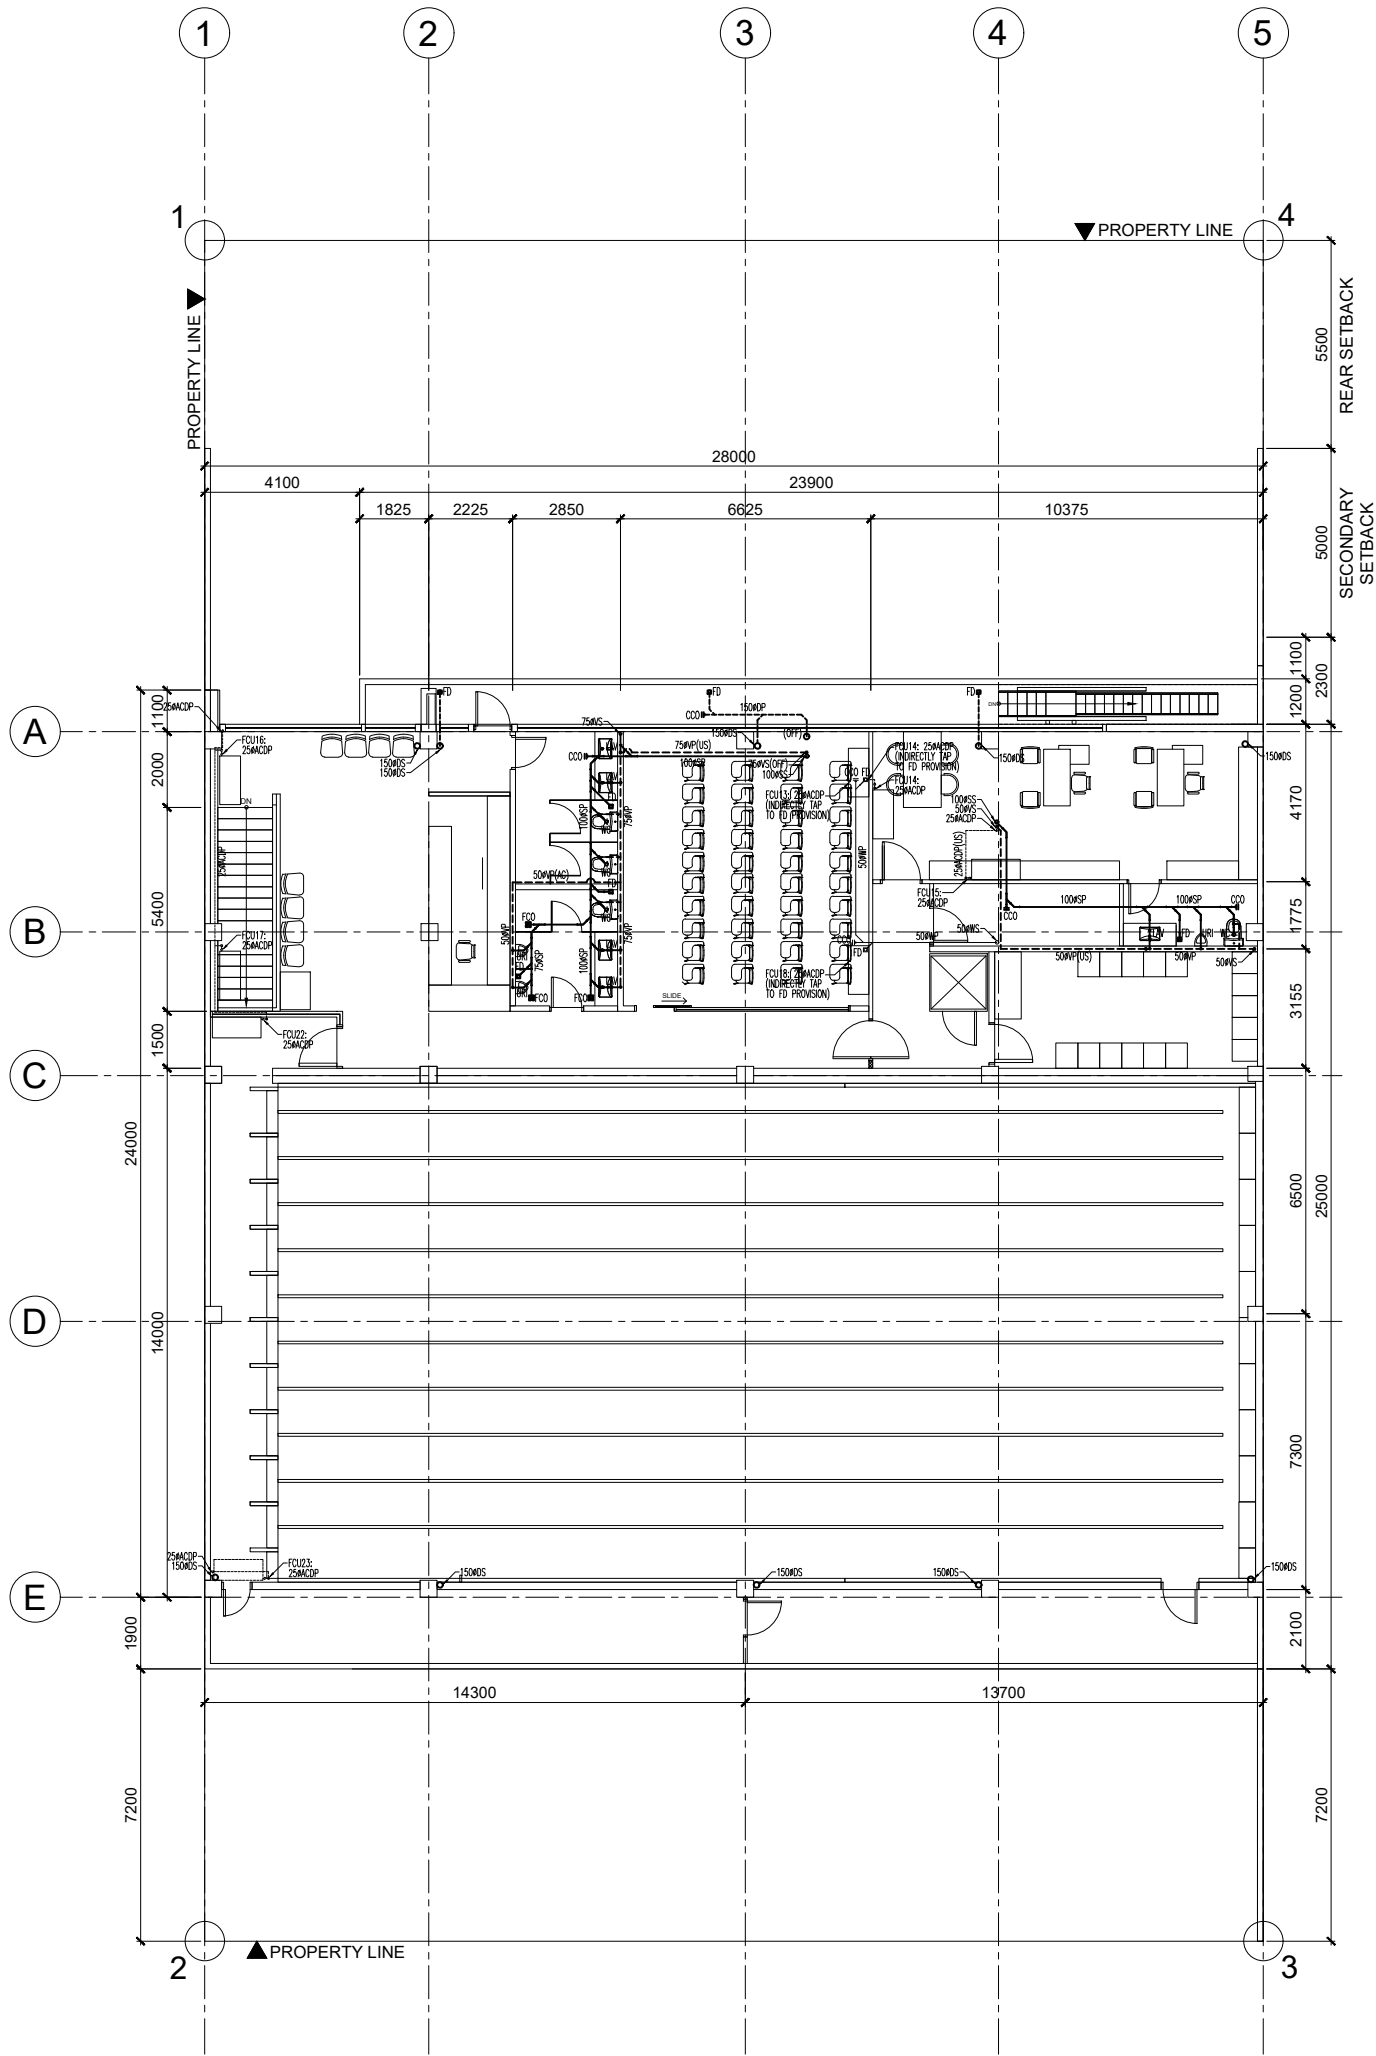

SOIL, WASTE, VENT & STORM DRAIN LAYOUT
1 SECOND FLOOR PLAN
SCALE 1:200 M
P 03



(02)256-4984 @radiusarchitecture

PROJECT TITLE:

SPEEDEDGE - SHOOTING RANGE

PROJECT TYPE:

2-STOREY COMMERCIAL BUILDING

ADDRESS:

LOT 30 BLOCK 1, WEST RD.,
ALABANG WEST, LAS PINAS
CITY

CLIENT:

MR. EDWARD RIVERA

R.A. 9286 (ARCHITECTURE LAW OF 2004) SECTION 3.3
DRAWINGS AND SPECIFICATIONS AND OTHER CONTRACT DOCUMENTS, DULY SIGNED, STAMPED OR SEALED AS INSTRUMENTS OF SERVICE ARE THE INTELLECTUAL PROPERTY AND DOCUMENTS OF THE ARCHITECT. WHETHER THE OBJECT FOR WHICH THEY ARE MADE IS EXECUTED OR NOT, IT SHALL BE UNLAWFUL FOR ANY PERSON TO DUPLICATE OR TO MAKE COPIES OF SAID DOCUMENTS FOR USE IN THE EXECUTION OF AND FOR OTHER PROJECTS OR BUILDINGS, WHETHER EXECUTED PARTLY OR IN WHOLE, WITHOUT THE WRITTEN CONSENT OF ARCHITECT OR AWARD OF SAID DOCUMENTS.

MASTER PLUMBER

NEIL KARLO C. DEL MUNDO

PRC NO.: 6294

PTR NO.: 2441285

DRAWN BY:

1

CHECKED BY:

DATE: _____ REVISION NO.: _____

06-02-2025

01

**SHEET CONTENTS:
AS SHOWN**

SHEET NUMBER:

P-04


04 OF 13




ROOF PLAN

SCALE

1:200 M

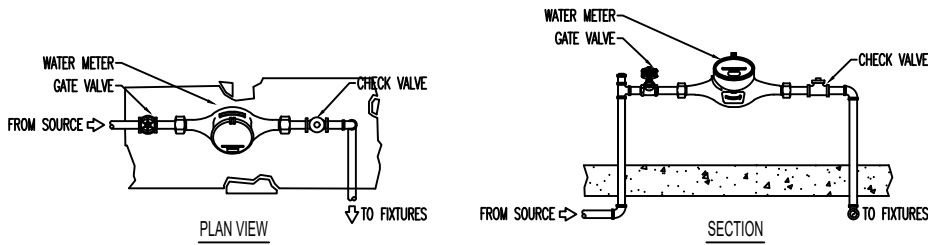


2 TYP. WATER METER DETAIL
P 05 SCALE NTS

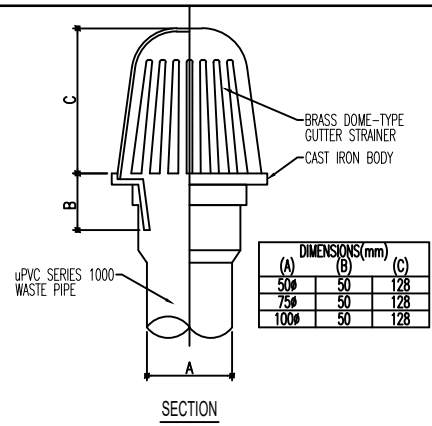


5 TYP. GUTTER DRAIN (GD) DETAIL
P 05 SCALE NTS


NOTE: PROVIDE AIR CHAMBERS FOR ALL APPLICABLE WATER FIXTURES TO REDUCE EFFECT OF WATER HAMMER

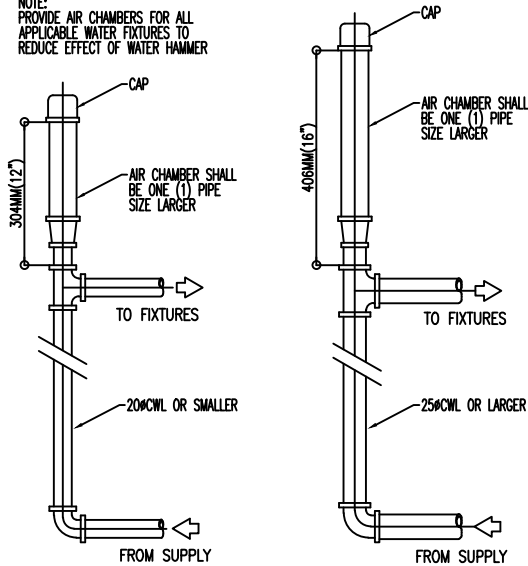


3 TYP. AIRCHAMBER DET. FOR QUICK-CLOSE FAUCETS/FIXTURES
P 05 SCALE NTS

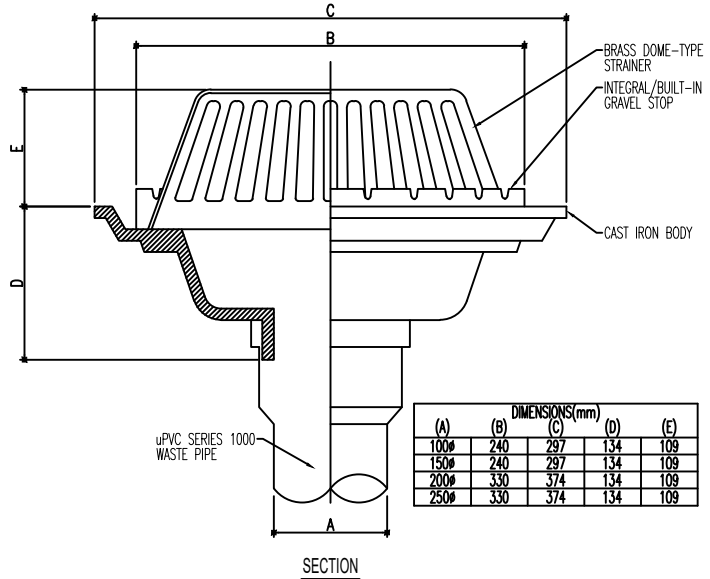


6 TYP. DECK DRAIN (DD) DETAIL
P 05 SCALE NTS

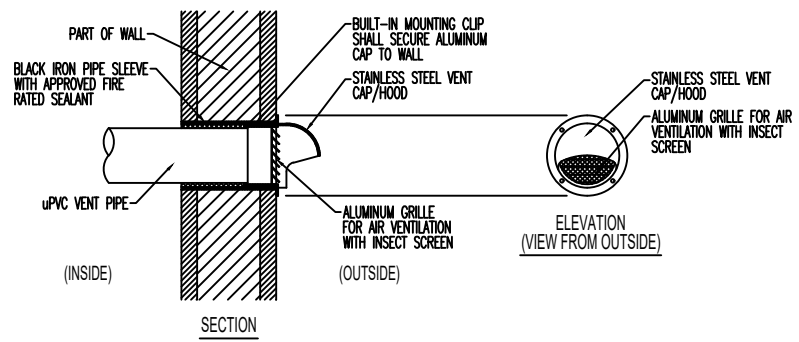

7 TYP. VENT PIPE THRU WALL DETAIL
P 05 SCALE NTS

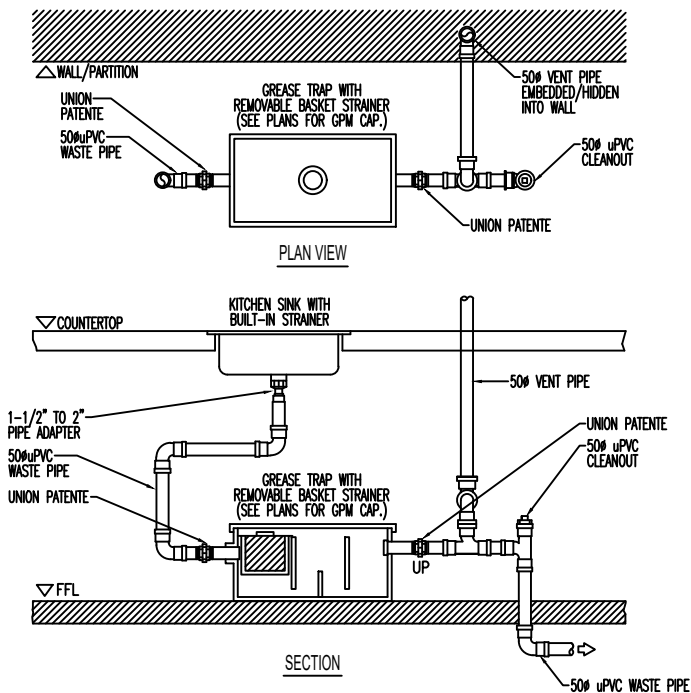

4 TYP. GREASE TRAP DETAIL
P 05 SCALE NTS

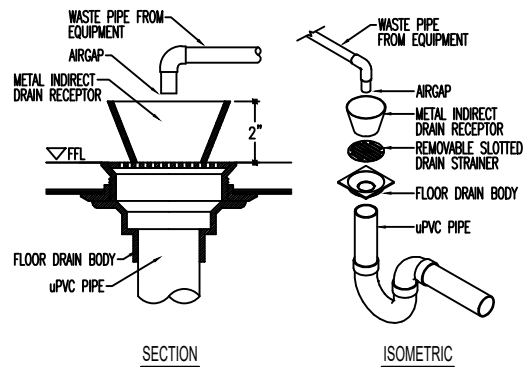

8 TYP. INDIRECT DRAIN RECEPTOR DETAIL
P 05 SCALE NTS



Redline
ARCHITECTURE

108 PEREA ST., MEZZANINE
FLOOR, GREENBELT TOWNSHIP,
LEONARD, ALABAMA 36034
(205) 256-4994 @redlinearchitecture

PROJECT TITLE:

**SPEEDEDGE -
SHOOTING RANGE**

PROJECT TYPE:

**2-STORY COMMERCIAL
BUILDING**

ADDRESS:

LOT 30 BLOCK 1 WEST RD.,
ALABAMA WEST LAS PINAS
CITY

CLIENT:

MR. EDWARD RIVERA

R.A. 2026 ARCHITECTURE (LAW) OF 2004 SECTION 33.
DRAWINGS, SPECIFICATIONS AND OTHER CONTRACT
DOCUMENTS, ONLY AS SHOWN, STAMPED OR SEALED AS
INDICATED, SHALL BE VALID FOR THE PROJECT AND
DOCUMENTS OF THE ARCHITECT. ANY OTHER USE OF
THESE DOCUMENTS OR ANY PART THEREOF, FOR ANY
PURPOSE, WITHOUT THE WRITTEN PERMISSION OF
THE ARCHITECT, IS PROHIBITED. THE ARCHITECT
DOES NOT WARRANT OR GUARANTEE THE ACCURACY
OR COMPLETION OF THE PROJECT. THE ARCHITECT
DOES NOT ASSUME RESPONSIBILITY FOR THE
EXECUTION OF THE PROJECT OR FOR THE QUALITY
OF THE WORKMANSHIP OR FOR THE SAFETY OF THE
CONSTRUCTION OR FOR THE PERFORMANCE OF THE
CONSTRUCTION.

MASTER PLUMBER
NEIL KARLO C. DEL MUNDO
PRG NO.: 6294
PTR NO.: 2441289

DRAWN BY:

CHECKED BY:

DATE: 06-02-2025
REVISION NO.: 01

SHEET CONTENTS:
AS SHOWN

SHEET NUMBER:

P-05

05 OF 13

IMPORTANT NOTES:


VERIFY WATER TANKS, PUMPS, PUMP CONTROLLER, FLOAT SWITCH, PRESSURE TANK, AND OTHER NECESSARY EQUIPMENT SPECIFICATIONS AND THEIR SPECIFIC INSTALLATION REQUIREMENTS WITH THE RESPECTIVE MANUFACTURER/SUPPLIER PRIOR TO START OF CONSTRUCTION.

THE CONTRACTOR SHALL CONDUCT HYDROSTATIC PRESSURE TESTING FOR ALL PIPES AND MAKE SURE THERE ARE NO LEAKS PRIOR TO BEING CONCEALED/COVERED/EMBEDDED.

THE CONTRACTOR SHALL COORDINATE WITH PUMP SUPPLIER & PUMP INSTALLER AND SHALL TEST THE SYSTEM AS SOON AS POSSIBLE ENSURING ADEQUATE WATER FLOW RATE AND PRESSURE TO THE WATERLINES. ANY ISSUE SHALL BE DEALT WITH TO AVOID RETROFITTING WORKS.

PRIOR TO PURCHASING AND INSTALLATION OF WATER HEATERS, THE CONTRACTOR SHALL COORDINATE WITH WATER HEATER SUPPLIER & INSTALLER. THEY SHALL VERIFY AND ENSURE WATER HEATER COMPATIBILITY WITH THE SHOWER HEAD/LAVATORY FAUCET/TUB FILLER/OTHER FIXTURES AND ENSURE ADEQUATE WATER PRESSURE AND WATER FLOW RATE. ANY ISSUE SHOULD BE DEALT WITH AS EARLY ON TO AVOID ANY RETROFITTING WORKS.

ALL FIXTURE AND EQUIPMENT SPECIFICATIONS, DIMENSIONS, CLEARANCES, INSTALLATION REQUIREMENTS, NECESSARY STUBOUTS AND/OR PROMISONS, ITEM STOCK AVAILABILITY, AND THE LINES SHALL BE VERIFIED BY THE CONTRACTOR WITH THE RESPECTIVE MANUFACTURER/SUPPLIER PRIOR TO START OF CONSTRUCTION.

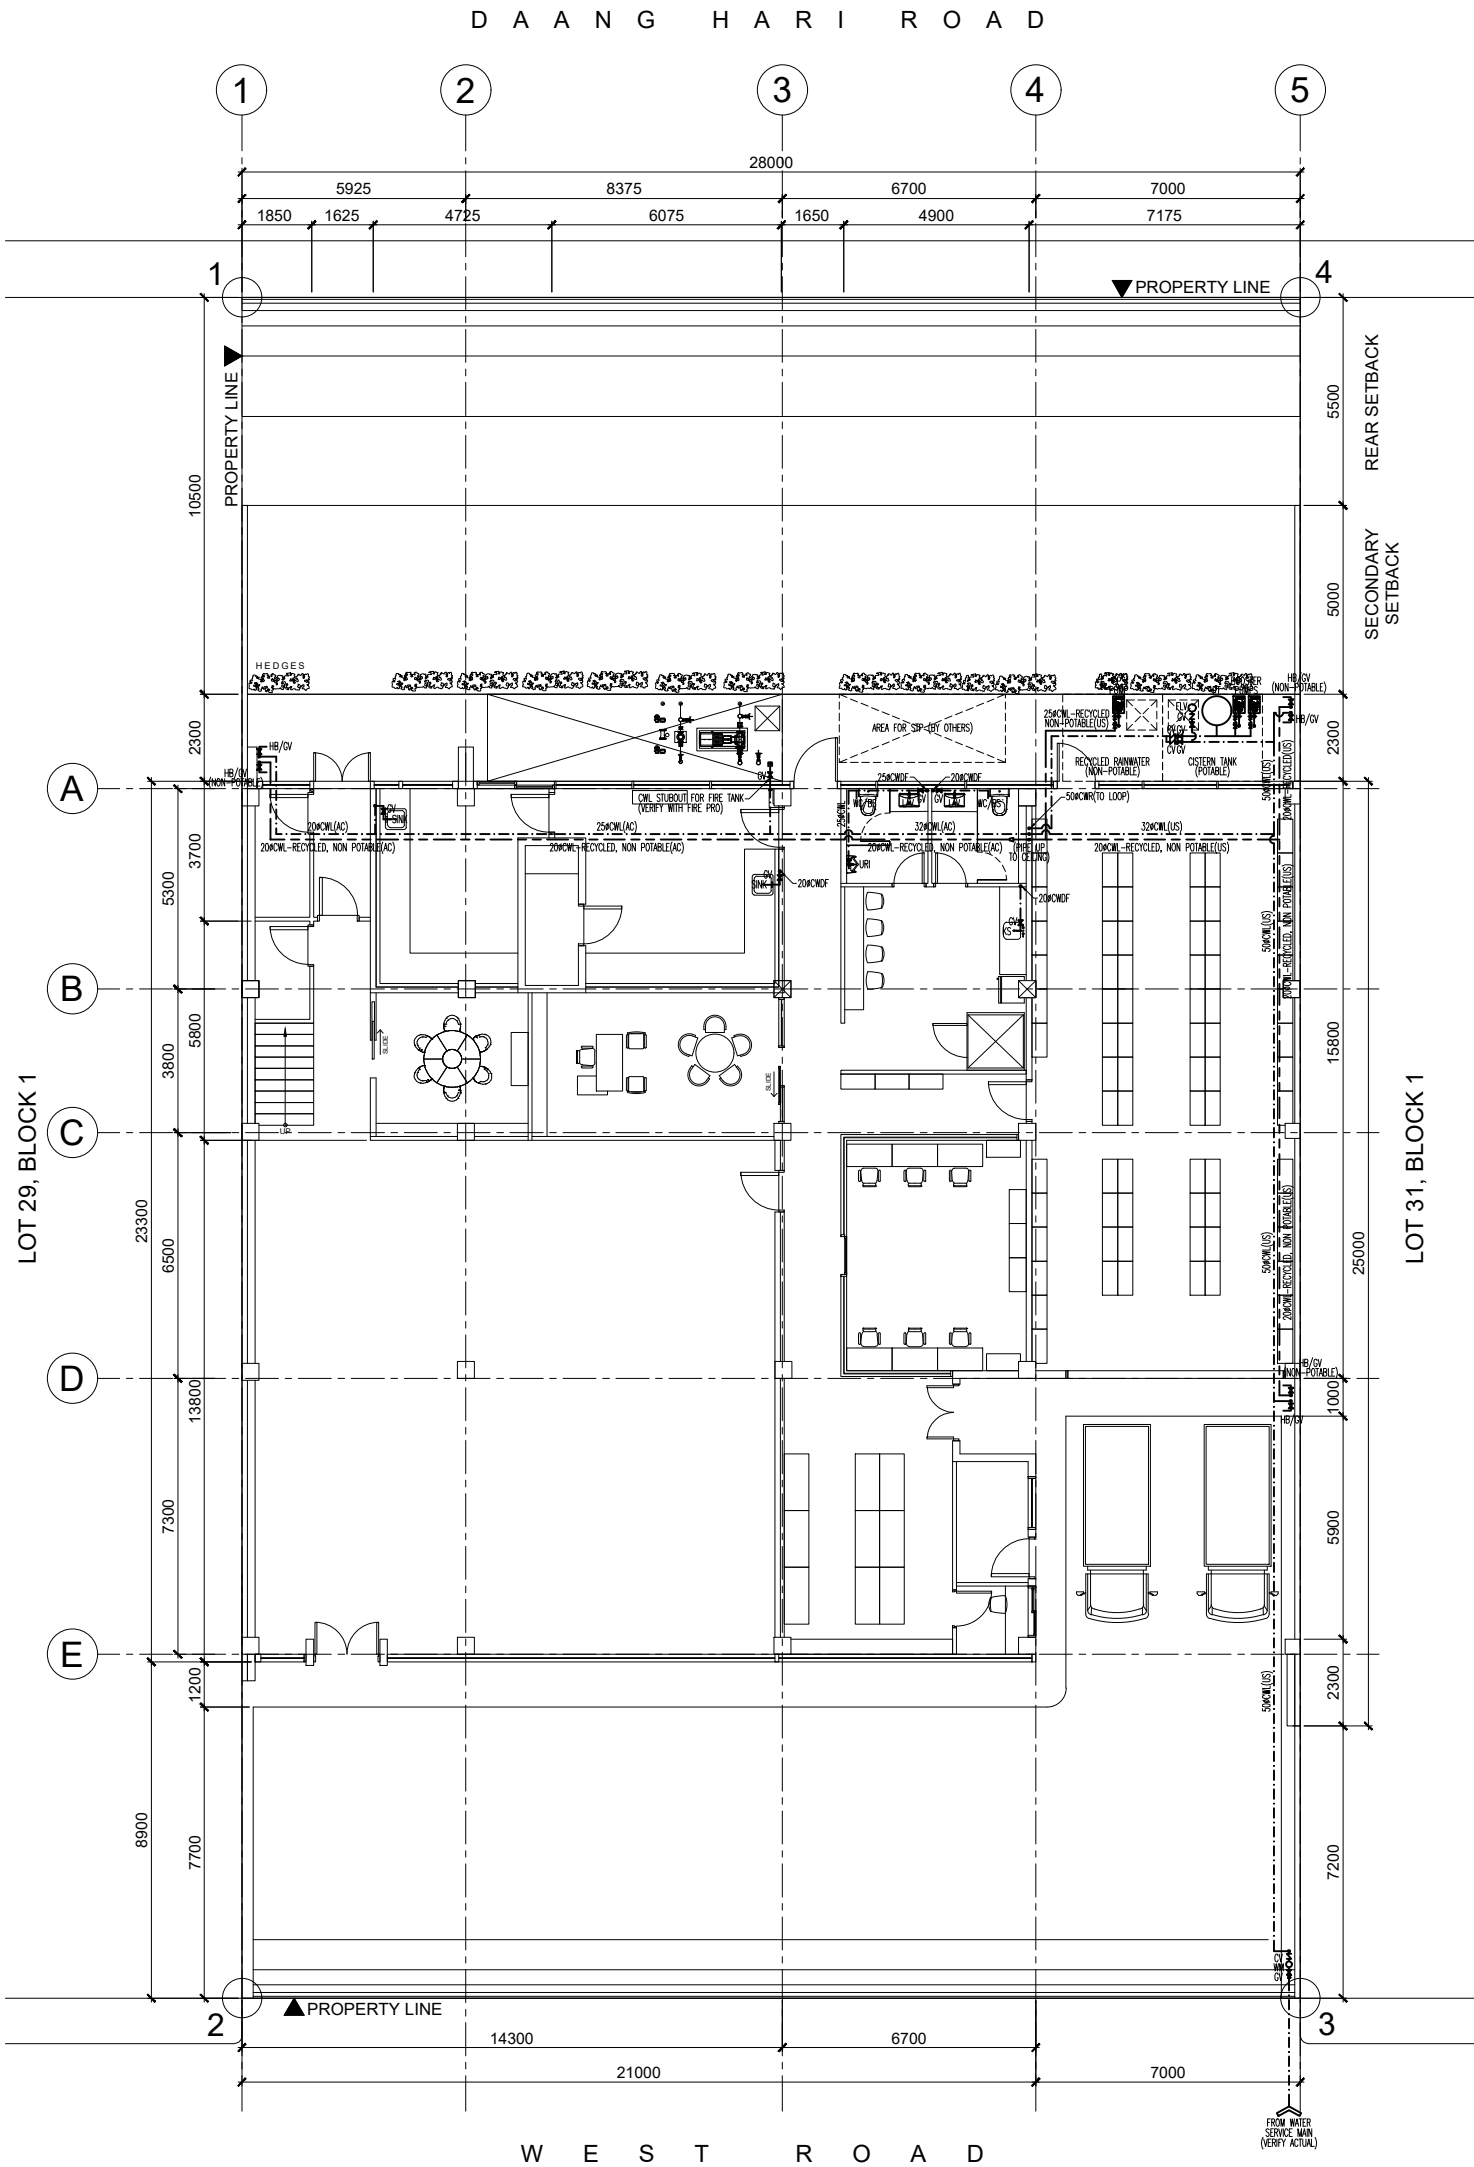

WATERLINE LAYOUT
1
P 06
GROUND FLOOR PLAN
SCALE 1:200 M



Redius
ARCHITECTURE

108 PERBA ST., MEZZANINE,
FLOOR GREENBELT MANSION,
LEGAZPI CITY, ALABANG WEST, LAS PINAS
CITY
(02)256-4984 @rediusarchitecture

PROJECT TITLE:

**SPEEDEDGE -
SHOOTING RANGE**

PROJECT TYPE:

**2-STOREY COMMERCIAL
BUILDING**

ADDRESS:

LOT 30 BLOCK 1 WEST RD.,
ALABANG WEST, LAS PINAS
CITY

CLIENT:

MR. EDWARD RIVERA

R.A. 9286 (ARCHITECTURE LAW OF 2004) SECTION 33.
DRAWINGS, SPECIFICATIONS AND OTHER CONTRACT
DOCUMENTS, ONLY ISSUED, SIGNED OR SEALED AS
REQUIRED BY THE ARCHITECT. ANY REVISIONS, ADDITIONS
AND DOCUMENTS OF THE ARCHITECT, WHETHER THE OBJECT
UNLAWFUL FOR ANY PERSON TO DISSEMINATE OR TO MAKE
COPIES OF AND DOCUMENTS FOR USE IN THE REPRODUCTION OF
THE PROJECT OR FOR ANY OTHER PURPOSE, WITHOUT THE WRITTEN
CONSENT OF ARCHITECT OR AUTHOR OF SAID DOCUMENTS.

MASTER PLUMBER
NEIL KARLO C. DEL MUNDO

PRG NO.: 6294
PTR NO.: 2441289

DRAWN BY:

CHECKED BY:

DATE: 06-02-2025
REVISION NO.: 01

SHEET CONTENTS:
AS SHOWN

SHEET NUMBER:

P-06

06 OF 13



Radius
ARCHITECTURE

108 PEREA ST., MEZZANINE,
FLOOR GREENBELT MANSION,
LAS VEGAS, NEVADA 89101 CITY
LE69471220 PHILIPPINES
(02)256-4984 @radiusarchitecture

PROJECT TITLE:

**SPEEDEDGE -
SHOOTING RANGE**

PROJECT TYPE:

**2-STOREY COMMERCIAL
BUILDING**

ADDRESS:

LOT 30 BLOCK 1 WEST RD.,
ALABANG WEST LAS PINAS
CITY

CLIENT:

MR. EDWARD RIVERA

R.A. 9286 ARCHITECTURE LAW OF 2004 SECTION 33.
DRAWINGS AND SPECIFICATIONS AND OTHER CONTRACT
DOCUMENTS, ONLY ISSUED, SIGNED OR SEALED AS
REQUIRED BY THE ARCHITECT. ANY REVISIONS, AMENDMENTS
AND DOCUMENTS OF THE ARCHITECT, WHETHER THE OBJECT
UNLAWFUL FOR ANY PERSON TO DISPOSE OF OR TO MAKE
COPIES OF AND DOCUMENTS FOR USE IN THE REGISTRATION OF
EXECUTED PARTY OR IN WHOLE, WITHOUT THE WRITTEN
CONSENT OF ARCHITECT OR AUTHORITY OF SAID DOCUMENTS.

MASTER PLUMBER
NEIL KARLO C. DEL MUNDO

PRG NO.: 6294
PTR NO.: 2441289

DRAWN BY:

CHECKED BY:


DATE: **06-02-2025** REVISION NO.: **01**

SHEET CONTENTS:
AS SHOWN

SHEET NUMBER:

P-07

07 OF 13

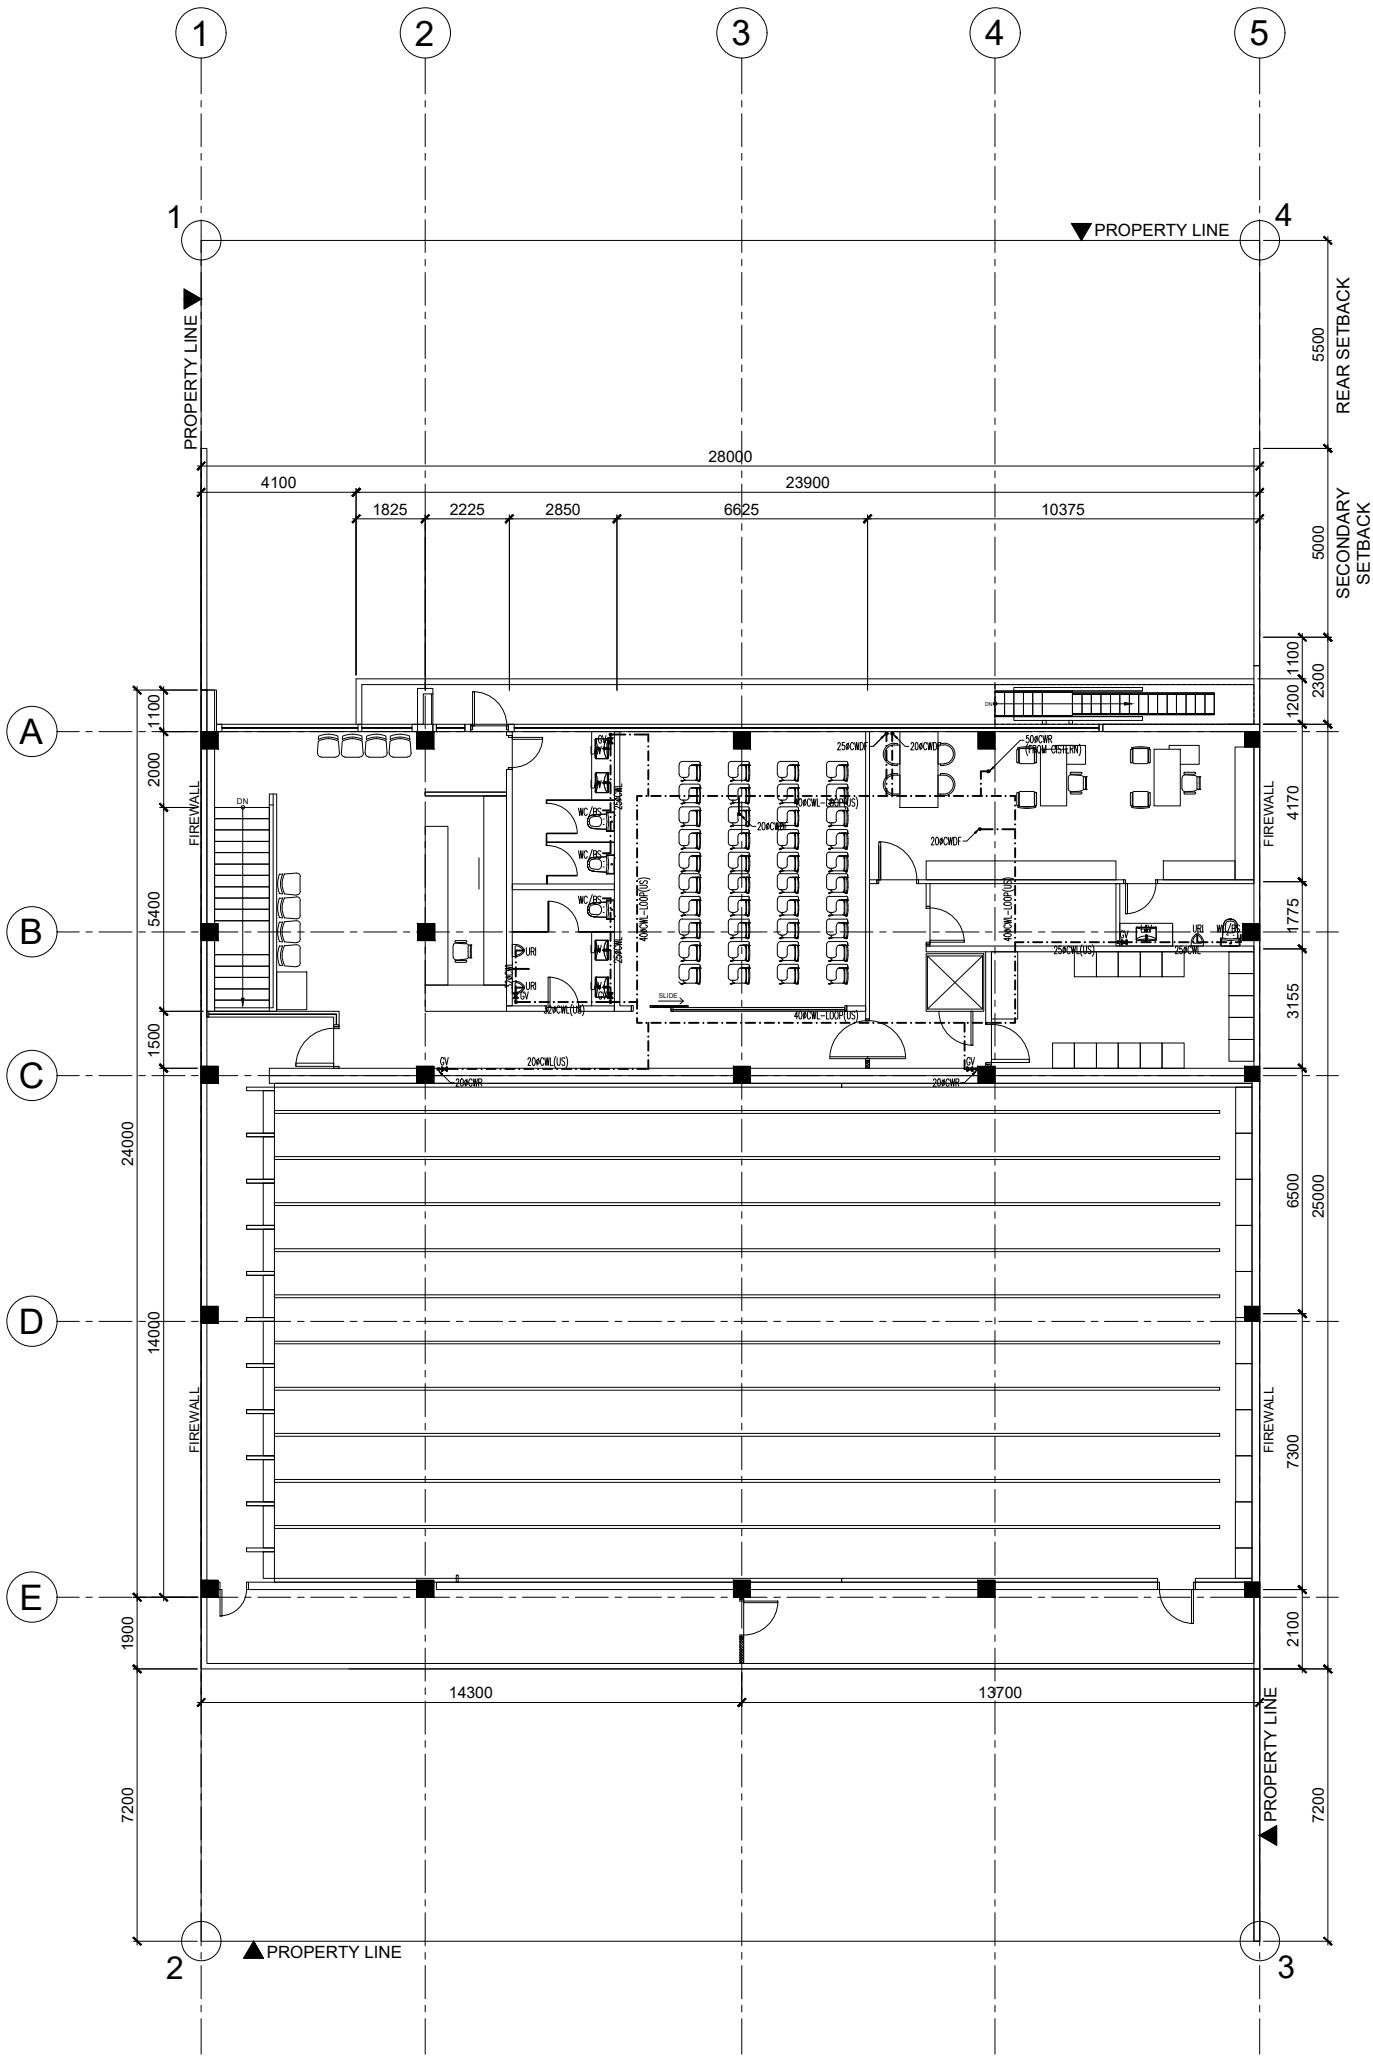

WATERLINE LAYOUT
1 SECOND FLOOR PLAN
SCALE 1:200 M
P 07



PROJECT TITLE:

PROJECT TYPE:

ADDRESS

CLIENT

MR. EDWARD RIVERA

1000000

IL KARLO C. DEL MUNDO

PTR NO.: 244128

DRAWN BY

CHECKED

06-02-2021

AS SHOWN

P-08


08 OF 13




ROOF PLAN

SCALE

1:200 M

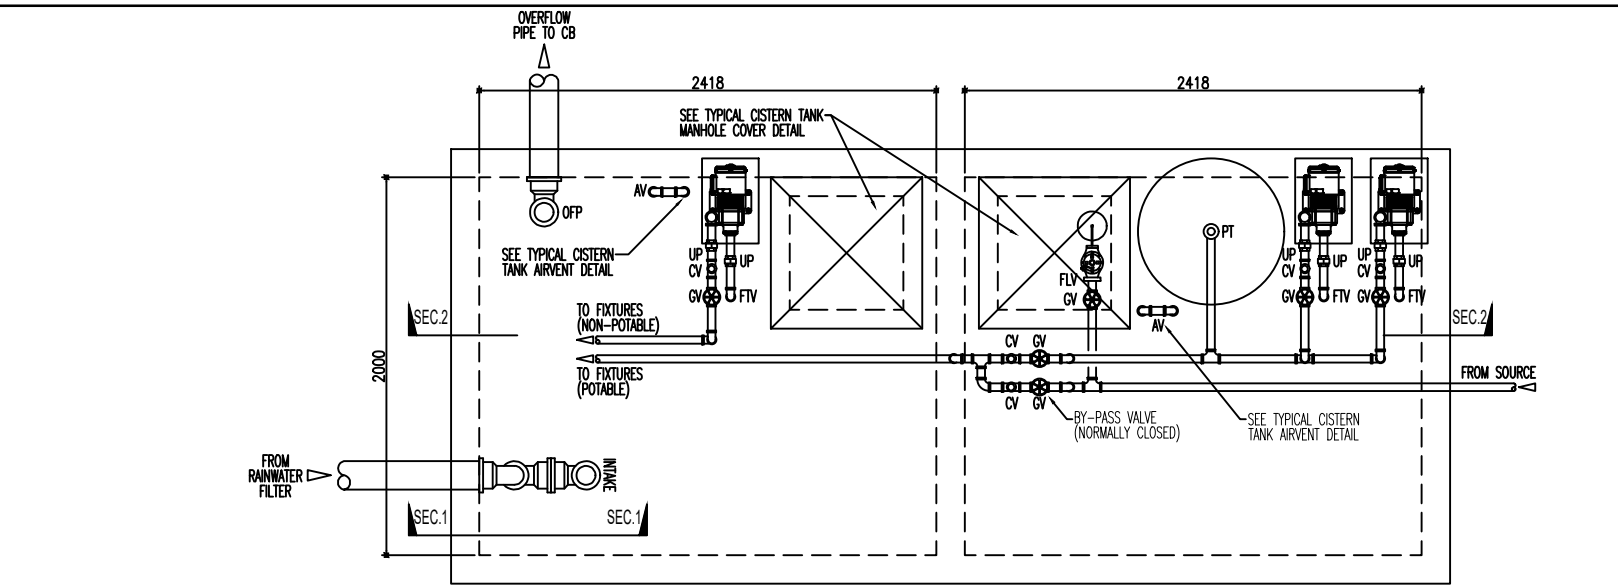

PLAN VIEW

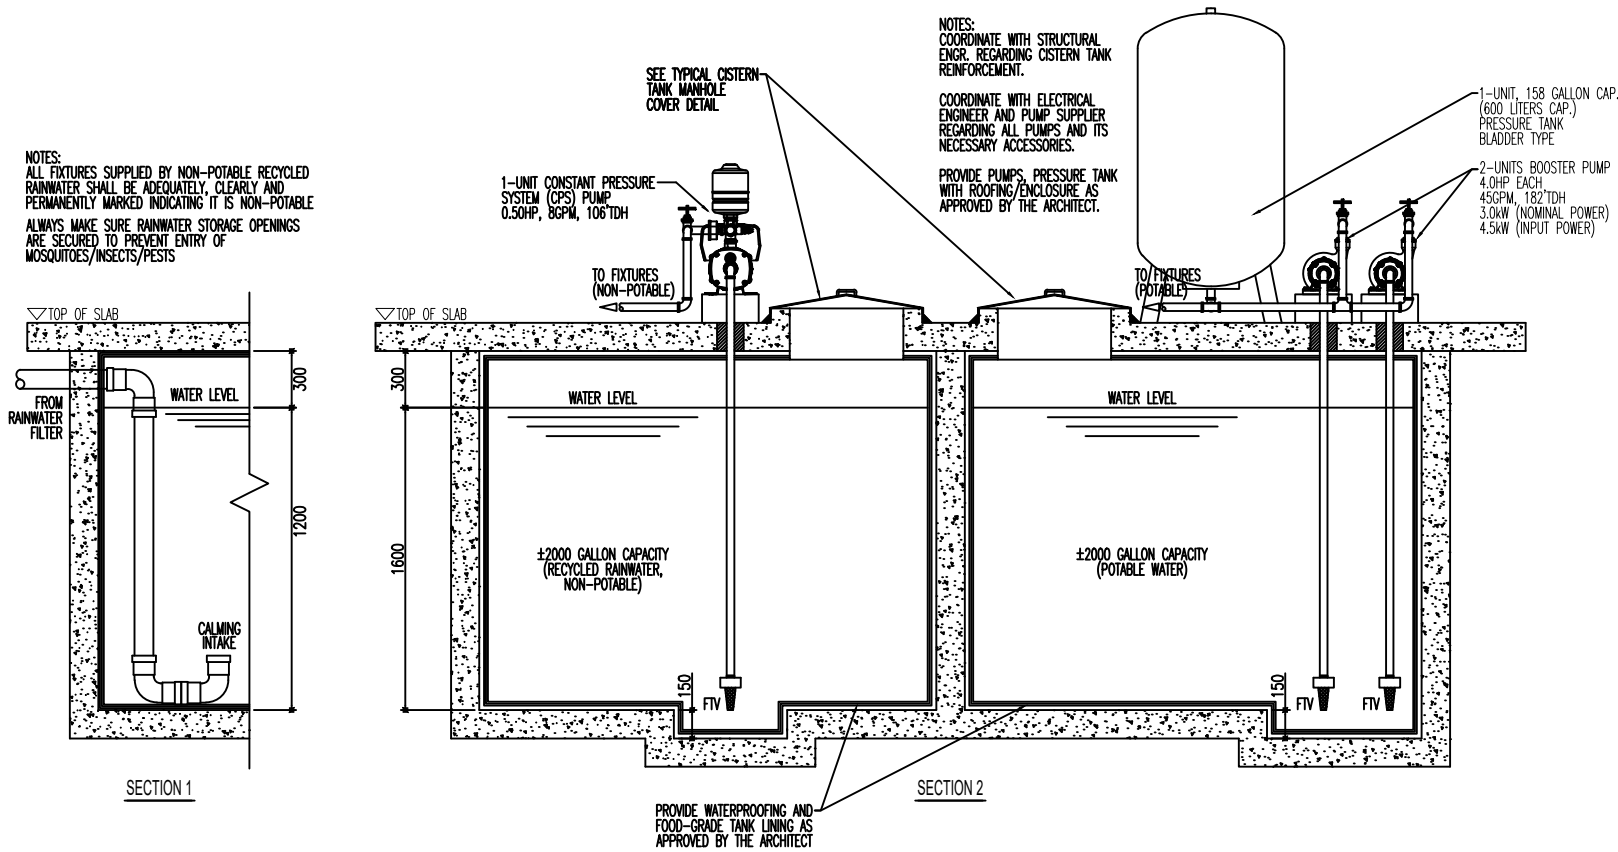


RECYCLED RAINWATER TANK DETAIL & POTABLE WATER CISTERN TANK DETAIL


2
P 09

SCALE


NTS

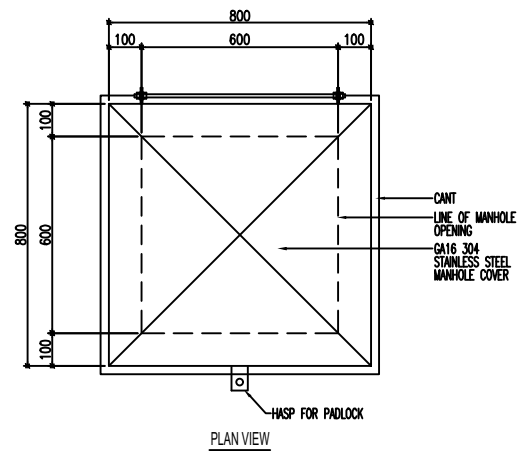

PLAN VIEW

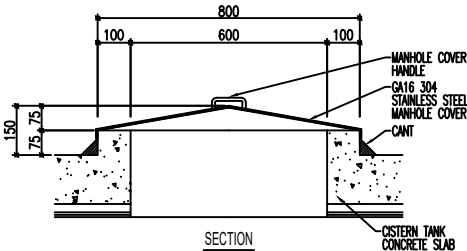

SECTION

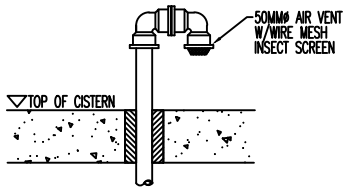

SECTION

TYPICAL S/S MANHOLE COVER FOR CISTERN TANK

3
P 09

SCALE

NTS

DETAIL OF CISTERN TANK AIR VENT (AV)

4
P 09

SCALE

NTS



Redins
ARCHITECTURE

108 PEREA ST., MEZZANINE,
FLOOR GREENBELT TOWNION,
LEGASPI 1220 PHILIPPINES
(02)256-4984 @redinsarchitecture

PROJECT TITLE:

**SPEEDEDGE -
SHOOTING RANGE**

PROJECT TYPE:

**2-STORY COMMERCIAL
BUILDING**

ADDRESS:

LOT 30 BLOCK 1 WEST RD.,
ALABANG WEST LAS PINAS
CITY

CLIENT:

MR. EDWARD RIVERA

R.A. 9286 ARCHITECTURE LAW OF 2004 SECTION 33.

DRAWINGS AND SPECIFICATIONS AND OTHER CONTRACT
DOCUMENTS, ONLY ISSUED, STAMPED OR SIGNED AS
REQUIRED BY THE ARCHITECT, WITHOUT THE DIRECT
INTERFERENCE OF THE ARCHITECT, SHALL BE THE
SOLE RESPONSIBILITY OF THE ARCHITECT. NO TO MAKE
COPIES OF AND DOCUMENTS FOR USE IN THE REVISION OF
OR FOR ANY OTHER PURPOSES WITHOUT THE WRITTEN
CONSENT OF ARCHITECT OR AUTHOR OF SAID DOCUMENTS.

MASTER PLUMBER
NEIL KARLO C. DEL MUNDO
PRG NO.: 6294
PTR NO.: 2417289

DRAWN BY:

CHECKED BY:

DATE:

06-02-2025

REVISION NO.:

01

SHEET CONTENTS:
AS SHOWN

SHEET NUMBER:

P-09

09 OF 13

IMPORTANT NOTES:

ALL PLUMBING FIXTURES WITHOUT THEIR OWN INTEGRATED OR BUILT-IN TRAPS SHALL BE PROVIDED WITH ADEQUATELY SIZED P-TRAPS TO PREVENT SEWER GASES BACKING UP.

PROVIDE PROPER VENT PIPES AS SHOWN IN THE PLUMBING PLANS TO PROTECT WATER INSIDE P-TRAPS FROM SIPHONAGE, ENSURING PROPER OPERATION TO PREVENT SEWER GASES FROM BACKING-UP.

PROVIDE CLEANOUTS AS SHOWN IN THE PLUMBING PLANS AND DETAILS TO ALLOW PROPER MAINTENANCE OF THE PIPE SYSTEM.

MAINTAIN PROPER PIPE SLOPE FOR ALL PIPES & LINES, SEE P-01 PLUMBING NOTES


PROVIDE ACCESS PANELS FOR MAINTENANCE OF ALL CLEANOUTS AS APPROVED BY THE ARCHITECT

PROVIDE ADEQUATE PIPE SUPPORTS AND HANGERS, SEE P-01 TYP. PIPE HANGER DETAIL

THE CONTRACTOR SHALL TEST ALL PIPES TO MAKE SURE THERE ARE NO LEAKS AND FOUL ODORS FROM THE PIPE SYSTEM.

ALL FIXTURE AND EQUIPMENT SPECIFICATIONS, DIMENSIONS, CLEARANCES, INSTALLATION REQUIREMENTS, NECESSARY STUBOUTS AND/OR PROVISIONS, ITEM STOCK AVAILABILITY, AND THE LIKES SHALL BE VERIFIED BY THE CONTRACTOR WITH THE RESPECTIVE MANUFACTURER/SUPPLIER PRIOR TO START OF CONSTRUCTION.

PROVIDE PROPER P-TRAP FOR ALL FCO'S. FOLLOW AIRCON MANUFACTURER/SUPPLIER INSTALLATION INSTRUCTIONS.

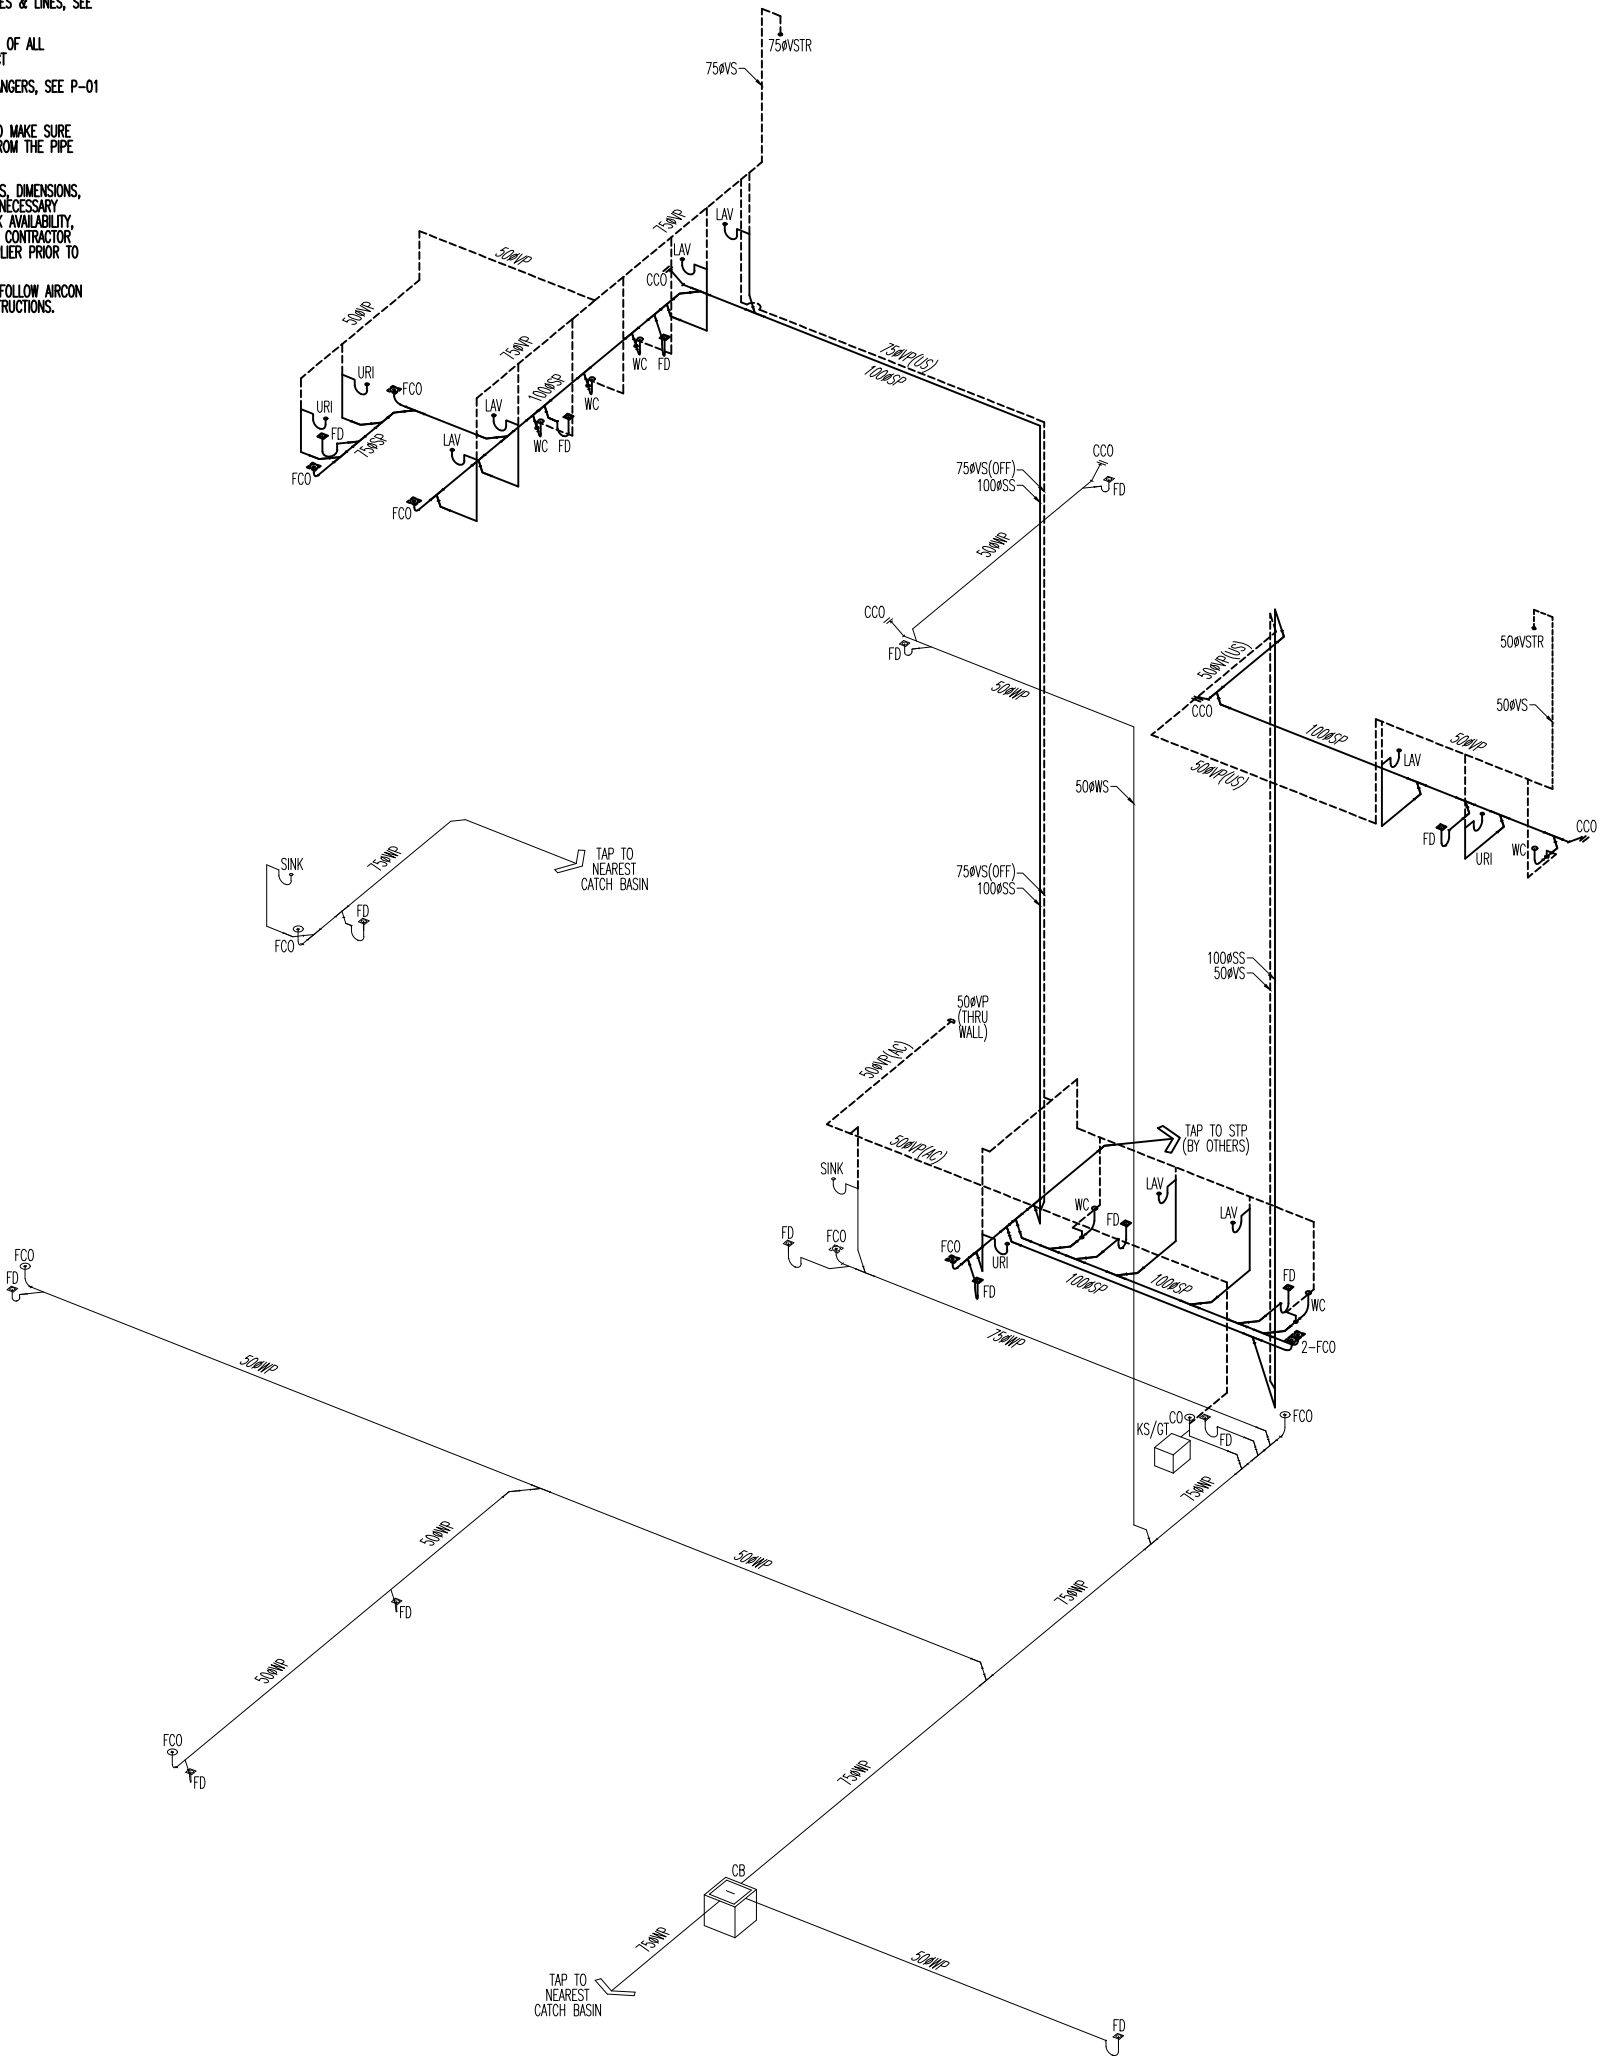

SOIL, WASTE & VENT PIPE
1
P 10 ISOMETRIC LAYOUT
SCALE NTS



Radlins
ARCHITECTURE

108 PEREA ST., MEZZANINE
FLOOR, GREENBELT TOWNSHIP,
LEONARD, ALABAMA 36034
(205) 256-4984 @radlinsarchitecture

PROJECT TITLE:

**SPEEDEDGE -
SHOOTING RANGE**

PROJECT TYPE:

**2-STORY COMMERCIAL
BUILDING**

ADDRESS:

LOT 30 BLOCK 1 WEST RD.,
ALABAMA WEST LAS PINAS
CITY

CLIENT:

MR. EDWARD RIVERA

R.A. 2026 ARCHITECTURE (LAW OF 2004) SECTION 33.
DRAWINGS, ONLY ISSUED, STAMPED OR SEALED AS
INDICATED HEREON, SHALL BE VALID FOR THE DESIGN, PREPARE
AND DOCUMENTS OF THE PROJECT, WHETHER THE PROJECT
IS COMPLETED OR NOT, AND FOR ANY PERSON TO DUPLICATE OR TO MAKE
COPIES OF AND DOCUMENTS FOR USE IN THE REVISION OR
REVISIONS OF THE PROJECT, WITHOUT THE WRITTEN
CONSENT OF ARCHITECT OR ARCHITECT OF RECORD.

MASTER PLUMBER
NEIL KARLO C. DEL MUNDO

PRG NO.: 6294
PTR NO.: 2441289

DRAWN BY:

CHECKED BY:

DATE: 06-02-2025
REVISION NO.: 01

SHEET CONTENTS:
AS SHOWN

SHEET NUMBER:

P-10

10 OF 13

IMPORTANT NOTES:


VERIFY WATER TANKS, PUMPS, PUMP CONTROLLER, FLOAT SWITCH, PRESSURE TANK, AND OTHER NECESSARY EQUIPMENT SPECIFICATIONS AND THEIR SPECIFIC INSTALLATION REQUIREMENTS WITH THE RESPECTIVE MANUFACTURER/SUPPLIER PRIOR TO START OF CONSTRUCTION.

THE CONTRACTOR SHALL CONDUCT HYDROSTATIC PRESSURE TESTING FOR ALL PIPES AND MAKE SURE THERE ARE NO LEAKS PRIOR TO BEING CONCEALED/COVERED/EMBEDDED.

THE CONTRACTOR SHALL COORDINATE WITH PUMP SUPPLIER & PUMP INSTALLER AND SHALL TEST THE SYSTEM AS SOON AS POSSIBLE ENSURING ADEQUATE WATER FLOW RATE AND PRESSURE TO THE WATERLINES. ANY ISSUE SHALL BE DEALT WITH TO AVOID RETROFITTING WORKS.

PRIOR TO PURCHASING AND INSTALLATION OF WATER HEATERS, THE CONTRACTOR SHALL COORDINATE WITH WATER HEATER SUPPLIER & INSTALLER. THEY SHALL VERIFY AND ENSURE WATER HEATER COMPATIBILITY WITH THE SHOWER HEAD/LAVATORY FAUCET/TUB FILLER/OTHER FIXTURES AND ENSURE ADEQUATE WATER PRESSURE AND WATER FLOW RATE. ANY ISSUE SHOULD BE DEALT WITH AS EARLY ON TO AVOID ANY RETROFITTING WORKS.

ALL FIXTURE AND EQUIPMENT SPECIFICATIONS, DIMENSIONS, CLEARANCES, INSTALLATION REQUIREMENTS, NECESSARY STUBOUTS AND/OR PROVISIONS, ITEM STOCK AVAILABILITY, AND THE LIKES SHALL BE VERIFIED BY THE CONTRACTOR WITH THE RESPECTIVE MANUFACTURER/SUPPLIER PRIOR TO START OF CONSTRUCTION.

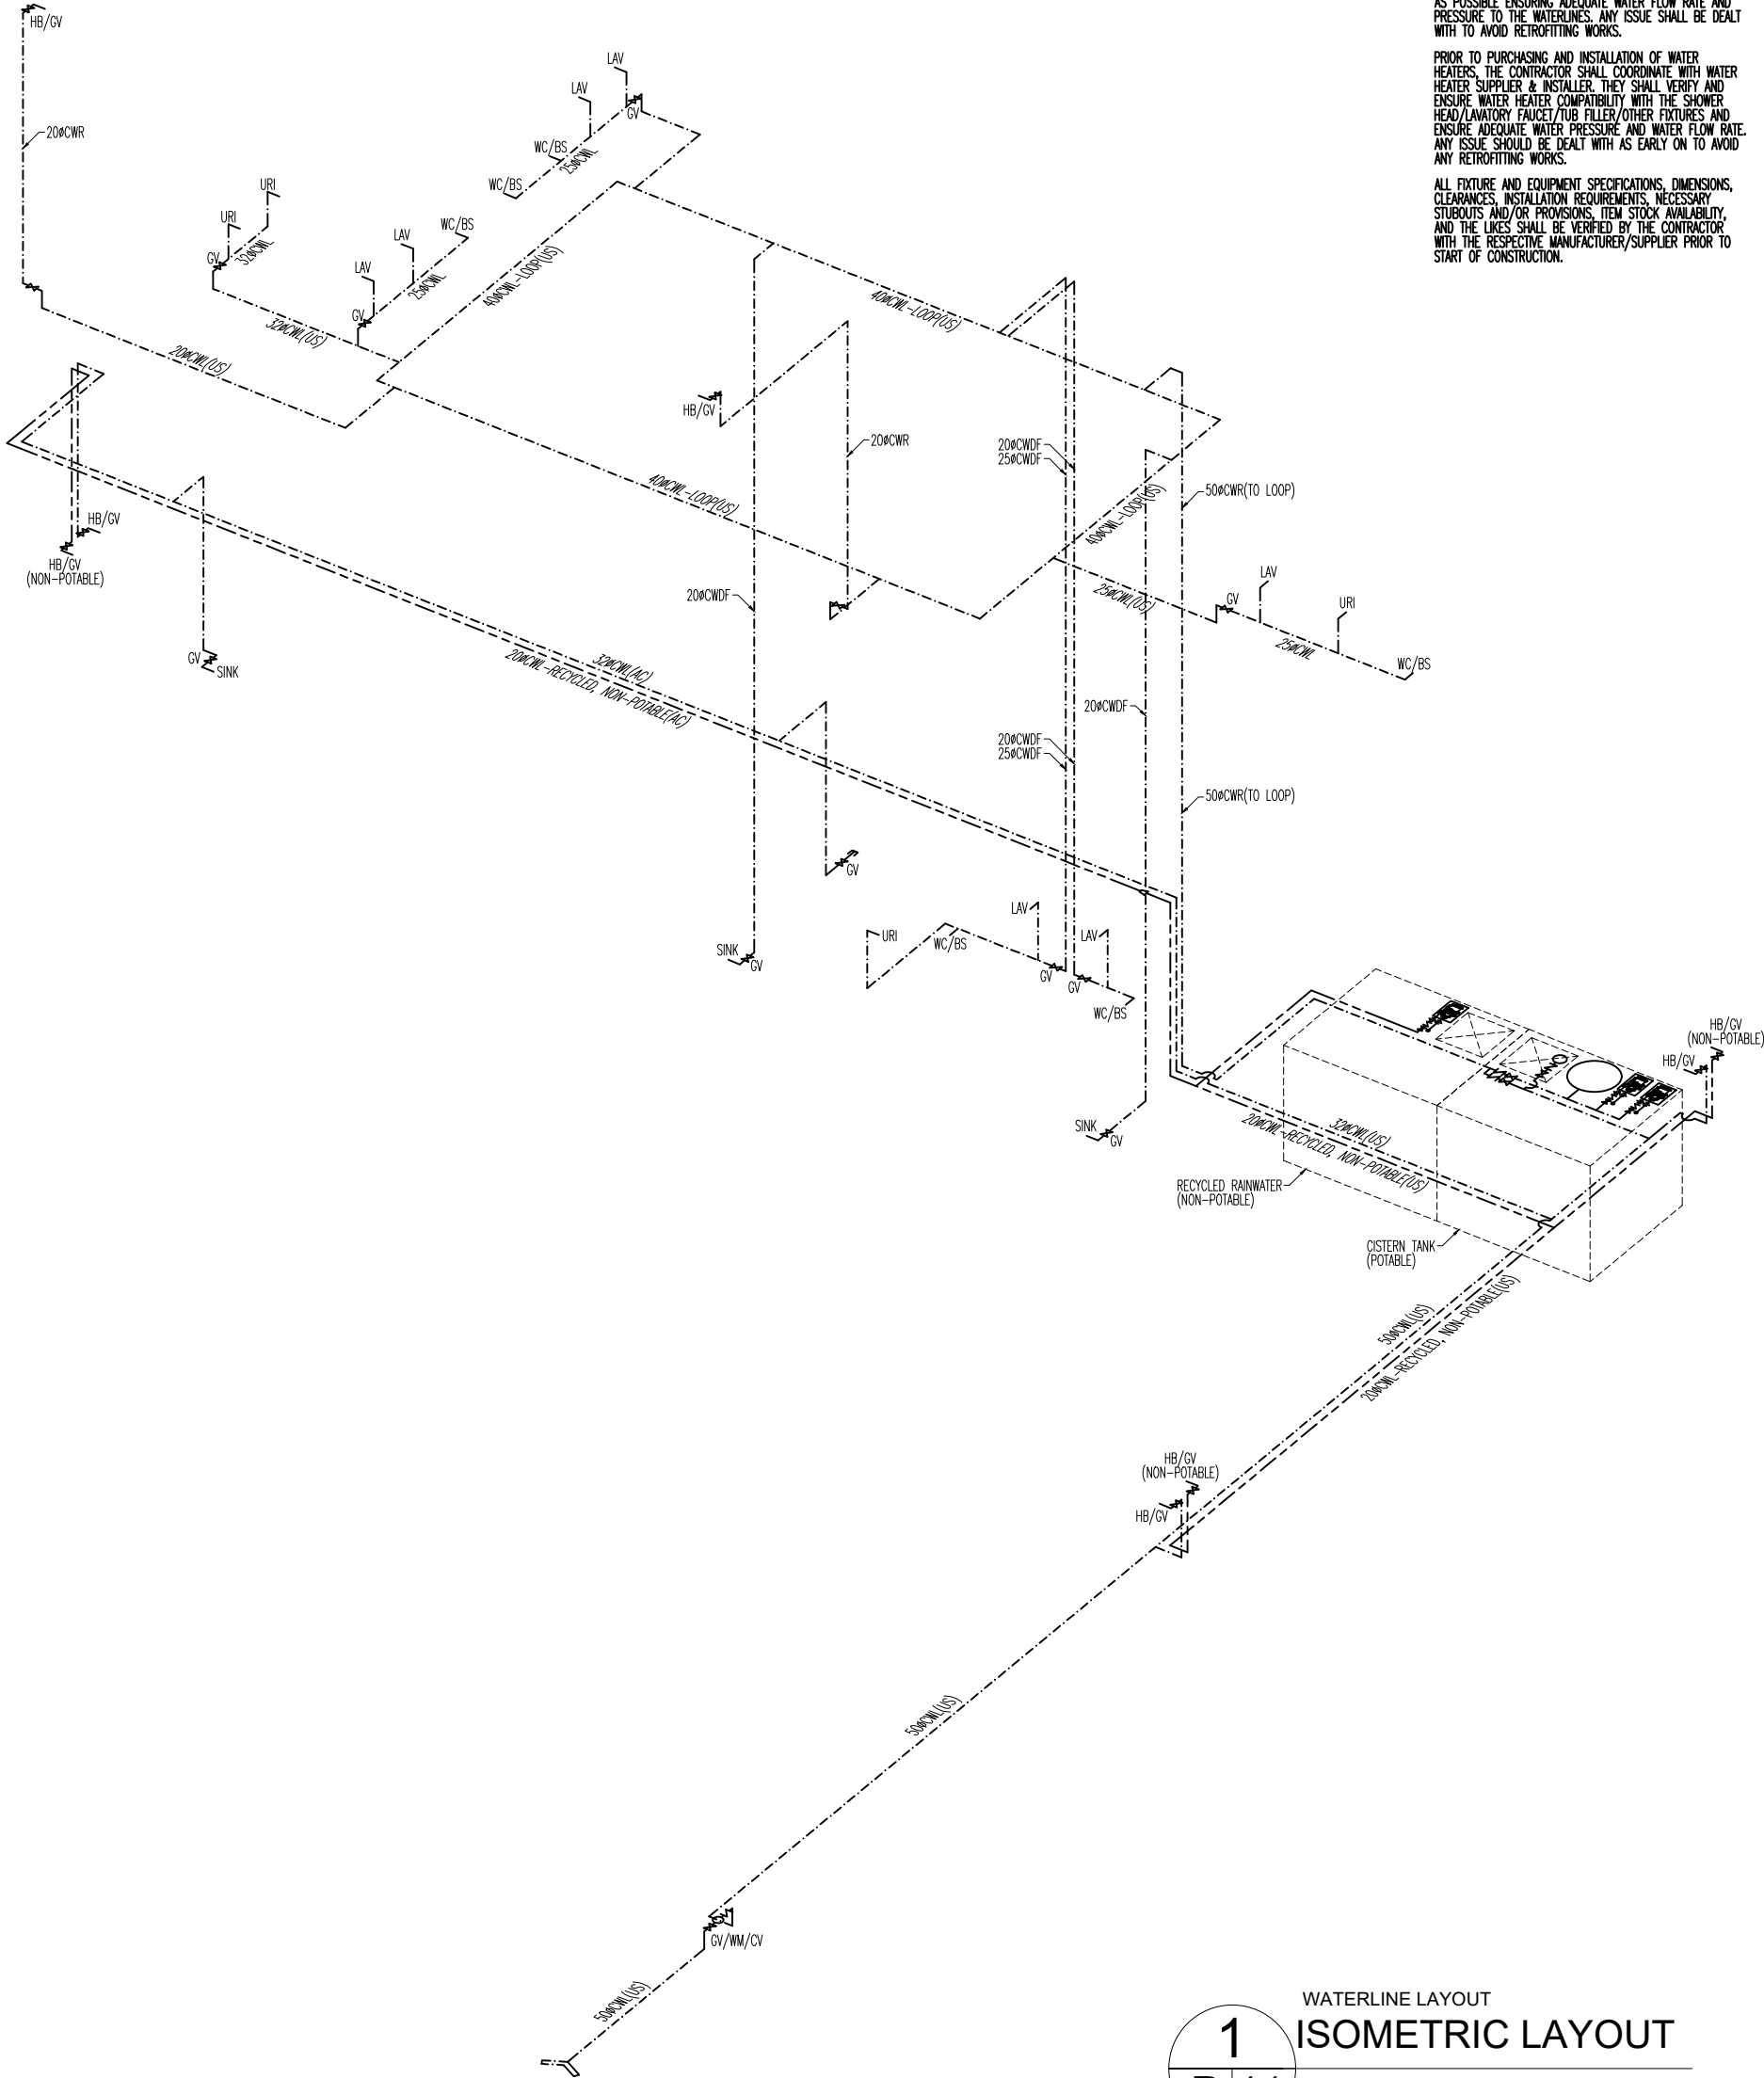

WATERLINE LAYOUT
1
P 11 ISOMETRIC LAYOUT
SCALE NTS



Radline
ARCHITECTURE
106 PEREA ST., MEZZANINE
FLOOR, GREENBELT TOWNSHIP,
LEONARDTOWN, MARYLAND CITY
(02)256-4984 @radlinearchitecture

PROJECT TITLE:

**SPEEDEDGE -
SHOOTING RANGE**

PROJECT TYPE:

**2-STORY COMMERCIAL
BUILDING**

ADDRESS:

LOT 30 BLOCK 1 WEST RD.,
ALABAMA WEST LAS PINAS
CITY

CLIENT:

MR. EDWARD RIVERA

R.A. 2026 ARCHITECTURE LAW OF 2004 SECTION 33.
DRAWINGS AND SPECIFICATIONS AND OTHER CONTRACT
DOCUMENTS ONLY. REVISION, STAMPED OR, REMAINS AS
EVIDENCE OF THE ARCHITECT'S REVIEW OF THE PROJECT
AND DOCUMENTS OF THE ARCHITECT. ANY OTHER
UNLAWFUL FOR ANY PERSON TO DUPLICATE OR TO MAKE
COPIES OF AND DOCUMENTS FOR USE IN THE REVISION OR
EXECUTION OF ANY PROJECT OR IN WHOLE, WITHOUT THE WRITTEN
CONSENT OF ARCHITECT OR ARCHITECT OF RECORD.

MASTER PLUMBER
NEIL KARLO C. DEL MUNDO

PRG NO.: 6294
PTR NO.: 2441289

DRAWN BY:

CHECKED BY:

DATE: **06-02-2025**
REVISION NO.: **01**

SHEET CONTENTS:
AS SHOWN

SHEET NUMBER:

P-11

11 OF 13



Radius
ARCHITECTURE

106 PEREA ST., MEZZANINE,
FLOOR GREENBELT TOWNSHIP,
LEONARDUS, ALABAMA CITY
(02)256-4984 @radiusarchitecture

PROJECT TITLE:

SPEEDEDGE -
SHOOTING RANGE

PROJECT TYPE:

2-STOREY COMMERCIAL
BUILDING

ADDRESS:

LOT 30 BLOCK 1 WEST RD.,
ALABAMA WEST LAS PINAS
CITY

CLIENT:

MR. EDWARD RIVERA

R.A. 2026 ARCHITECTURE LAW OF 2004 SECTION 33.
DRAWINGS AND SPECIFICATIONS AND OTHER CONTRACT
DOCUMENTS, ONLY ISSUED, STAMPED OR SIGNED AS
THE ARCHITECT'S AUTHORITY. THE ARCHITECT'S NAME
AND DOCUMENTS OF THE ARCHITECT, WHETHER THE OBJECT
UNLAWFUL FOR ANY PERSON TO DUPLICATE OR TO MAKE
COPIES OF AND DOCUMENTS FOR USE IN THE PRACTICE OF
ARCHITECTURE OR ENGINEERING OR IN THE PRACTICE OF
EXECUTED PARTY OR IN WHOLE, WITHOUT THE WRITTEN
CONSENT OF ARCHITECT OR AUTHOR OF SAID DOCUMENTS.

MASTER PLUMBER
NEIL KARLO C. DEL MUNDO

PRG NO.: 6294
PTR NO.: 2441289

DRAWN BY:

CHECKED BY:


DATE: 06-02-2025
REVISION NO.: 01

SHEET CONTENTS:
AS SHOWN

SHEET NUMBER:

P-12

12 OF 13

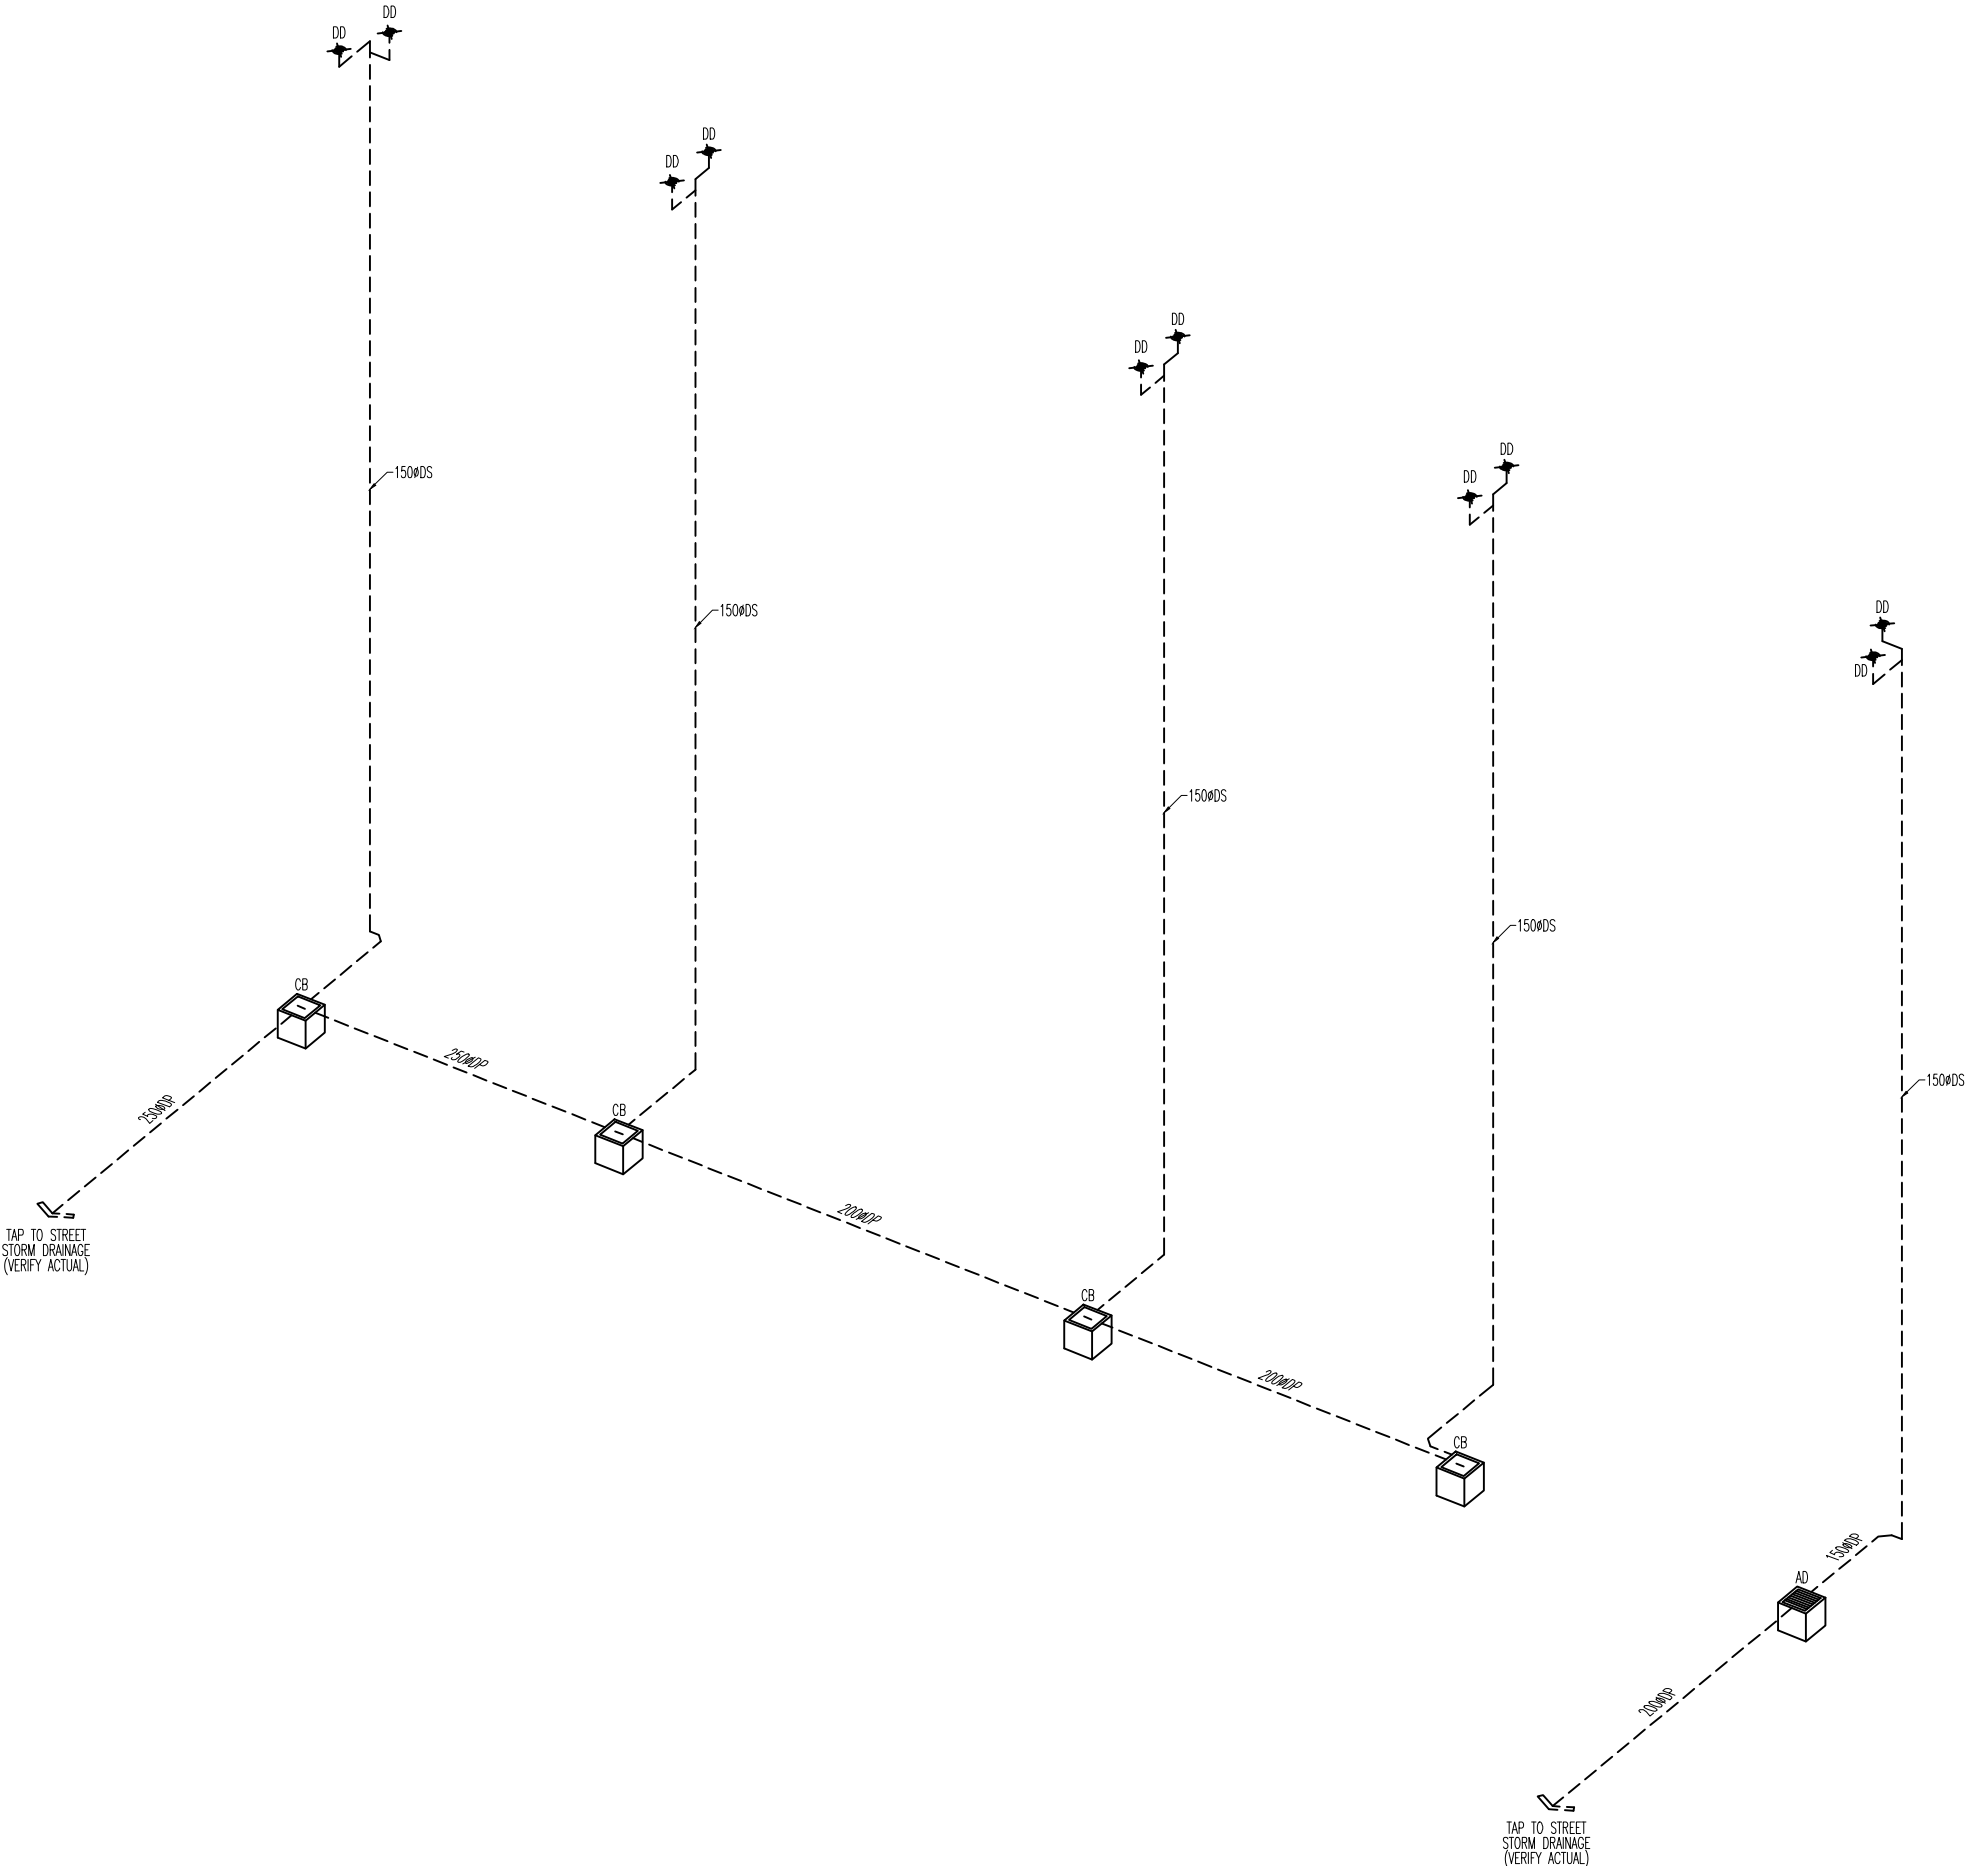

STORM DRAIN LAYOUT
1 ISOMETRIC LAYOUT
P 12 SCALE NTS



Radius
ARCHITECTURE

108 PEREA ST., MEZZANINE
FLOOR, GREENBELT MANSION,
LEGAZPI VILLAGE, MAKATI CITY
1229 PHILIPPINES
(02)256-4984 @radiusarchitecture

PROJECT TITLE:

SPEEDEDGE -
SHOOTING RANGE

PROJECT TYPE:

2-STOREY COMMERCIAL
BUILDING

ADDRESS:

LOT 30 BLOCK 1, WEST RD.,
ALABANG WEST, LAS PINAS
CITY

CLIENT:

MR. EDWARD RIVERA

R.A. 9266 (ARCHITECTURE LAW OF 2004) SECTION 33:
DRAWINGS AND SPECIFICATIONS AND OTHER CONTRACT
DOCUMENTS DULY SIGNED, STAMPED OR SEALED, AS
INSTRUMENTS OF SERVICE, ARE THE INTELLECTUAL PROPERTY
AND DOCUMENTS OF THE ARCHITECT. WHETHER THE OBJECT
FOR WHICH THEY ARE MADE IS EXECUTED OR NOT, IT SHALL BE
UNLAWFUL FOR ANY PERSON TO DUPLICATE OR TO MAKE
COPIES OF SAID DOCUMENTS FOR USE IN THE REPEITION OF
AND FOR OTHER PROJECTS OR BUILDINGS, WHETHER
EXECUTED PARTLY OR IN WHOLE, WITHOUT THE WRITTEN
CONSENT OF ARCHITECT OR AUTHOR OF SAID DOCUMENTS.



MASTER PLUMBER
NEIL KARLO C. DEL MUNDO

PRC NO.: 6294
PTR NO.: 2441289

DRAWN BY:
-

CHECKED BY:
-

DATE:
06-02-2025


REVISION NO.:
01

SHEET CONTENTS:
AS SHOWN

SHEET NUMBER:

P-13

13 OF 13

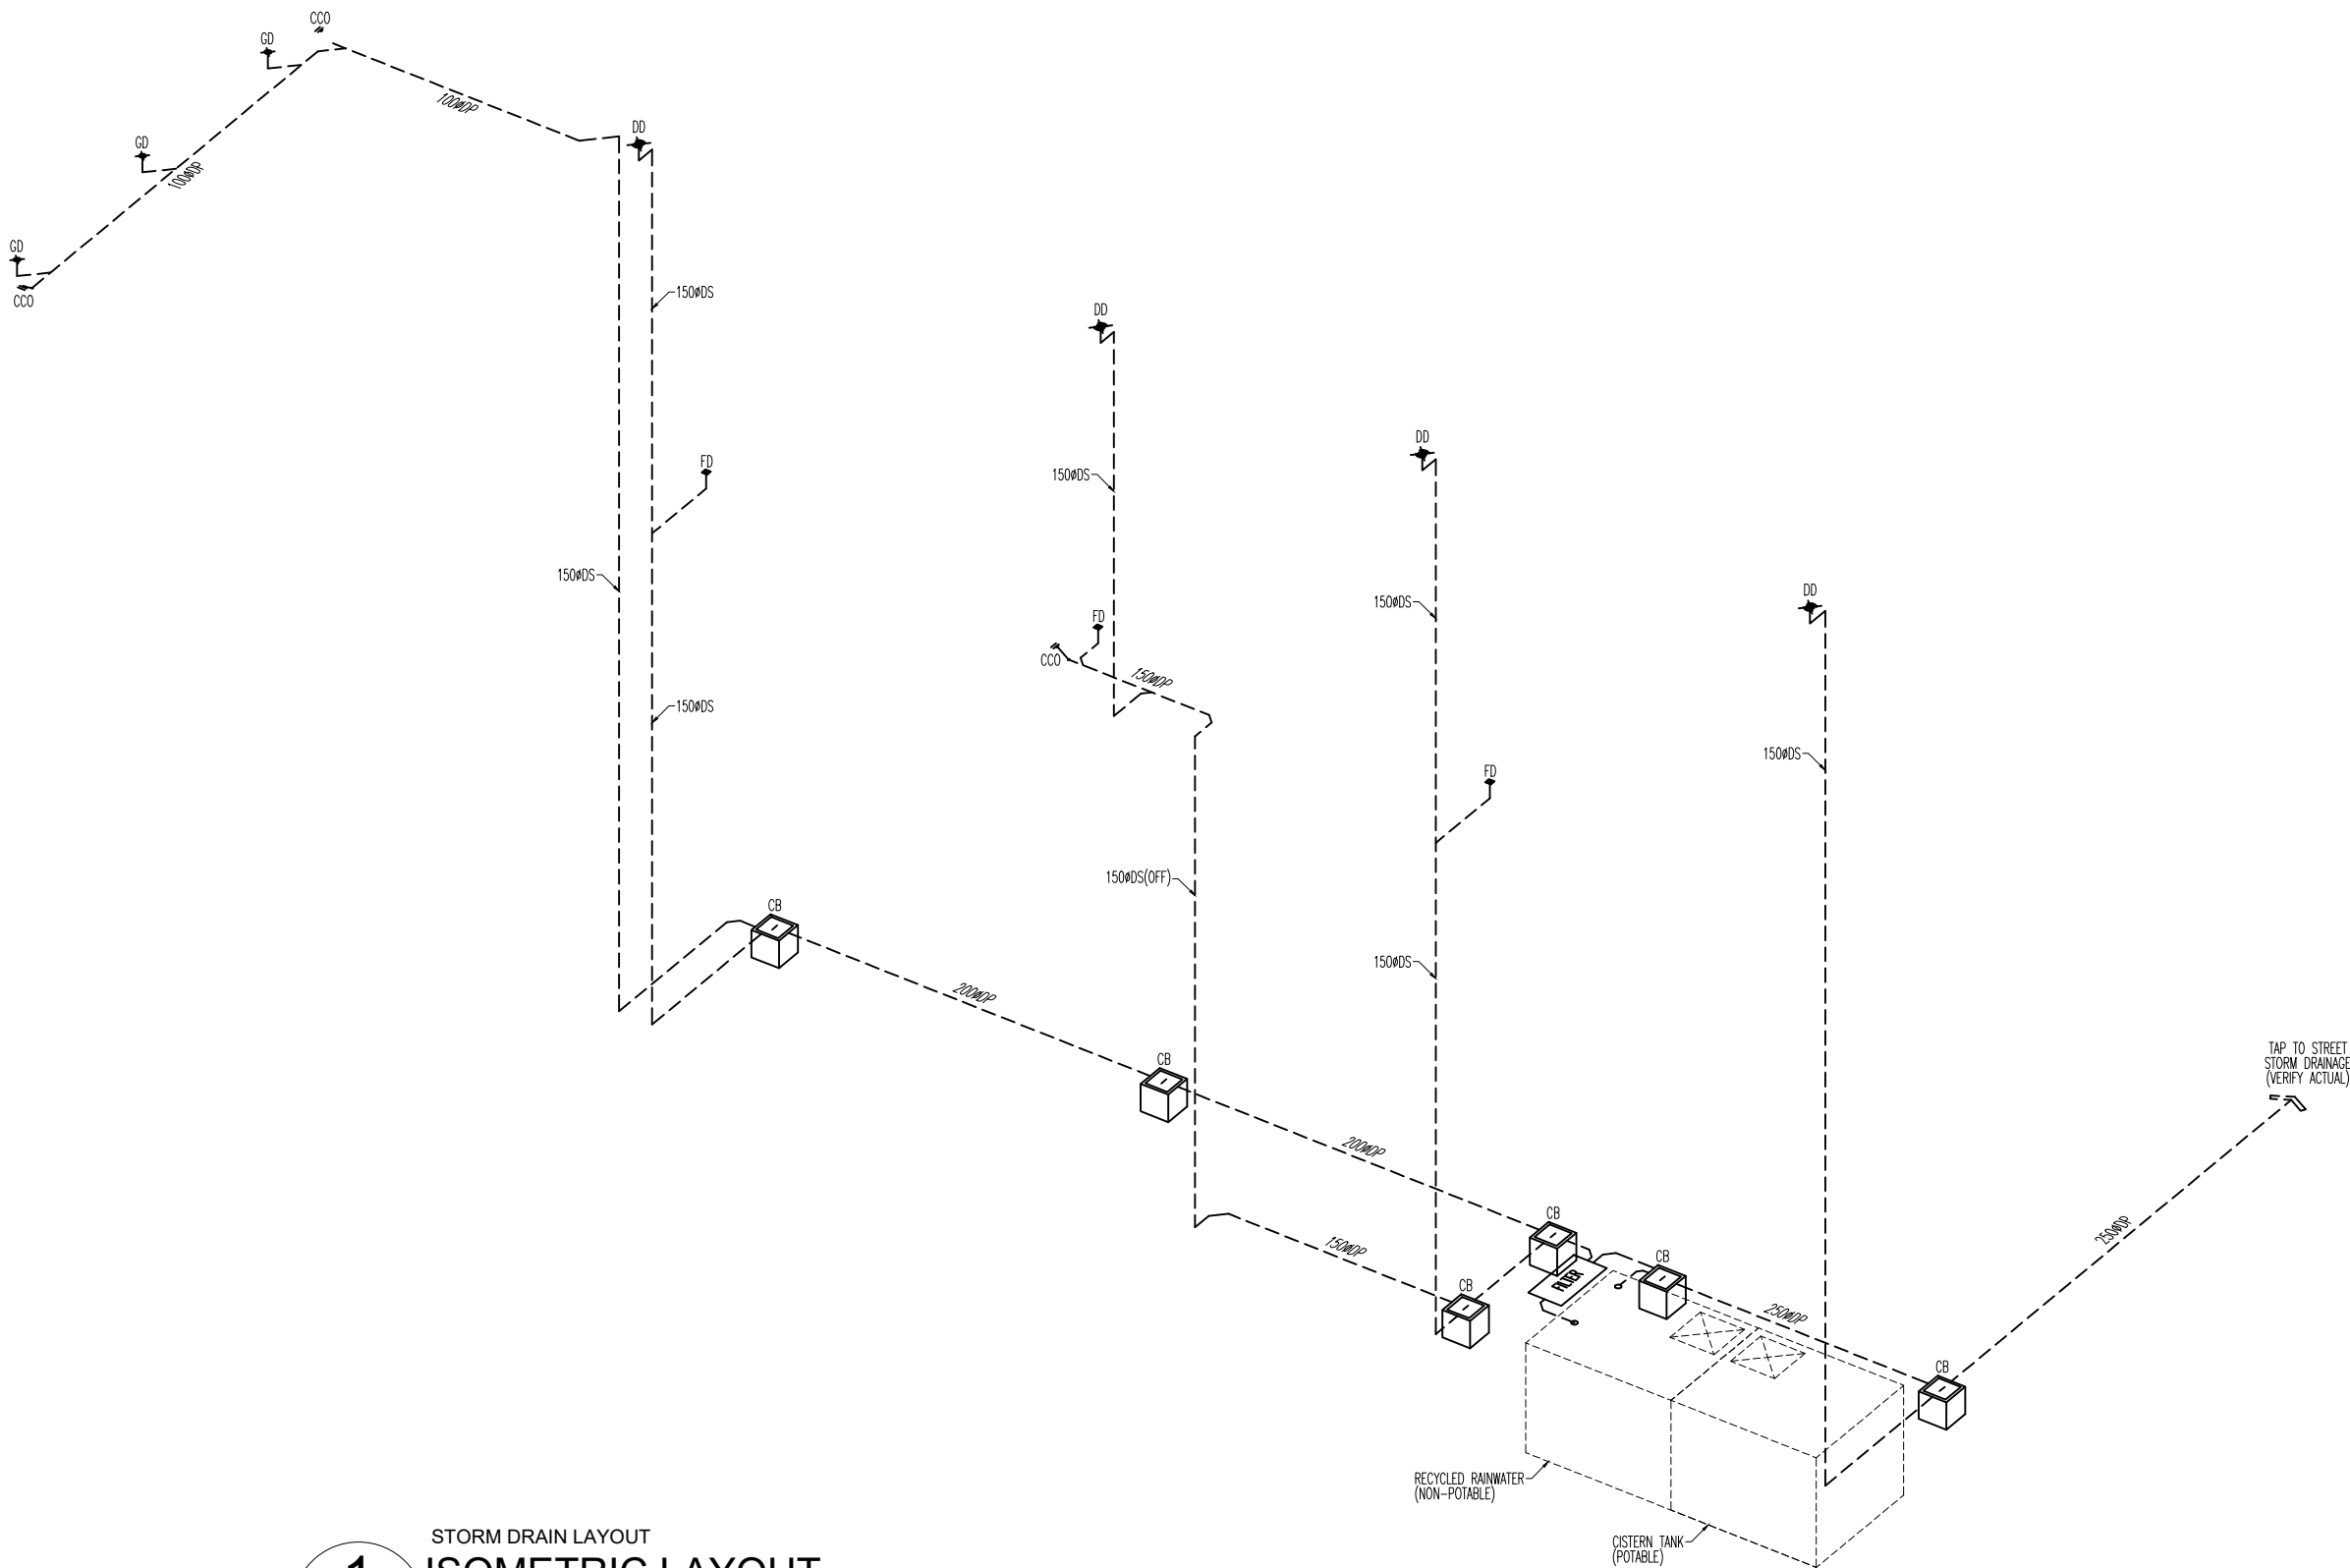

STORM DRAIN LAYOUT
1
P 13 SCALE NTS
ISOMETRIC LAYOUT