




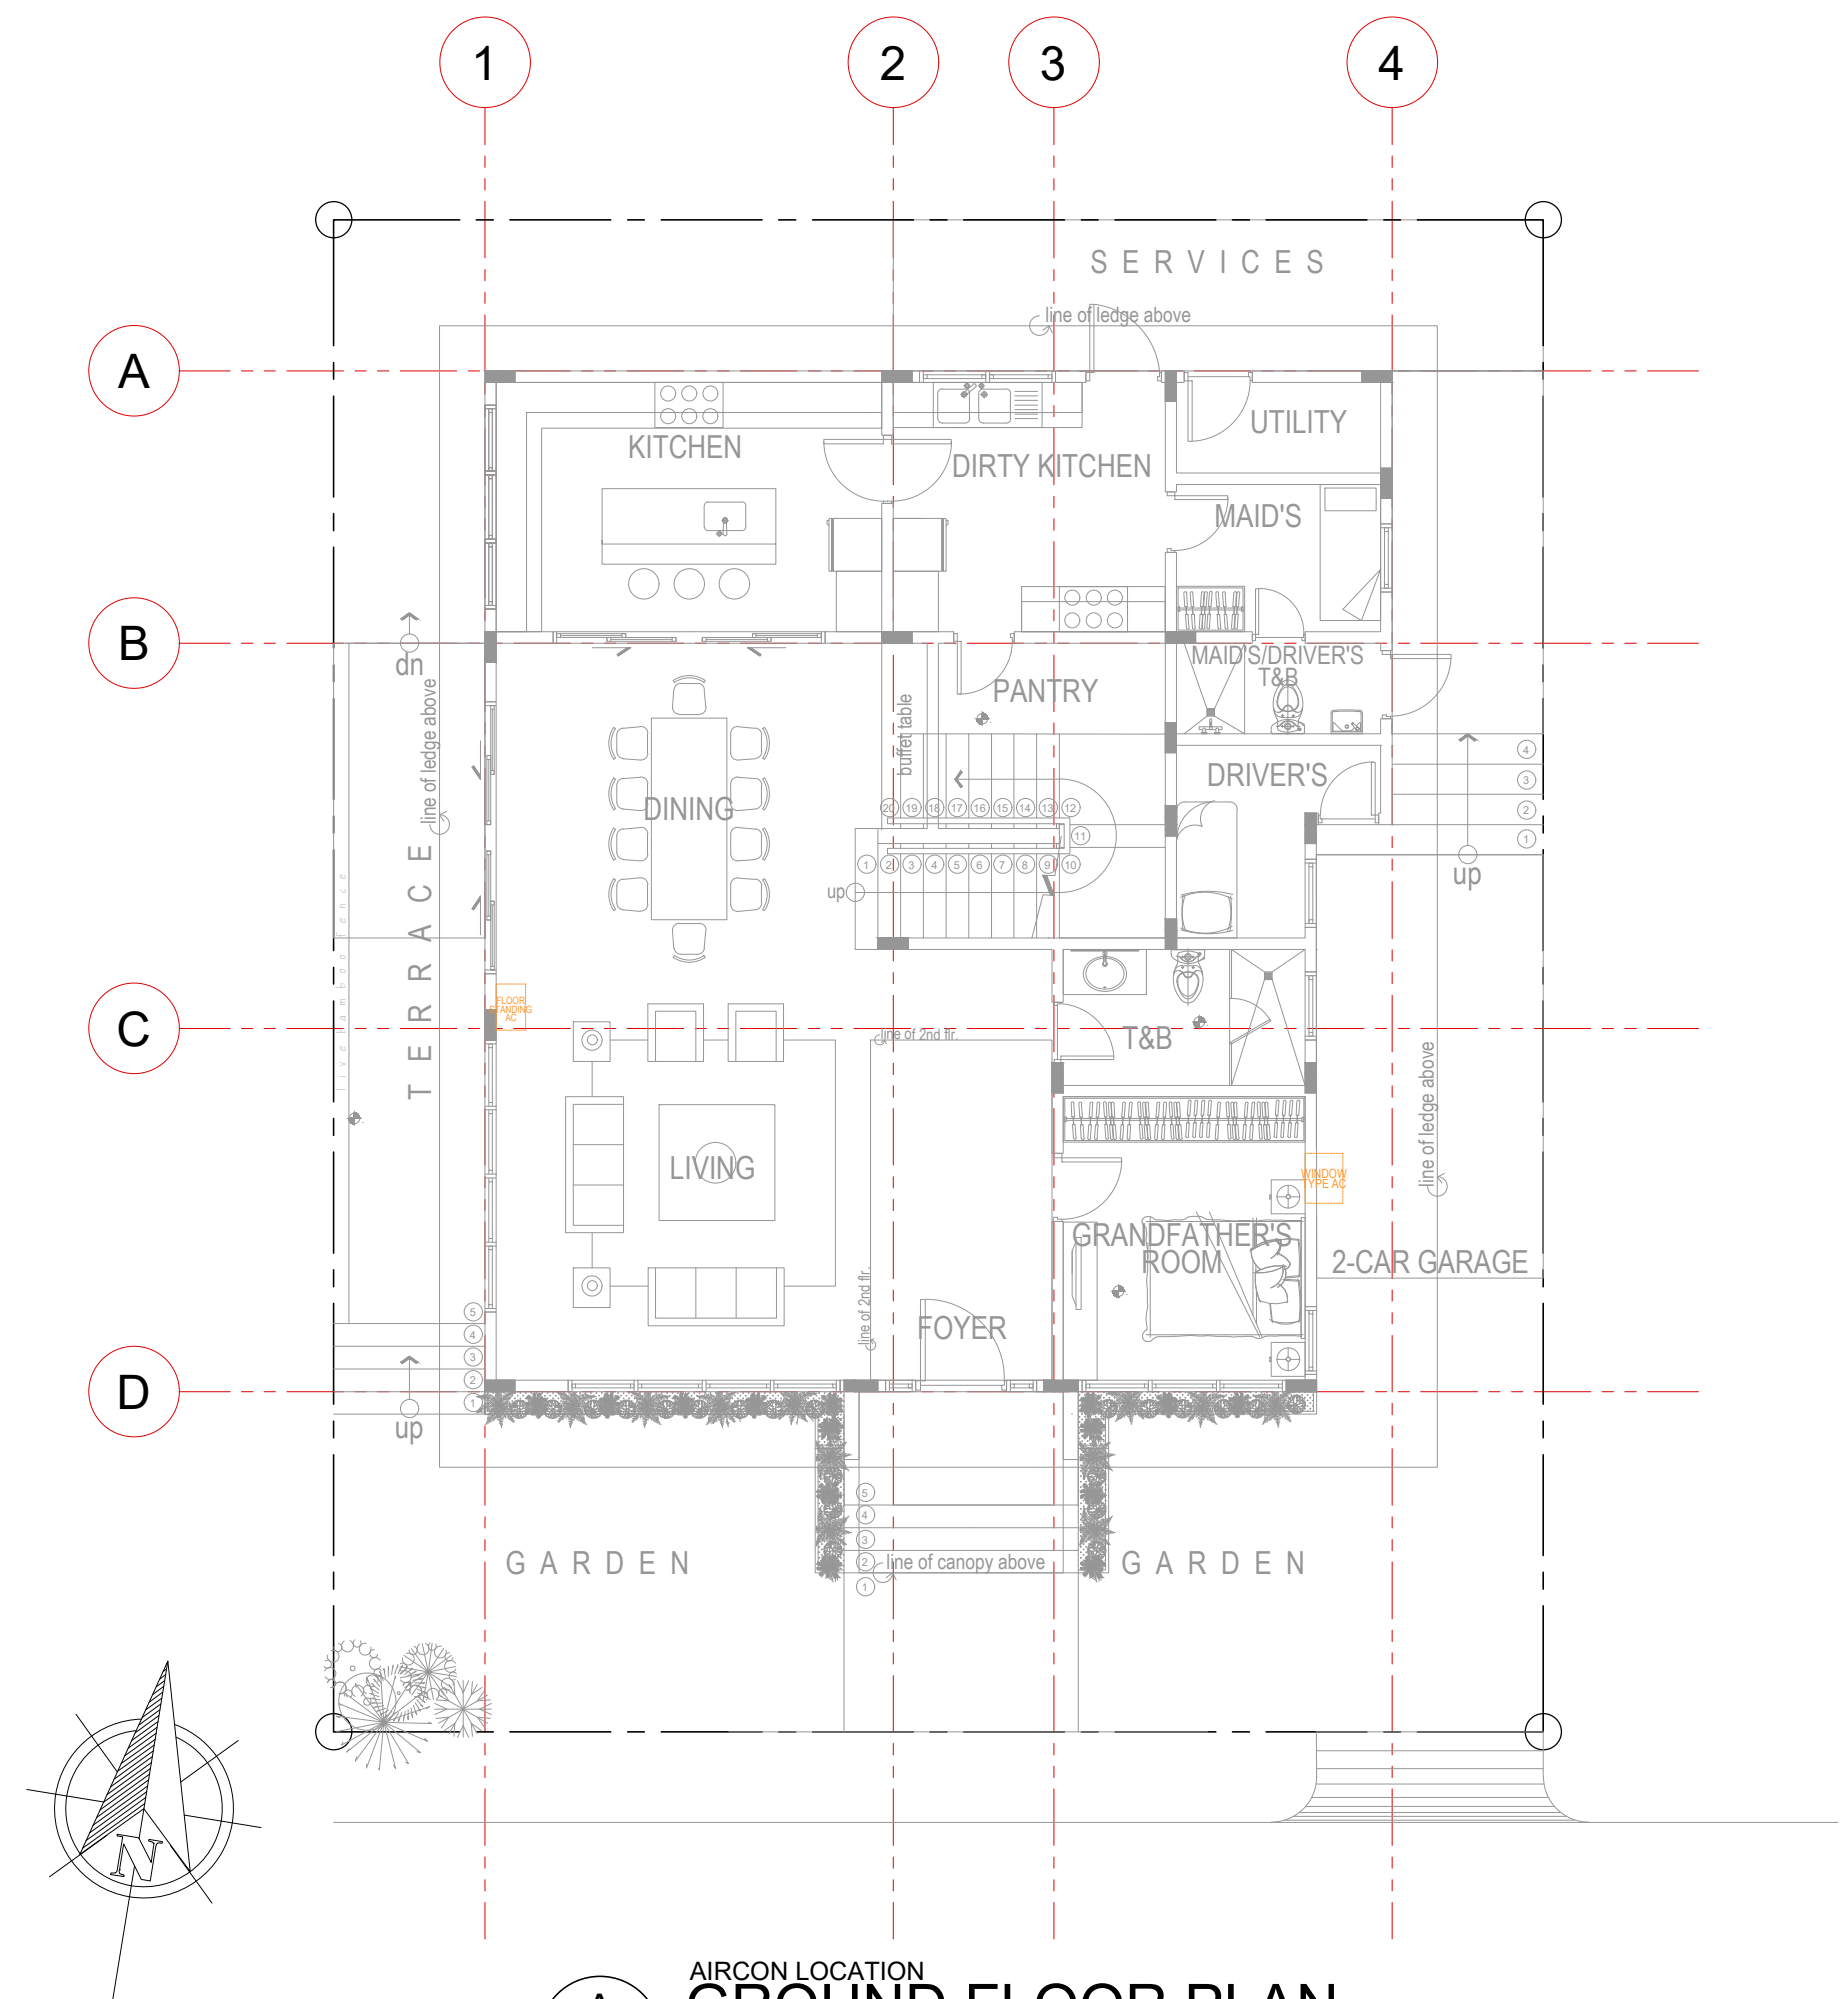


AIRCON LOCATION
A
A-20
SCALE 1:100
GROUND FLOOR PLAN

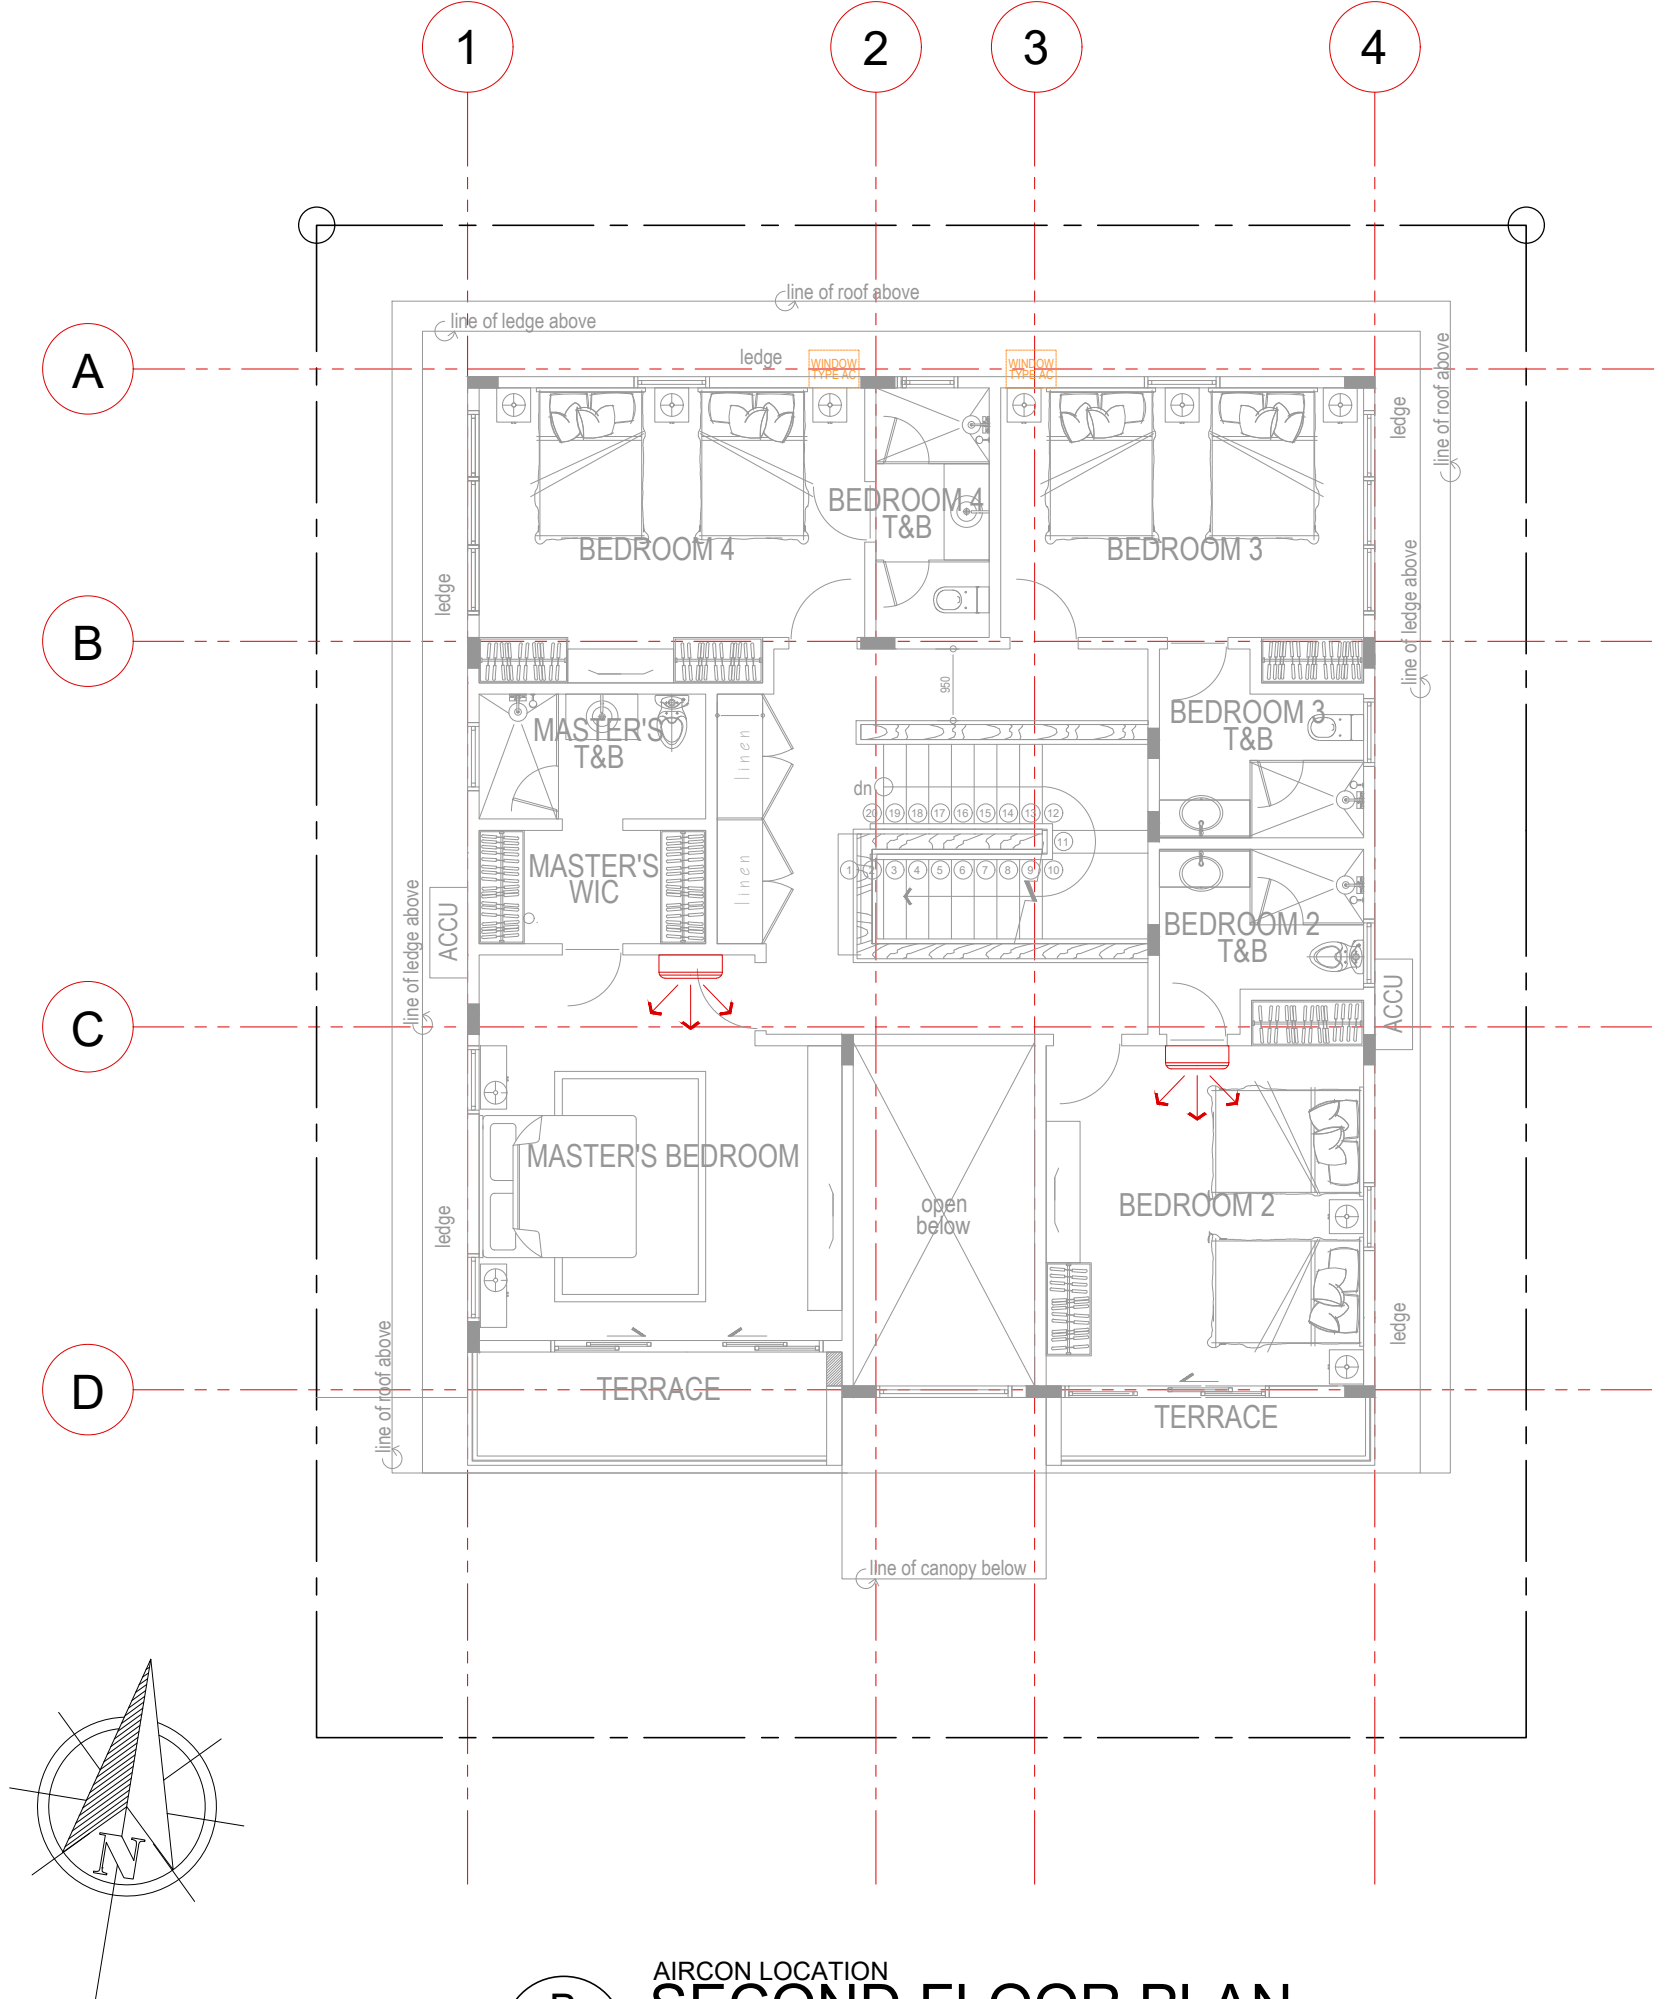


AIRCON LOCATION
B
A-20
SCALE 1:100
SECOND FLOOR PLAN

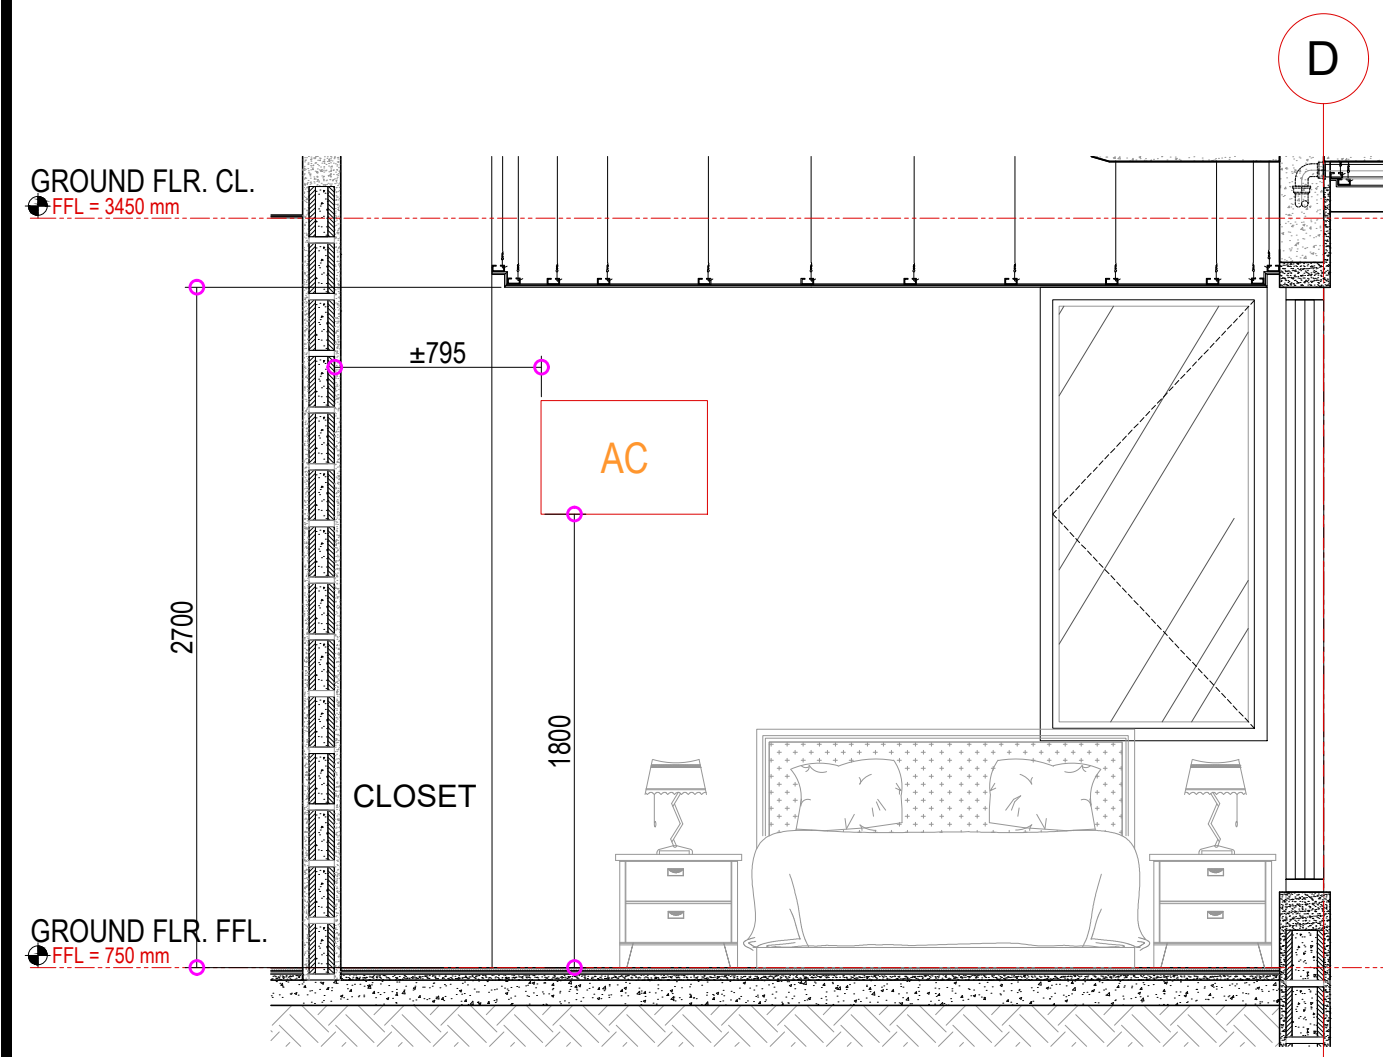

C
A-20
SCALE 1:30
GRANDFATHER'S ROOM BLOW-UP SECTION

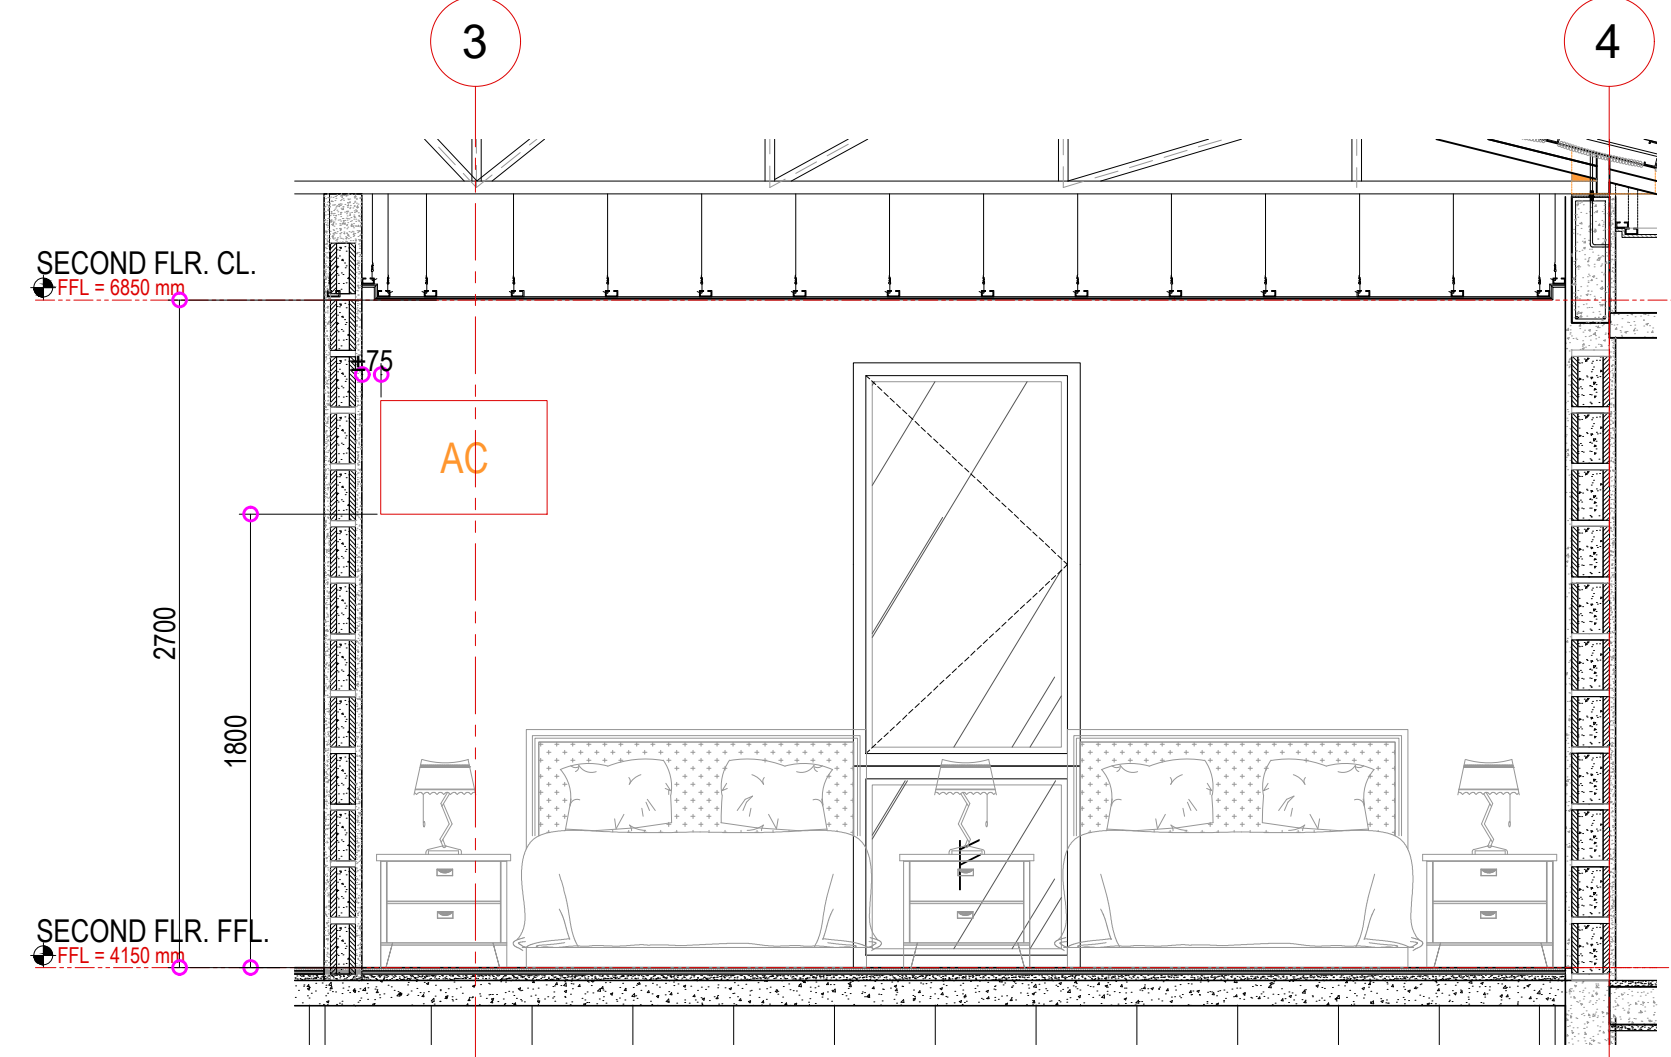

D
A-20
SCALE 1:30
BEDROOM 3 BLOW-UP SECTION

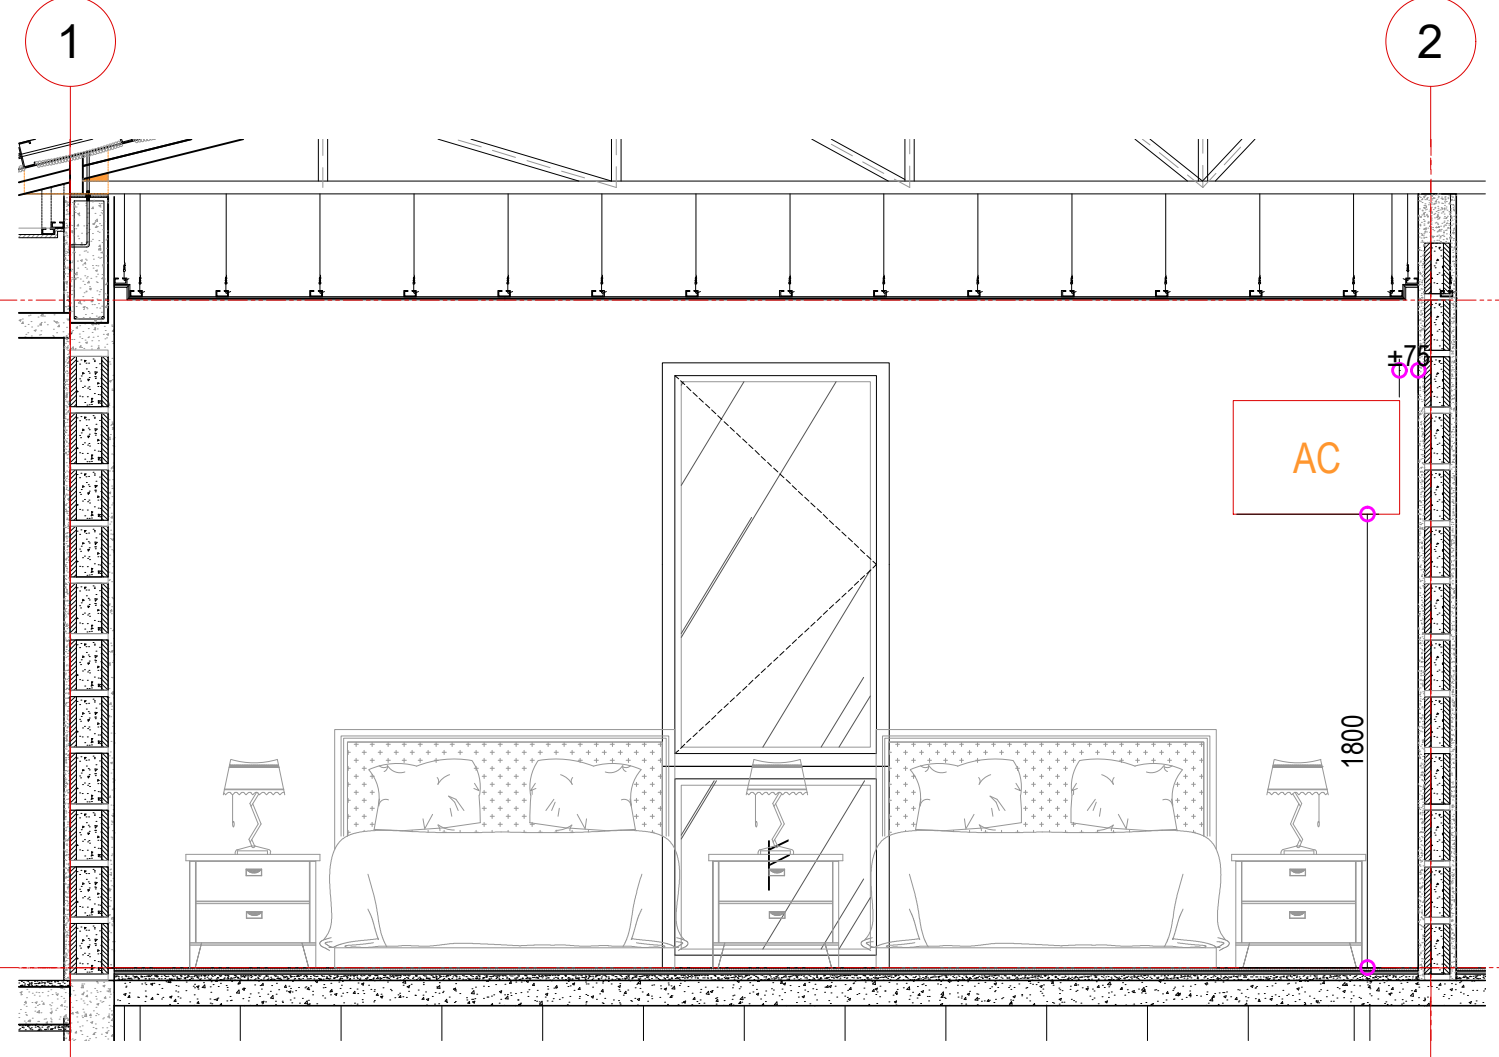

E
A-00
SCALE 1:30
BEDROOM 4 BLOW-UP SECTION

This drawings shall be coordinated with Structural, Electrical, Mechanical, Sanitary & Fire Protection plans.
Refer to Architects and Structural Engineers drawings for building details.
Dimensions to be checked on site before any work is put in hand or prefabricated.
This drawing is to be read in conjunction with the technical specification and sub-contractors working drawings.

REVISIONS		
REV. NO.	REASONS FOR REVISION	DATE

PROJECT:
PROPOSED TWO-STOREY RESIDENCE
COTSWOLD, TAGAYTAY

OWNER:
MR. GALO LEONARDO YOUNG LIM JR.

ARCHITECT:
W.V.Coscolluela & ASSOCIATES
ARCHITECTS, ENGINEERS, PLANNERS

STRUCTURAL:
RCVillareal Design and Management
3817 Kadena St. 1001 St. Cruz, Manila
Tel No. 895-8992 Fax No. 743-0137 email: rcdm@rcvillareal.com

ELECTRICAL:
PA CASTILLO ELECTRICAL, INC.
ENGINEERS CONTRACTORS CORP. (R.A. 7920)
1711 GENOVA BUILDING, SPANCO TERRACE CONDOMINIUM, CHAMPAGNE ST. JAYRO D.C.

PLUMBING AND DRAINAGE:
apcc APEUGENIO
engineering consultancy
51-C VAMANSALA ST. F. AMOROSO L.P. DELMAN D.C.
Tel # 434-5803 E-mail: apec@apeugenio.com

MECHANICAL:
apcc APEUGENIO
engineering consultancy
51-C VAMANSALA ST. F. AMOROSO L.P. DELMAN D.C.
Tel # 434-5803 E-mail: apec@apeugenio.com

FIRE PROTECTION ENGINEERING:

QUANTITY SURVEYOR:

CONSTRUCTION MANAGER:

ISSUED BY:
WILLIAM V. COSCOLLUELA

107 Perea St., Legaspi Village Makati City, Philippines 1200
Tel # 894-5803, 894-5804 Fax: 894-0635 wvca@info.com.ph
PRC REG. NO. 00967 PLACE ISSUED: MAKATI CITY
PTR. NO. 10079455 DATE ISSUED: JAN. 12, 2024
TIN. NO. 105-348-783
DOCUMENT TYPE:

DRAWING TITLE:

AIRCON LOCATION
BEDROOM BLOW-UP SECTION

SCALE:	CHECKED:
DESIGN/DRAWN:	APPROVED:
CAD FILE:	ISSUE DATE:
PROJECT No:	REV:
SHEET No:	