


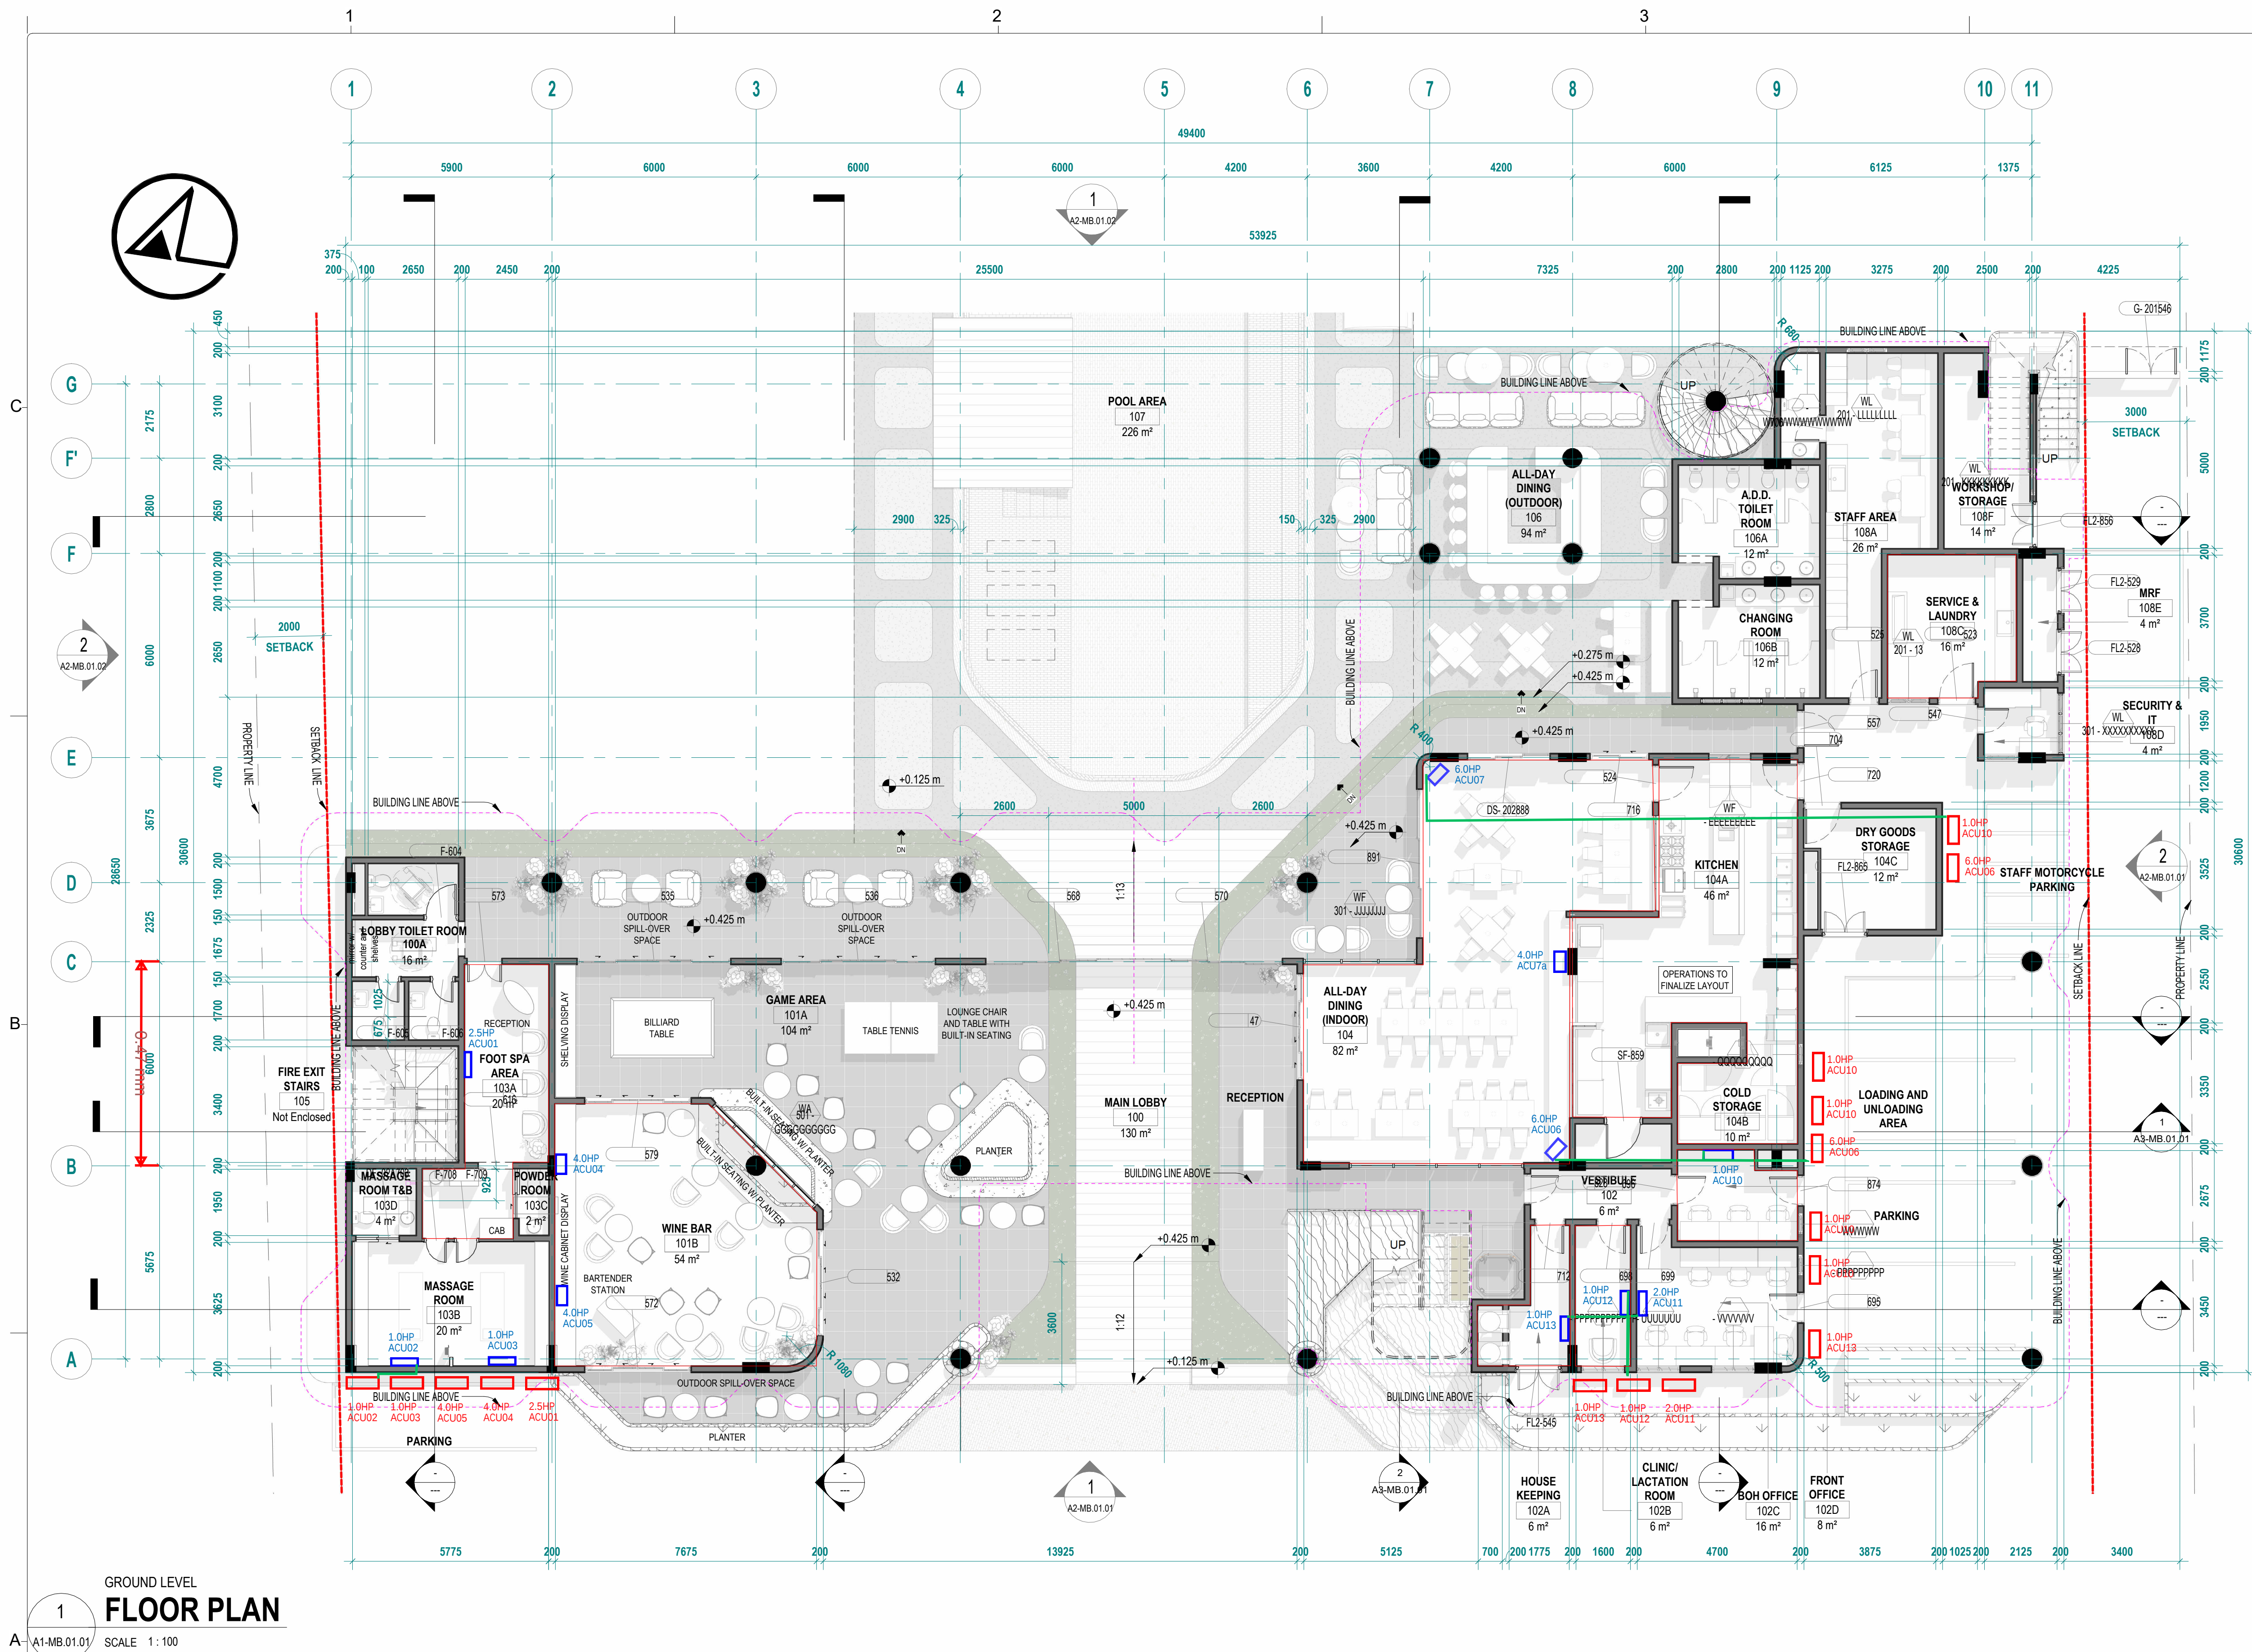

DRAWING LEGEND		
ROOM SCHEDULE - GROUND FLOOR		
Number	ROOMS	AREA
GROUND FLOOR LEVEL		
100	MAIN LOBBY	130 m²
100A	LOBBY TOILET ROOM	16 m²
101A	GAME AREA	104 m²
101B	WINE BAR	54 m²
102	VESTIBULE	6 m²
102A	HOUSE KEEPING	6 m²
102B	CLINIC/LACTATION ROOM	6 m²
102C	BOH OFFICE	16 m²
102D	FRONT OFFICE	8 m²
103A	FOOT SPA AREA	20 m²
103B	MASSAGE ROOM	20 m²
103C	POWDER ROOM	2 m²
103D	MASSAGE ROOM T&B	4 m²
104	ALL-DAY DINING (INDOOR)	82 m²
104A	KITCHEN	46 m²
104B	COLD STORAGE	10 m²
104C	DRY GOODS STORAGE	12 m²
105	FIRE EXIT STAIRS	0 m²
106	ALL-DAY DINING (OUTDOOR)	94 m²
106A	A.D.D. TOILET ROOM	12 m²
106B	CHANGING ROOM	12 m²
107	POOL AREA	226 m²
107A	OUTDOOR SHOWER/FOOTWASH	4 m²
107B	OUTDOOR SHOWER/FOOTWASH	4 m²
108A	STAFF AREA	26 m²
108C	SERVICE & LAUNDRY	16 m²
108D	SECURITY & IT	4 m²
108E	MRF	4 m²
108F	WORKSHOP/STORAGE	14 m²
Grand total: 29		962 m²

GROUND LEVEL
1 FLOOR PLAN
A1-MB.01.01 SCALE 1:100

THE GREENHOUSE:
PROPOSED
3-STOREY HOTEL
BUILDING

DESIGN DEVELOPMENT
NOT FOR CONSTRUCTION

FLOOR PLANS

MR. FREDERICK T. SIY
TOURISM RD., BRGY. CATANGMAN,
GEN. LUNA, SURIGAO DEL NORTE

DESIGNED BY: DDC
DATE ISSUED: 17-MAR-20
DATE PRINTED: 21 Nov 2024 11:49:11 AM

SHEET NO:
A1-MB.01.01
SCALE: 1:100

ISSUED BY:
AR. DENISE DE CASTRO

TIN NO.:
ISSUED:
REG NO.:
PTR NO.:
IAPOA NO.:

DRAWINGS AND SPECIFICATIONS DULY SIGNED, STAMPED OR SEALED, AS INSTRUMENTS OF SERVICE, ARE THE INTELLECTUAL PROPERTIES AND DOCUMENTS OF THE ARCHITECT. WHETHER THE OBJECT FOR WHICH THEY ARE MADE IS EXECUTED OR NOT, IT SHALL BE UNLAWFUL FOR ANY PERSON, WITHOUT THE CONSENT OF THE ARCHITECT TO DUPLICATE OR TO MAKE COPIES OF SAID DOCUMENTS FOR USE IN THE REPRODUCTION OF OTHER PROJECTS OR BUILDINGS, WHETHER EXECUTED PARTLY OR IN WHOLE.

FASTCON
STRUCTURAL/CIVIL WORKS

FASTCON
ELECTRICAL

FASTCON
ELECTRONICS

FASTCON
MECHANICAL AND FIRE PROTECTION

FASTCON
PLUMBING AND SANITARY


FASTCON
LANDSCAPE

KEY PLAN

DRAWING REVISIONS

NO.	DATE	BY	DESCRIPTION

1:100

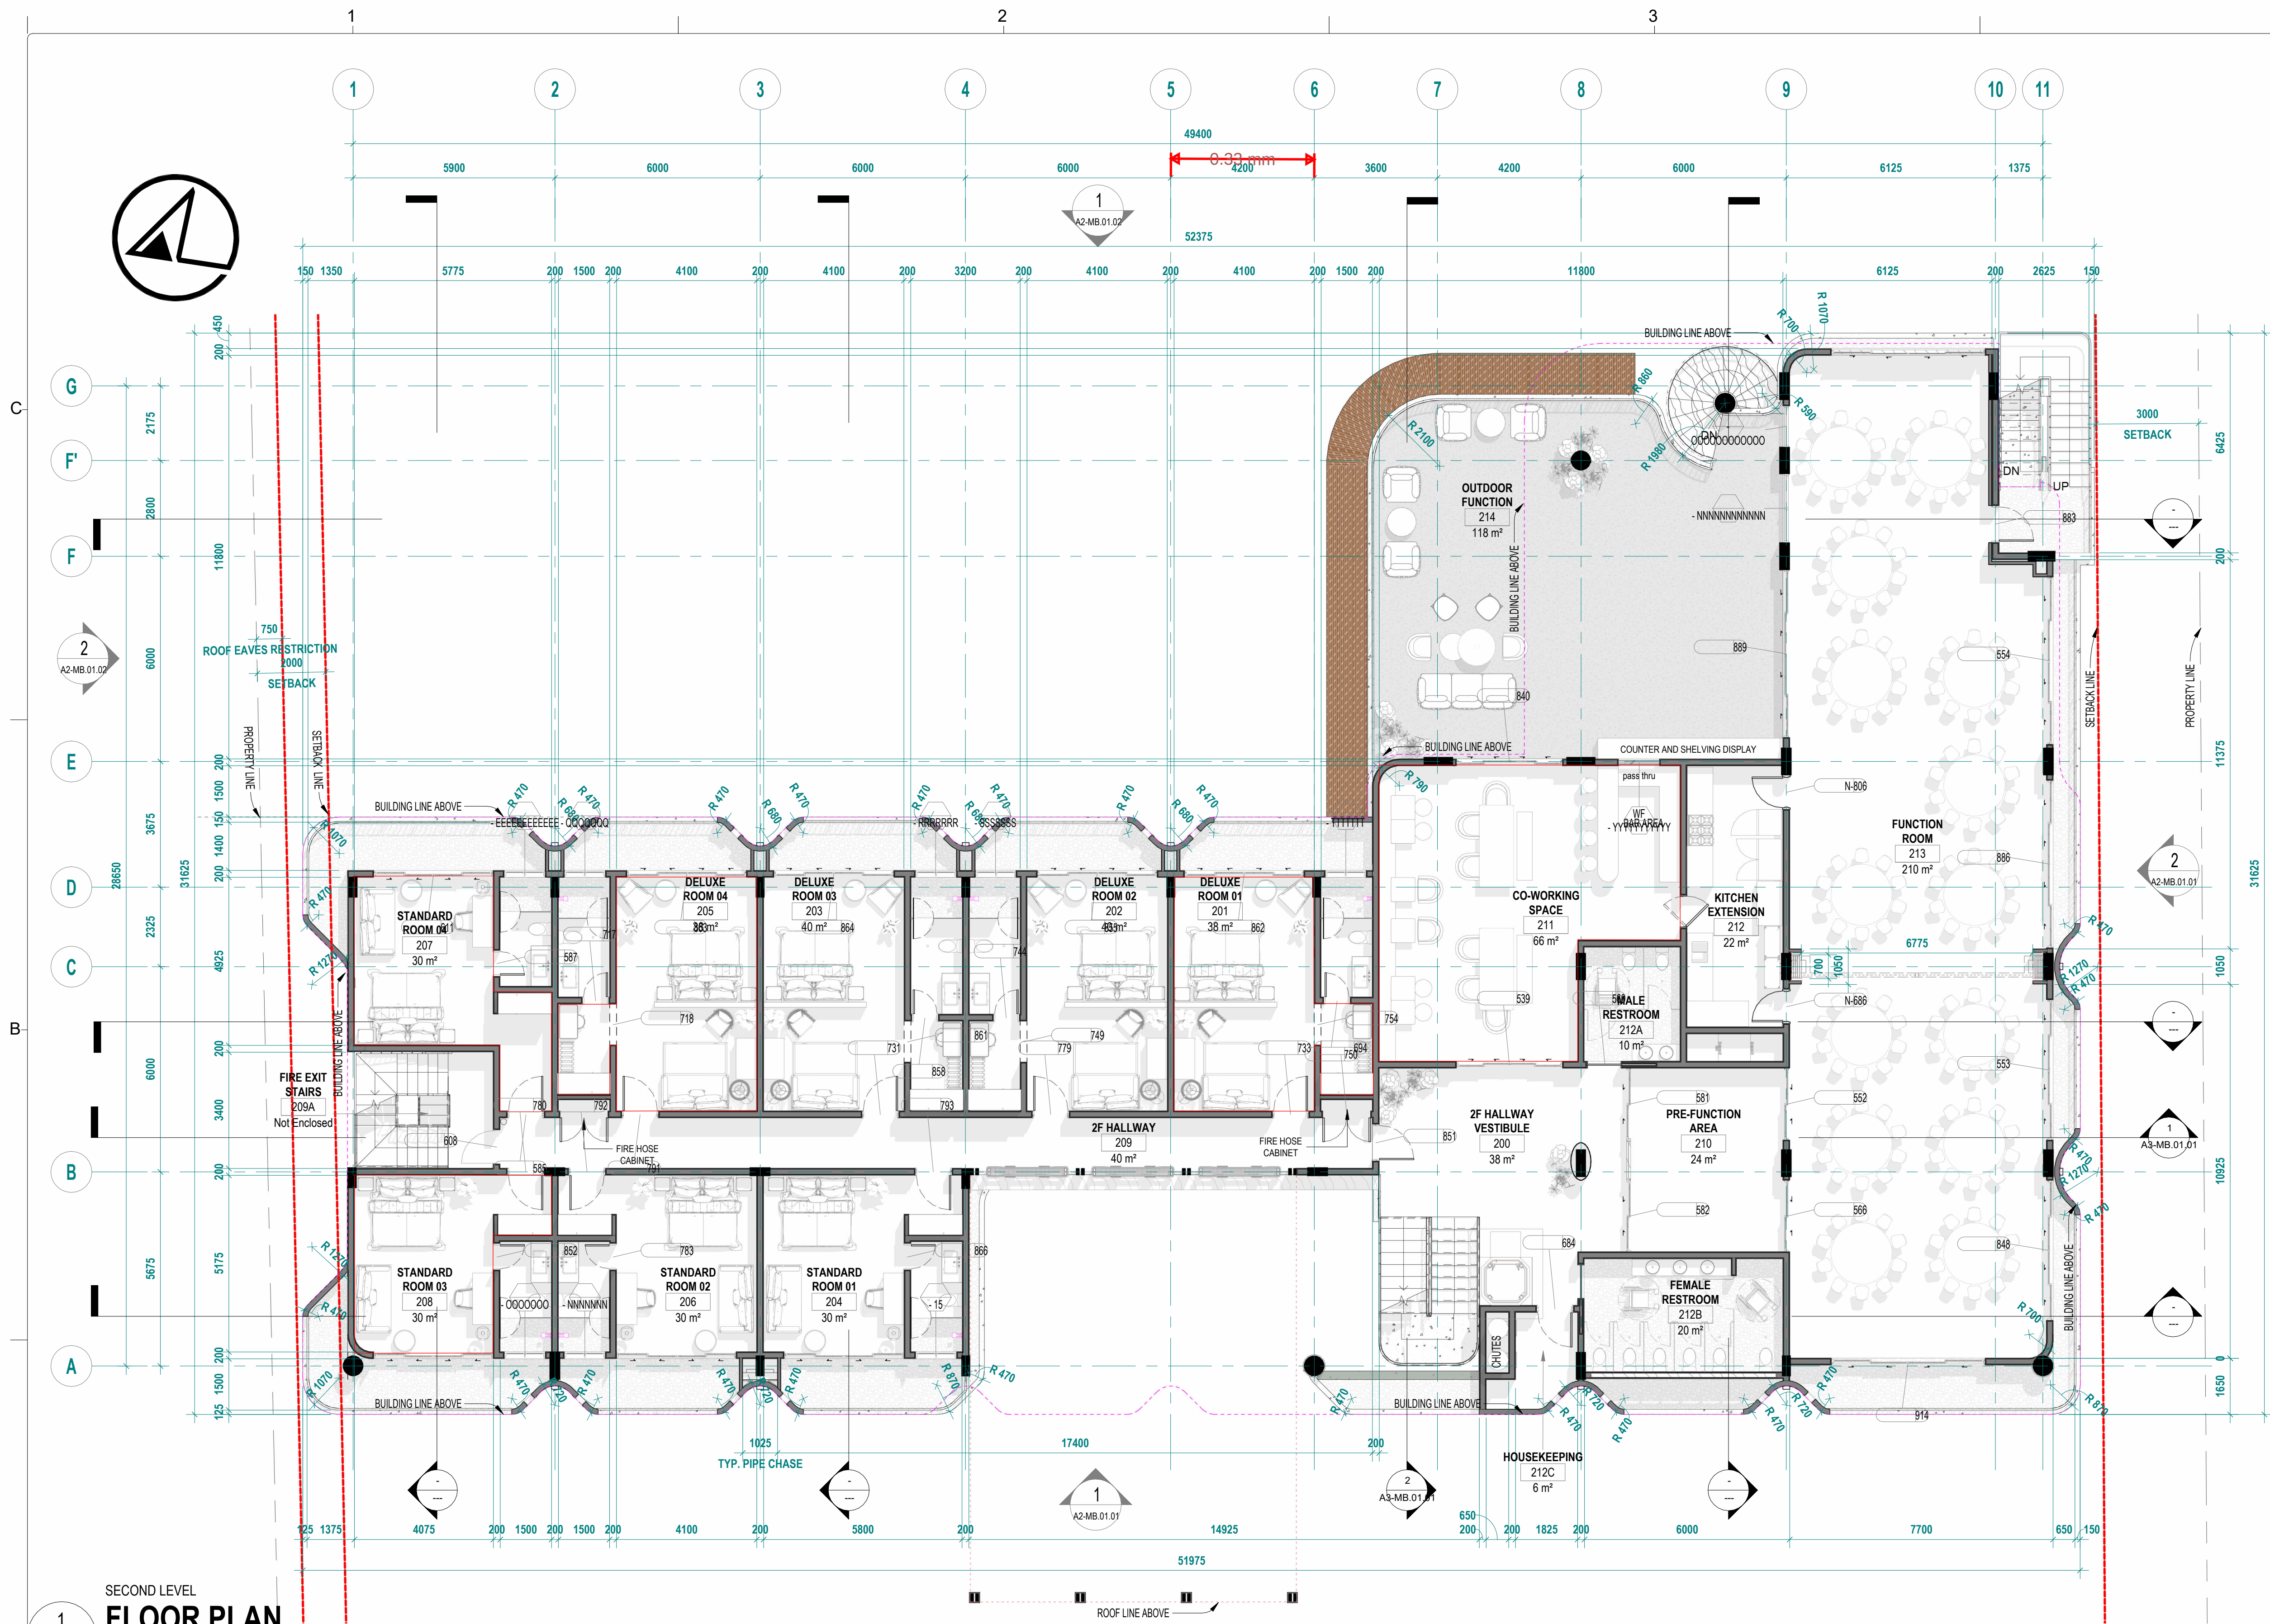

DRAWING LEGEND		
ROOM SCHEDULE - SECOND FLOOR		
Number	ROOMS	AREA
2ND FLOOR LEVEL		
201	DELUXE ROOM 01	38 m²
202	DELUXE ROOM 02	40 m²
203	DELUXE ROOM 03	40 m²
204	STANDARD ROOM 01	30 m²
205	DELUXE ROOM 04	38 m²
206	STANDARD ROOM 02	30 m²
207	STANDARD ROOM 04	30 m²
208	STANDARD ROOM 03	30 m²
209	2F HALLWAY	40 m²
209A	FIRE EXIT STAIRS	0 m²
210	PRE-FUNCTION AREA	24 m²
211	CO-WORKING SPACE	66 m²
212	KITCHEN EXTENSION	22 m²
212A	MALE RESTROOM	10 m²
212B	FEMALE RESTROOM	20 m²
212C	HOUSEKEEPING	6 m²
213	FUNCTION ROOM	210 m²
214	OUTDOOR FUNCTION	118 m²
Grand total: 18		786 m²


SECOND LEVEL
1 FLOOR PLAN
A1-MB.01.02 SCALE 1:100

THE GREENHOUSE: PROPOSED 3-STOREY HOTEL BUILDING	FLOOR PLANS	ISSUED BY: AR. DENISE DE CASTRO	DEQA DESIGN COLLABORATIVE	FASTCON STRUCTURAL/CIVIL WORKS	FASTCON MECHANICAL AND FIRE PROTECTION	FASTCON ELECTRICAL	FASTCON PLUMBING AND SANITARY	FASTCON ELECTRONICS	FASTCON LANDSCAPE	KEY PLAN	DRAWING REVISIONS
DESIGN DEVELOPMENT NOT FOR CONSTRUCTION	MR. FREDERICK T. SIY TOURISM RD., BRGY. CATANGMAN, GEN. LUNA, SURIGAO DEL NORTE	TIN.NO.: ISSUED: REG.NO.: PTR.NO.: IAPOA.NO.:	DRAWINGS AND SPECIFICATIONS DULY SIGNED, STAMPED OR SEALED, AS INSTRUMENTS OF SERVICE, ARE THE INTELLECTUAL PROPERTIES AND DOCUMENTS OF THE ARCHITECT. WHETHER THE OBJECT FOR WHICH THEY ARE MADE IS EXECUTED OR NOT, IT SHALL BE UNLAWFUL FOR ANY PERSON, WITHOUT THE CONSENT OF THE ARCHITECT TO DUPLICATE OR TO MAKE COPIES OF SAID DOCUMENTS FOR USE IN THE REPRODUCTION OF OTHER PROJECTS OR BUILDINGS, WHETHER EXECUTED PARTLY OR IN WHOLE.								
DESIGNED BY: DDC DATE ISSUED: 17-MAR-20 DATE PRINTED: 21 Nov 2024 11:49:38 AM	SHEET NO: A1-MB.01.02 SCALE: 1:100										



DRAWING REVISIONS

1:100

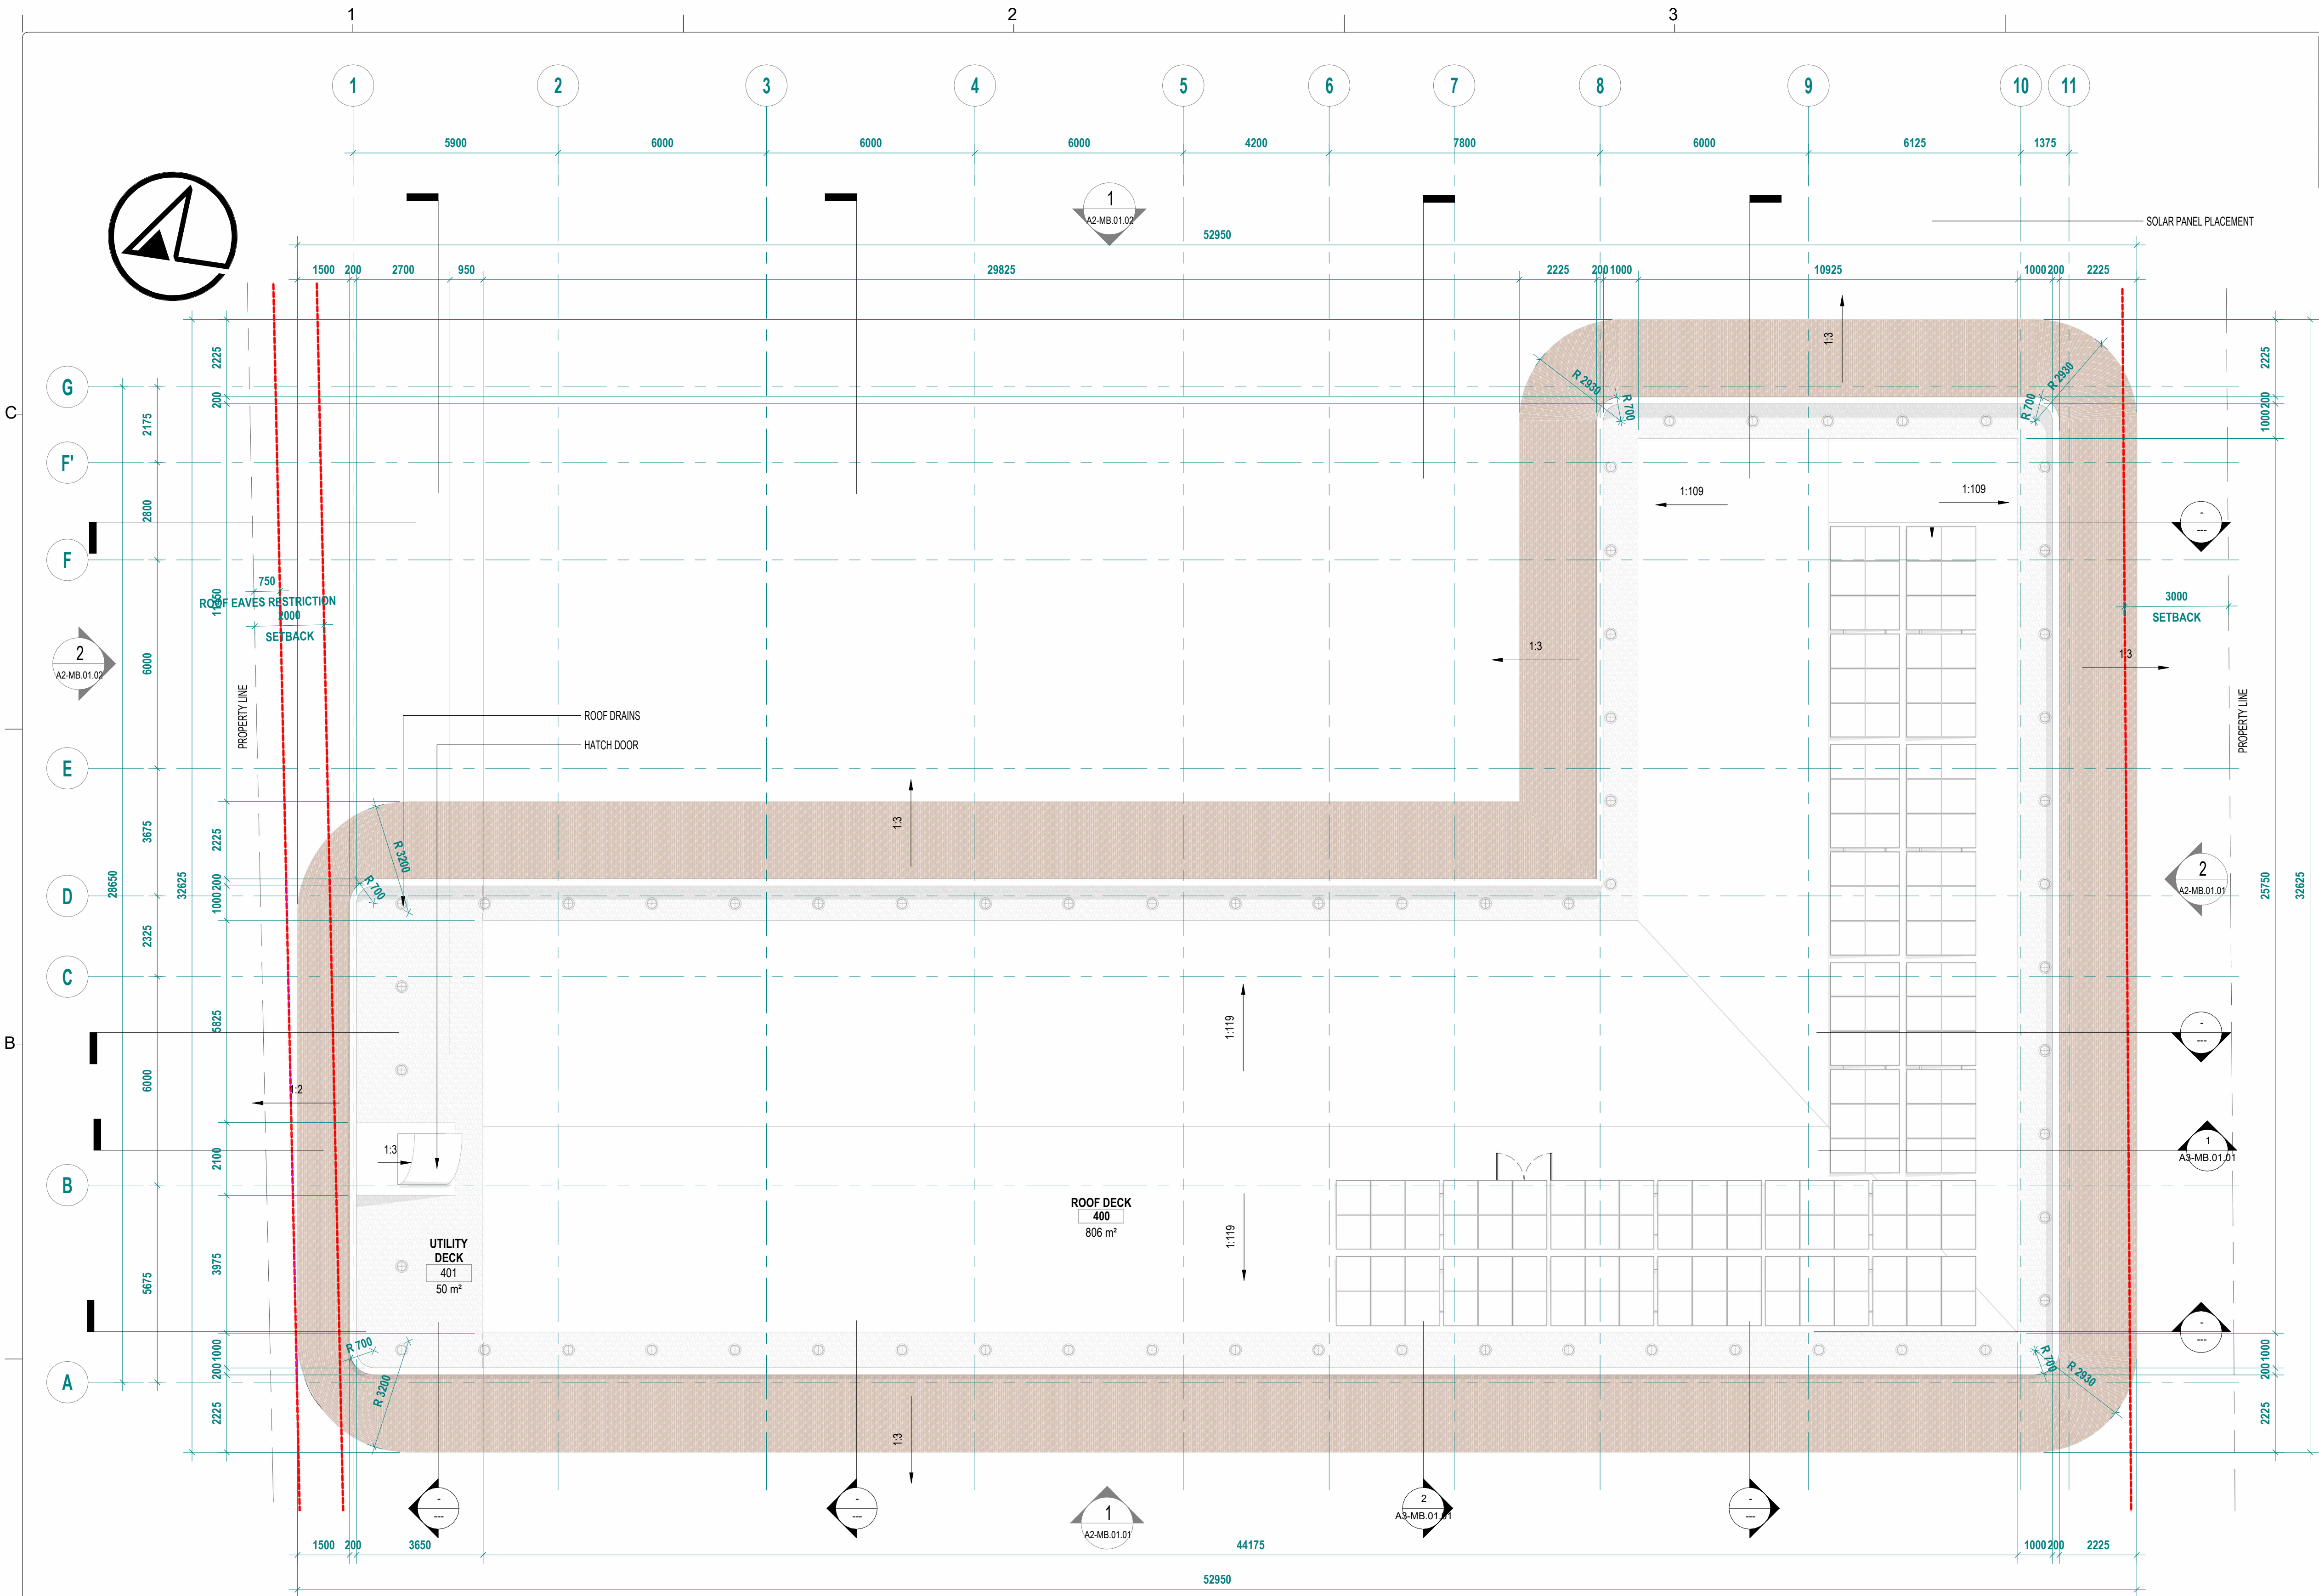

DRAWING LEGEND		
ROOM SCHEDULE - ROOF DECK		
Number	ROOMS	AREA
TOP OF ROOF BEAM		
400	ROOF DECK	806 m²
401	UTILITY DECK	50 m²
Grand total: 2		856 m²

ROOF LEVEL
1
FLOOR PLAN
A1-MB.01.04 SCALE 1:100

THE GREENHOUSE: PROPOSED 3-STOREY HOTEL BUILDING	FLOOR PLANS		ISSUED BY: AR. DENISE DE CASTRO		DRAWINGS AND SPECIFICATIONS DULY SIGNED, STAMPED OR SEALED, AS INSTRUMENTS OF SERVICE, ARE THE INTELLECTUAL PROPERTIES AND DOCUMENTS OF THE ARCHITECT. WHETHER THE OBJECT FOR WHICH THEY ARE MADE IS EXECUTED OR NOT, IT SHALL BE UNLAWFUL FOR ANY PERSON, WITHOUT THE CONSENT OF THE ARCHITECT TO DUPLICATE OR TO MAKE COPIES OF SAID DOCUMENTS FOR USE IN THE REPRODUCTION OF OTHER PROJECTS OR BUILDINGS, WHETHER EXECUTED PARTLY OR IN WHOLE. REPUBLIC ACT 696		DRAWING REVISIONS				
	MR. FREDERICK T. SIY						NO. DATE BY DESCRIPTION				
	TOURISM RD., BRGY. CATANGNAN, GEN. LUNA, SURIGAO DEL NORTE										
DESIGN DEVELOPMENT NOT FOR CONSTRUCTION	DESIGNED BY: DDC	SHEET NO: A1-MB.01.04	REG. NO.: *****								
	DATE ISSUED: 17-MAR-2024		PTR. NO.: *****								
	DATE PRINTED: 21 Nov 2024 11:50:24 AM	SCALE: 1:100	IAPON NO.: *****								
											1:100