




SHEET LEGEND	
LIGHTING FIXTURE	
SYMBOL	DESCRIPTION
RECESSED LIGHTING	
DL1	LED RECESSED DOWN LIGHT 10W-36 DEG-IP54 WARM WHITE 3500K
SURFACE MOUNTED LIGHTING	
DL2	LED SURFACE MOUNTED 14W-FROSTED-IP56 WARM WHITE 3500K
DL3	LED SURFACE MOUNTED CANNED 14W-FROSTED-IP56 WARM WHITE 3500K
DL4	LED SURFACE MOUNTED DUAL DIRECTIONAL LIGHTS 10W-36 DEG-IP4 WARM WHITE 3500K
DL5	LED SURFACE MOUNTED DIRECTIONAL LIGHTS 10W-36 DEG-IP4 WARM WHITE 3500K
DL6	600 X 1200MM LED PANEL CEILING LIGHT
PENDANT/SUSPENDED LIGHTING	
PL1	DECORATIVE PENDANT LIGHTING 3500K (REFER TO ID FOR SPECIFICATIONS)
PL2	DECORATIVE PENDANT LIGHTING 3500K (REFER TO ID FOR SPECIFICATIONS)
PL3	DECORATIVE PENDANT LIGHTING 3500K (REFER TO ID FOR SPECIFICATIONS)
PL4	DECORATIVE PENDANT LIGHTING 3500K (REFER TO ID FOR SPECIFICATIONS)
PL5	DECORATIVE PENDANT LIGHTING (REFER TO ID FOR SPECIFICATIONS)
WALL LAMPS	
WL1	DECORATIVE WALL LAMPS 5W-IP65 WARM WHITE 3500K (REFER TO ID FOR SPECIFICATIONS)
WL2	LED DECORATIVE WALL LAMPS 5W-IP65 WARM WHITE 3500K (REFER TO ID FOR SPECIFICATIONS)
WL3	DECORATIVE WALL LAMPS 5W-IP65 WARM WHITE 3500K (REFER TO ID FOR SPECIFICATIONS)
WL4	WALL MOUNTED POOL LIGHTING
WL5	BED-SIDE WALL MOUNTED LAMP
WL6	VANITY TABLE WALL MOUNTED LAMP
WL7	PREMIUM ROOM WALL MOUNTED LAMP
INDIRECT LIGHTING	
IL1	LED NEON STRIPS 5W-IP65 WARM WHITE 3500K
EXTERIOR CEILING FINISHES	
TAG	DESCRIPTION
CF-AR-01A	10MM THK MOISTURE & MOLD RESISTANT GYPSUM BOARD FINISHED IN WHEAT VENETIAN PLASTER SURFACE APPLIED FINISH IN WHEAT VENETIAN PLASTER
CF-AR-01B	10MM THK FIBER CEMENT BOARD FINISHED IN WHEAT VENETIAN PLASTER SURFACE APPLIED FINISH IN WHEAT VENETIAN PLASTER
CF-AR-02	RUNO BAMBOO
CF-AR-03	WOOD STAIN FINISH
INTERIOR CEILING FINISHES	
TAG	DESCRIPTION
CF-ID-01	WOOD TRIM IN TEAK STAIN FINISH
CF-ID-02	ETHNIC PATTERN ACENT CEILING
CF-ID-03	10MM THK ORDINARY GYPSUM BOARD FINISHED IN WHITEWASHED WOOD PVC CLADDING
CF-ID-04	10MM THK ORDINARY GYPSUM BOARD FINISHED IN WHEAT VENETIAN PLASTER
CF-ID-05	WOOD PVC CLADDING
CF-ID-06	BRONZE MESH LAMINATE
CF-ID-07	10MM THK ORDINARY GYPSUM BOARD FINISHED IN TALPE VENETIAN PLASTER
CF-ID-08	10MM THK MOISTURE & MOLD RESISTANT GYPSUM BOARD FINISHED IN FLAT WHITE PAINT
CF-ID-09	10MM THK GYPSUM BOARD FINISHED IN FLAT WHITE PAINT
LIGHTING GENERAL NOTES	
1. REFER TO LIGHTING DESIGNER'S PLAN FOR THE FINAL LIGHTING LAYOUT	

GROUND LEVEL
REFLECTED CEILING PLAN

1
A1-MB.02.01
SCALE 1 : 100

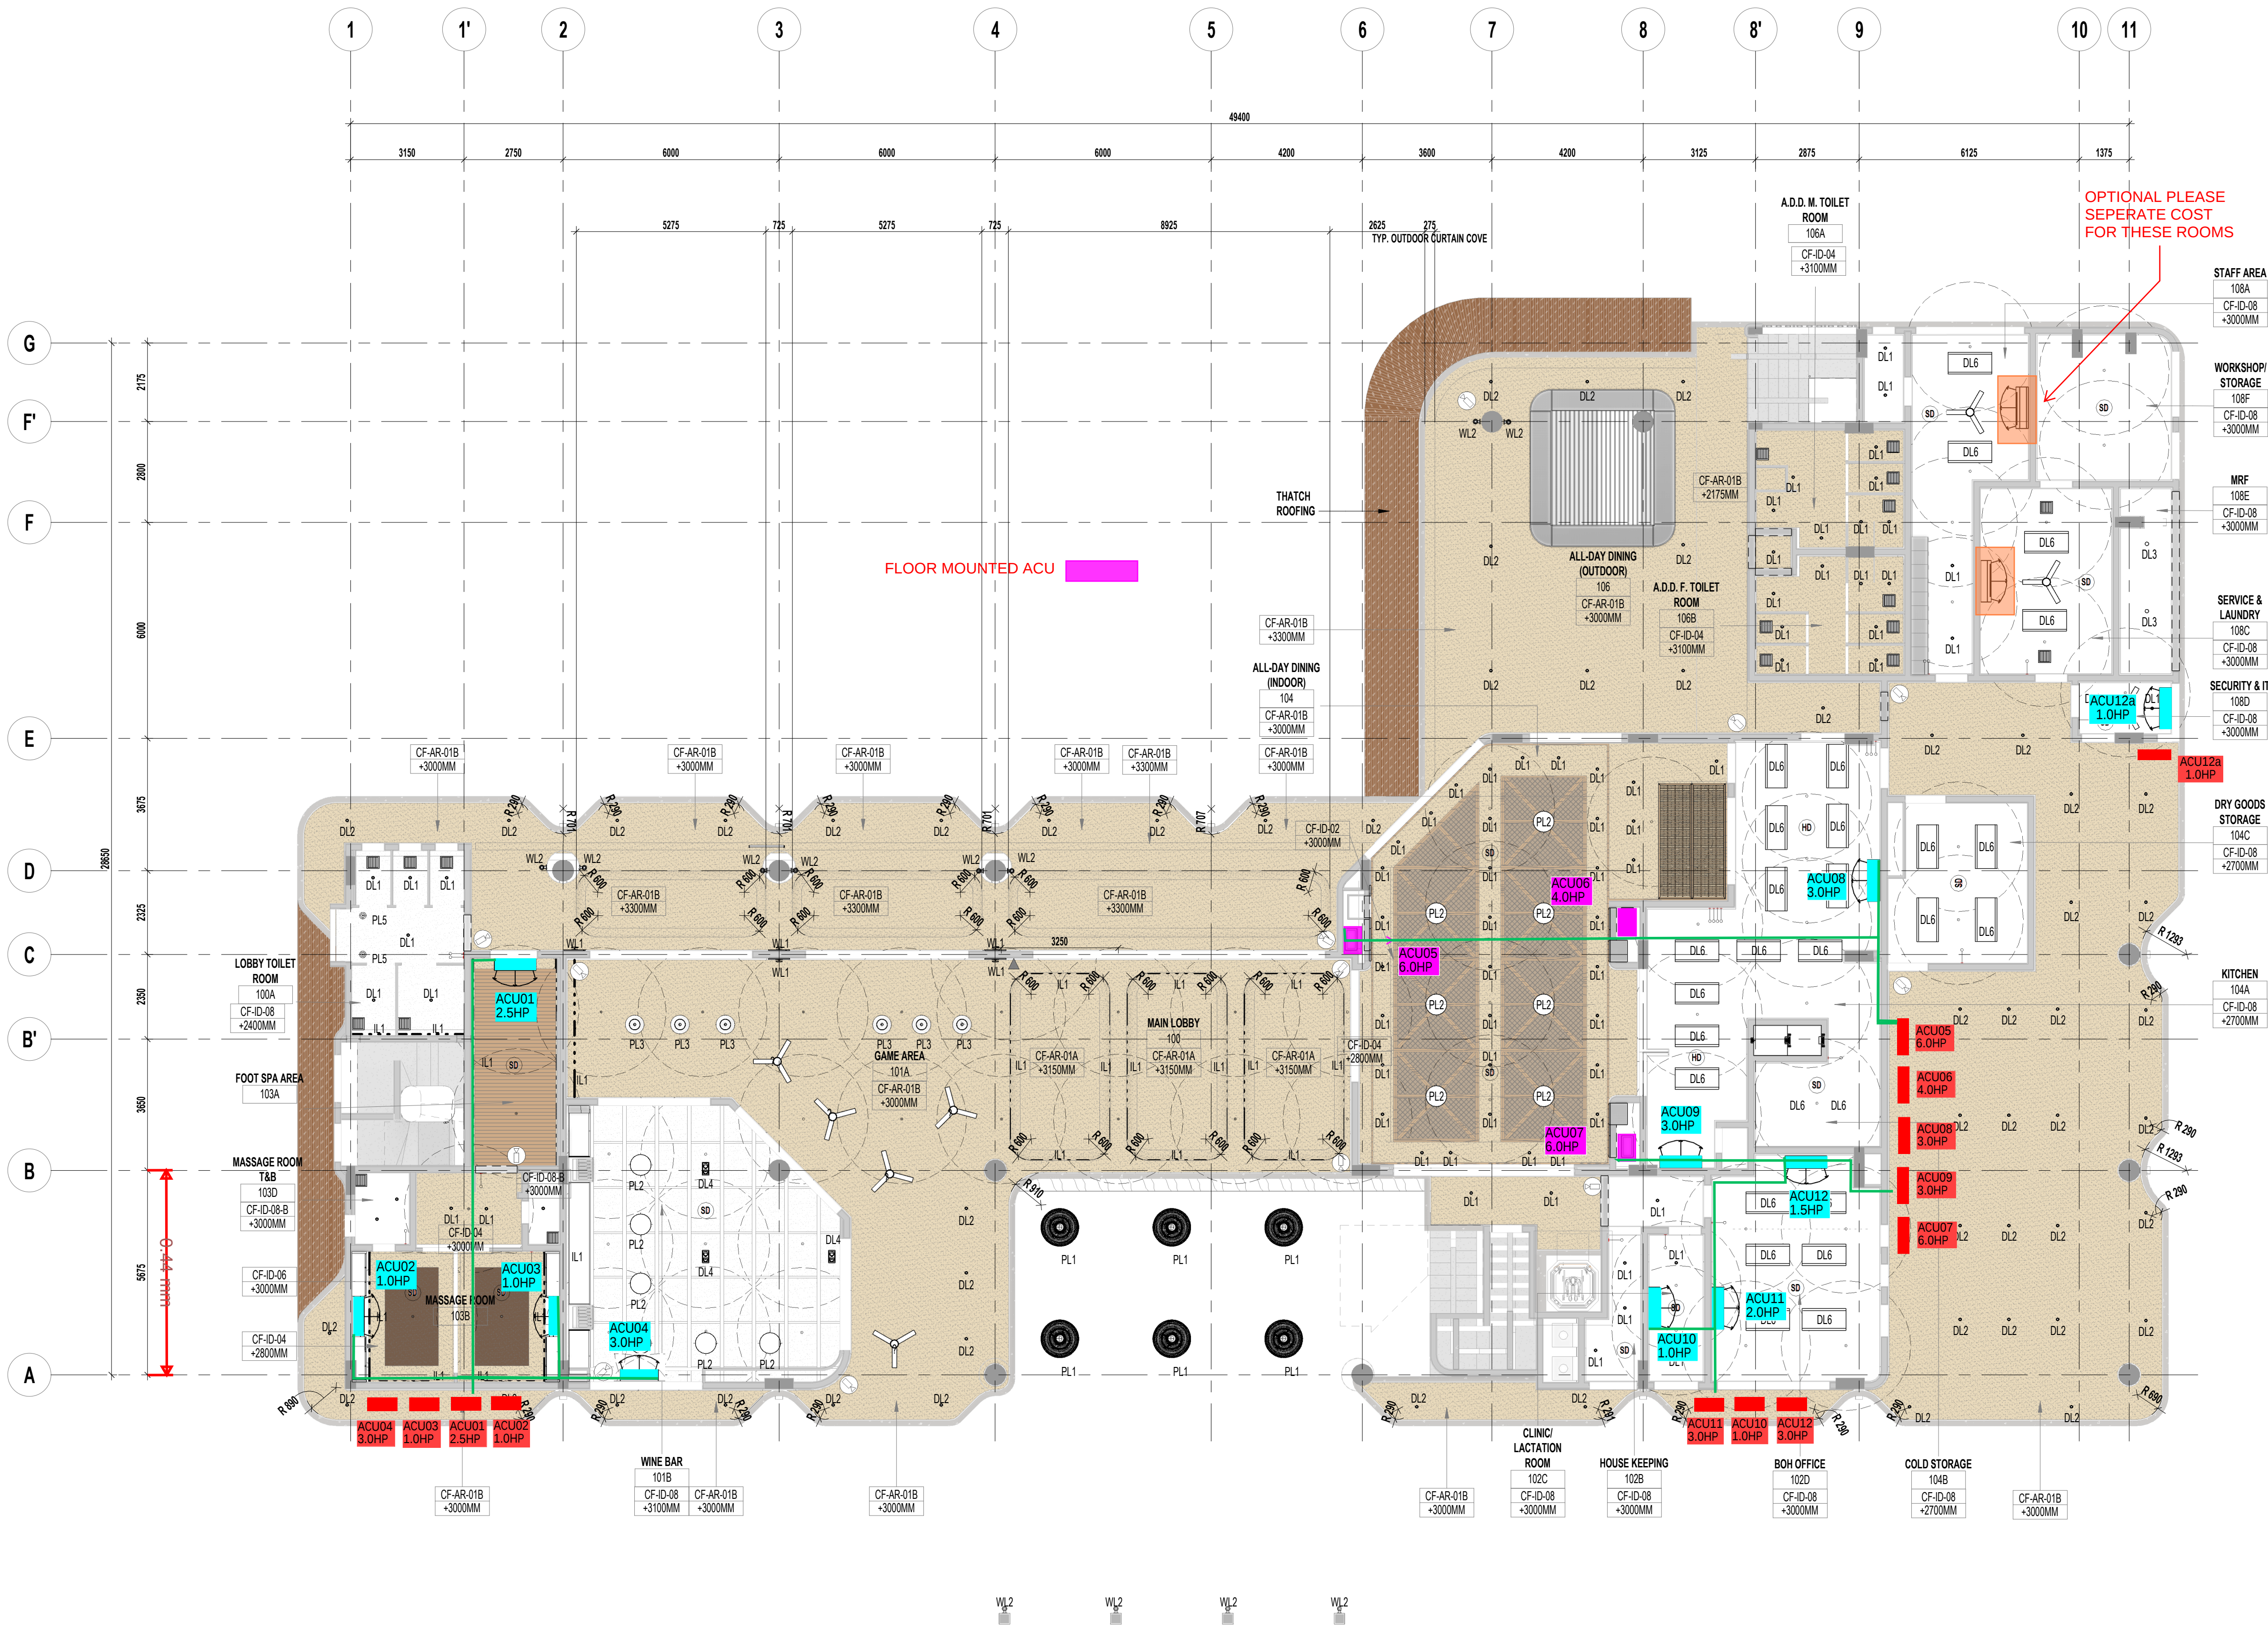

ISSUED BY:			
AR. DENISE DE CASTRO			
DESIGN NO.			
TIN NO.	302-208-959-000	REG NO.	0024133
ISSUED:	01/08/2025	PTR NO.	10469978
IAPCA NO.	20317-004066-080724		
DRAWINGS AND SPECIFICATIONS ONLY SHOWN, STAMPED OR SEALED AS INSTRUMENTS OF SERVICE, ARE THE INTELLECTUAL PROPERTY AND DOCUMENTS OF THE ARCHITECT, WHETHER THE OBJECT FOR WHICH THEY ARE MADE IS EXECUTED OR NOT. IT SHALL BE UNLAWFUL FOR ANY PERSON, WITHOUT THE CONSENT OF THE ARCHITECT, TO DUPLICATE OR TO MAKE COPIES OF SAID DOCUMENTS FOR USE IN THE REPRODUCTION OF OTHER PROJECTS OR BUILDINGS, WHETHER EXECUTED COMPLETELY OR IN WHOLE.			
REPUBLIC OF PHILIPPINES			

THE GREENHOUSE: PROPOSED 3-STOREY HOTEL BUILDING

MR. FREDERICK T. SIY
TOURISM RD., BRGY. CATANGNAN,
GEN. LUNA, SURIGAO DEL NORTE

FOR CONSTRUCTION

ARCHITECT DESIGNER	DEQA	STRUCTURAL	FASTCON	MECHANICAL AND FIRE PROTECTION	FASTCON
	DEQA		FASTCON		FASTCON
INTERIOR DESIGNER	DEQA	ELECTRICAL	FASTCON	PLUMBING AND SANITARY	FASTCON
	DEQA		FASTCON		FASTCON
CIVIL WORKS	DEQA	ELECTRONICS	FASTCON	LANDSCAPE ARCHITECT	FASTCON
	DEQA		FASTCON		FASTCON

SHEET ISSUES / REVISIONS

NO.	DATE	BY	DESCRIPTION
-----	------	----	-------------

KEY PLAN

CEILING PLANS

DESIGNED BY:	DDC	SHEET NO.:	A1-MB.02.01
DATE ISSUED:	17-MAR-20		
DATE PRINTED:	11/09/2025 9:51:54 am	SCALEs indicated	

Drawing Plotted: 11/09/2025 9:51:54 am

GENERAL NOTE: DO NOT SCALE FROM DRAWING. USE MARKED DIMENSIONS TO BE READ IN CONJUNCTION WITH ALL OTHER CONSULTANTS' DRAWINGS. THE ARCHITECT'S FIRM DISCLAIMS ANY UNDERSIGNEDS' COPYRIGHT OF THE DRAWING/STAMPED BY THE ARCHITECT.

 
PAPER SIZE: PRINTING GUIDE: A1 - 1100, A2 - 1100



SHEET LEGEND	
LIGHTING FIXTURE	
SYMBOL	DESCRIPTION
RECESSED LIGHTING	
DL1	LED RECESSED DOWN LIGHT 10W-36 DEG-IP54 WARM WHITE 3500K
SURFACE MOUNTED LIGHTING	
DL2	LED SURFACE MOUNTED 14W-FROSTED-IP56 WARM WHITE 3500K
DL3	LED SURFACE MOUNTED CANNED 14W-FROSTED-IP56 WARM WHITE 3500K
DL4	LED SURFACE MOUNTED DUAL DIRECTIONAL LIGHTS 10W-36 DEG-IP4 WARM WHITE 3500K
DL5	LED SURFACE MOUNTED DIRECTIONAL LIGHTS 10W-36 DEG-IP4 WARM WHITE 3500K
DL6	600 X 1200MM LED PANEL CEILING LIGHT
PENDANTS/SUSPENDED LIGHTING	
PL1	DECORATIVE PENDANT LIGHTING 3500K (REFER TO ID FOR SPECIFICATIONS)
PL2	DECORATIVE PENDANT LIGHTING 3500K (REFER TO ID FOR SPECIFICATIONS)
PL3	DECORATIVE PENDANT LIGHTING 3500K (REFER TO ID FOR SPECIFICATIONS)
PL4	DECORATIVE PENDANT LIGHTING 3500K (REFER TO ID FOR SPECIFICATIONS)
PL5	DECORATIVE PENDANT LIGHTING (REFER TO ID FOR SPECIFICATIONS)
WALL LAMPS	
WL1	DECORATIVE WALL LAMPS 5W-IP65 WARM WHITE 3500K (REFER TO ID FOR SPECIFICATIONS)
WL2	LED DECORATIVE WALL LAMPS 5W-IP65 WARM WHITE 3500K (REFER TO ID FOR SPECIFICATIONS)
WL3	DECORATIVE WALL LAMPS 5W-IP65 WARM WHITE 3500K (REFER TO ID FOR SPECIFICATIONS)
WL4	WALL MOUNTED POOL LIGHTING
WL5	BED-SIDE WALL MOUNTED LAMP
WL6	VANITY TABLE WALL MOUNTED LAMP
WL7	PREMIUM ROOM WALL MOUNTED LAMP
INDIRECT LIGHTING	
IL1	LED NEON FLEX 5 DIM 100 DEG-IP56 NEUTRAL WHITE 4000K
EXTERIOR CEILING FINISHES	
TAG	DESCRIPTION
CF-AR-01A	10MM THK MOISTURE & MOLD RESISTANT GYPSUM BOARD FINISHED IN WHEAT VENETIAN PLASTER SURFACE APPLIED FINISH IN WHEAT VENETIAN PLASTER
CF-AR-01B	10MM THK FIBER CEMENT BOARD FINISHED IN WHEAT VENETIAN PLASTER SURFACE APPLIED FINISH IN WHEAT VENETIAN PLASTER
CF-AR-02	RUNO BAMBOO
CF-AR-03	WOOD STAIN FINISH
INTERIOR CEILING FINISHES	
TAG	DESCRIPTION
CF-ID-01	WOOD TRIM IN TEAK STAIN FINISH
CF-ID-02	ETHNIC PATTERN ACCENT CEILING
CF-ID-03	10MM THK ORDINARY GYPSUM BOARD FINISHED IN WHITENASHED WOOD PVC CLADDING
CF-ID-04	10MM THK ORDINARY GYPSUM BOARD FINISHED IN WHEAT VENETIAN PLASTER
CF-ID-05	WOOD PVC CLADDING
CF-ID-06	BROWN MESH LUMINATE
CF-ID-07	10MM THK ORDINARY GYPSUM BOARD FINISHED IN TALPEI VENETIAN PLASTER
CF-ID-08A	10MM THK MOISTURE & MOLD RESISTANT GYPSUM BOARD FINISHED IN FLAT WHITE PAINT
CF-ID-08B	10MM THK GYPSUM BOARD FINISHED IN FLAT WHITE PAINT
LIGHTING GENERAL NOTES	
1. REFER TO LIGHTING DESIGNER'S PLAN FOR THE FINAL LIGHTING LAYOUT	

SECOND LEVEL
REFLECTED CEILING PLAN

1
A1-MB.02.02
SCALE 1 : 100

	ISSUED BY: AR. DENISE DE CASTRO DESIGNER		THE GREENHOUSE: PROPOSED 3-STOREY HOTEL BUILDING		 FASTCON FASTCON		SHEET ISSUES / REVISIONS				KEY PLAN		CEILING PLANS			
	TIN NO.: 302-208-959-000	REG NO.: 0024133	MR. FREDERICK T. SIY		 FASTCON FASTCON		NO.				DATE					
	ISSUED: 01/08/2025	PTR NO.: 10469978	TOURISM RD., BRGY. CATANGWAN, GEN. LUNA, SURIGAO DEL NORTE		INTERIOR DESIGNER		BY				DESCRIPTION					
	IAPCA NO.: 20317-004066-080724		FOR CONSTRUCTION		CIVIL WORKS											
DRAWINGS AND SPECIFICATIONS JULY SIGNED, STAMPED OR SEALED, AS INSTRUMENTS OF SERVICE, ARE THE INTELLECTUAL PROPERTY AND DOCUMENTS OF THE ARCHITECT. WHETHER THE SUBJECT OR WHOM THEY ARE MADE IS EXECUTED OR NOT, IT SHALL BE UNLAWFUL FOR ANY PERSON WITHOUT THE CONSENT OF THE ARCHITECT TO DUPLICATE OR TO MAKE COPIES OF SAID DOCUMENTS FOR USE IN THE EXECUTION OF OTHER PROJECTS OR BUILDINGS, WHETHER EXECUTED PARTLY OR IN WHOLE.																
REPUBLIC ACT 103																

Drawing Plotted: 11/09/2025 9:53:12 am

GENERAL NOTE: DO NOT SCALE FROM DRAWINGS. USE MARKED DIMENSIONS TO BE READ IN CONJUNCTION WITH ALL OTHER CONSULTANTS' DRAWINGS. THE ARCHITECT'S FIRM DISCLAIMS ANY LIABILITY FOR ANY OVERSIGHTS, OMISSIONS, OR ERRORS IN THE DRAWINGS PREPARED BY THE ARCHITECT.

PAPER SIZE: PRINTING GUIDE: A1 - 1100 X 1500



SHEET LEGEND	
LIGHTING FIXTURE	
SYMBOL	DESCRIPTION
RECESSED LIGHTING	
DL1	LED RECESSED DOWN LIGHT 10W-36 DEG-IP54 WARM WHITE 3500K
SURFACE MOUNTED LIGHTING	
DL2	LED SURFACE MOUNTED 14W-FROSTED-IP56 WARM WHITE 3500K
DL3	LED SURFACE MOUNTED CANNED 14W-FROSTED-IP56 WARM WHITE 3500K
DL4	LED SURFACE MOUNTED DUAL DIRECTIONAL LIGHTS 10W-36 DEG-IP4 WARM WHITE 3500K
DL5	LED SURFACE MOUNTED DIRECTIONAL LIGHTS 10W-36 DEG-IP4 WARM WHITE 3500K
DL6	600 X 1200MM LED PANEL CEILING LIGHT
PENDANTS/SUSPENDED LIGHTING	
PL1	DECORATIVE PENDANT LIGHTING 3500K (REFER TO ID FOR SPECIFICATIONS)
PL2	DECORATIVE PENDANT LIGHTING 3500K (REFER TO ID FOR SPECIFICATIONS)
PL3	DECORATIVE PENDANT LIGHTING 3500K (REFER TO ID FOR SPECIFICATIONS)
PL4	DECORATIVE PENDANT LIGHTING 3500K (REFER TO ID FOR SPECIFICATIONS)
PL5	DECORATIVE PENDANT LIGHTING (REFER TO ID FOR SPECIFICATIONS)
WALL LAMPS	
WL1	DECORATIVE WALL LAMPS 5W-IP65 WARM WHITE 3500K (REFER TO ID FOR SPECIFICATIONS)
WL2	LED DECORATIVE WALL LAMPS 5W-IP65 WARM WHITE 3500K (REFER TO ID FOR SPECIFICATIONS)
WL3	DECORATIVE WALL LAMPS 5W-IP65 WARM WHITE 3500K (REFER TO ID FOR SPECIFICATIONS)
WL4	WALL MOUNTED POOL LIGHTING
WL5	BED-SIDE WALL MOUNTED LAMP
WL6	VANITY TABLE WALL MOUNTED LAMP
WL7	PREMIUM ROOM WALL MOUNTED LAMP
INDIRECT LIGHTING	
IL1	LED NEON FLEX 5 DIM 1000MM IP56 NEUTRAL WHITE 4000K
EXTERIOR CEILING FINISHES	
TAG	DESCRIPTION
CF-AR-01A	10MM THK MOISTURE & MOLD RESISTANT GYPSUM BOARD FINISHED IN WHEAT VENETIAN PLASTER SURFACE APPLIED FINISH IN WHEAT VENETIAN PLASTER
CF-AR-01B	10MM THK FIBER CEMENT BOARD FINISHED IN WHEAT VENETIAN PLASTER SURFACE APPLIED FINISH IN WHEAT VENETIAN PLASTER
CF-AR-02	RUNO BAMBOO
CF-AR-03	WOOD STAIN FINISH
INTERIOR CEILING FINISHES	
TAG	DESCRIPTION
CF-ID-01	WOOD TRIM IN TEAK STAIN FINISH
CF-ID-02	ETHNIC PATTERN ACCENT CEILING
CF-ID-03	10MM THK ORDINARY GYPSUM BOARD FINISHED IN WHITENASHED WOOD PVC CLADDING
CF-ID-04	10MM THK ORDINARY GYPSUM BOARD FINISHED IN WHEAT VENETIAN PLASTER
CF-ID-05	WOOD PVC CLADDING
CF-ID-06	BROWN MESH LUMINATE
CF-ID-07	10MM THK ORDINARY GYPSUM BOARD FINISHED IN TALPEL VENETIAN PLASTER
CF-ID-08A	10MM THK MOISTURE & MOLD RESISTANT GYPSUM BOARD FINISHED IN FLAT WHITE PAINT
CF-ID-08B	10MM THK GYPSUM BOARD FINISHED IN FLAT WHITE PAINT
LIGHTING GENERAL NOTES	
1. REFER TO LIGHTING DESIGNER'S PLAN FOR THE FINAL LIGHTING LAYOUT	

THIRD LEVEL

REFLECTED CEILING PLAN

1
A1-MB.02.03
SCALE 1:100



ISSUED BY:			
AR. DENISE DE CASTRO DESIGNER			
TIN NO.:	302-208-959-000	REG NO.:	0024133
ISSUED:	01/08/2025	PTR NO.:	10469878
IAPCA NO.:	20317-004066-080724		
DRAWINGS AND SPECIFICATIONS ONLY SIGNED, STAMPED OR SEALED AS INSTRUMENTS OF SERVICE, ARE THE INTELLECTUAL PROPERTIES AND DOCUMENTS OF THE ARCHITECT. WITHOUT THE WRITTEN CONSENT OF THE ARCHITECT, NO PART OF THIS DRAWING OR ANY INFORMATION CONTAINED HEREIN SHALL BE REPRODUCED OR TRANSMITTED IN ANY FORM OR BY ANY MEANS, ELECTRONIC OR MECHANICAL, INCLUDING PHOTOCOPYING, RECORDING, OR BY ANY INFORMATION STORAGE AND RETRIEVAL SYSTEM. WITHOUT THE WRITTEN CONSENT OF THE ARCHITECT.			

THE GREENHOUSE: PROPOSED 3-STORY HOTEL BUILDING	
MR. FREDERICK T. SIY	
TOURISM RD., BRGY. CATANGNAN, GEN. LUNA, SURIGAO DEL NORTE	
FOR CONSTRUCTION	

	ARCHITECT DESIGNER		STRUCTURAL		MECHANICAL AND FIRE PROTECTION	
						
	INTERIOR DESIGNER		ELECTRICAL		PLUMBING AND SANITARY	
						
CIVIL WORKS		ELECTRONICS		LANDSCAPE ARCHITECT		

SHEET ISSUES / REVISIONS			
NO.	DATE	BY	DESCRIPTION

KEY PLAN	

CEILING PLANS	
DESIGNED BY: DDC	SHEET NO: A1-MB.02.03
DATE ISSUED: 17-MM-00	SCALE: As indicated
DATE PRINTED: 11/09/2025 9:53:31 am	