




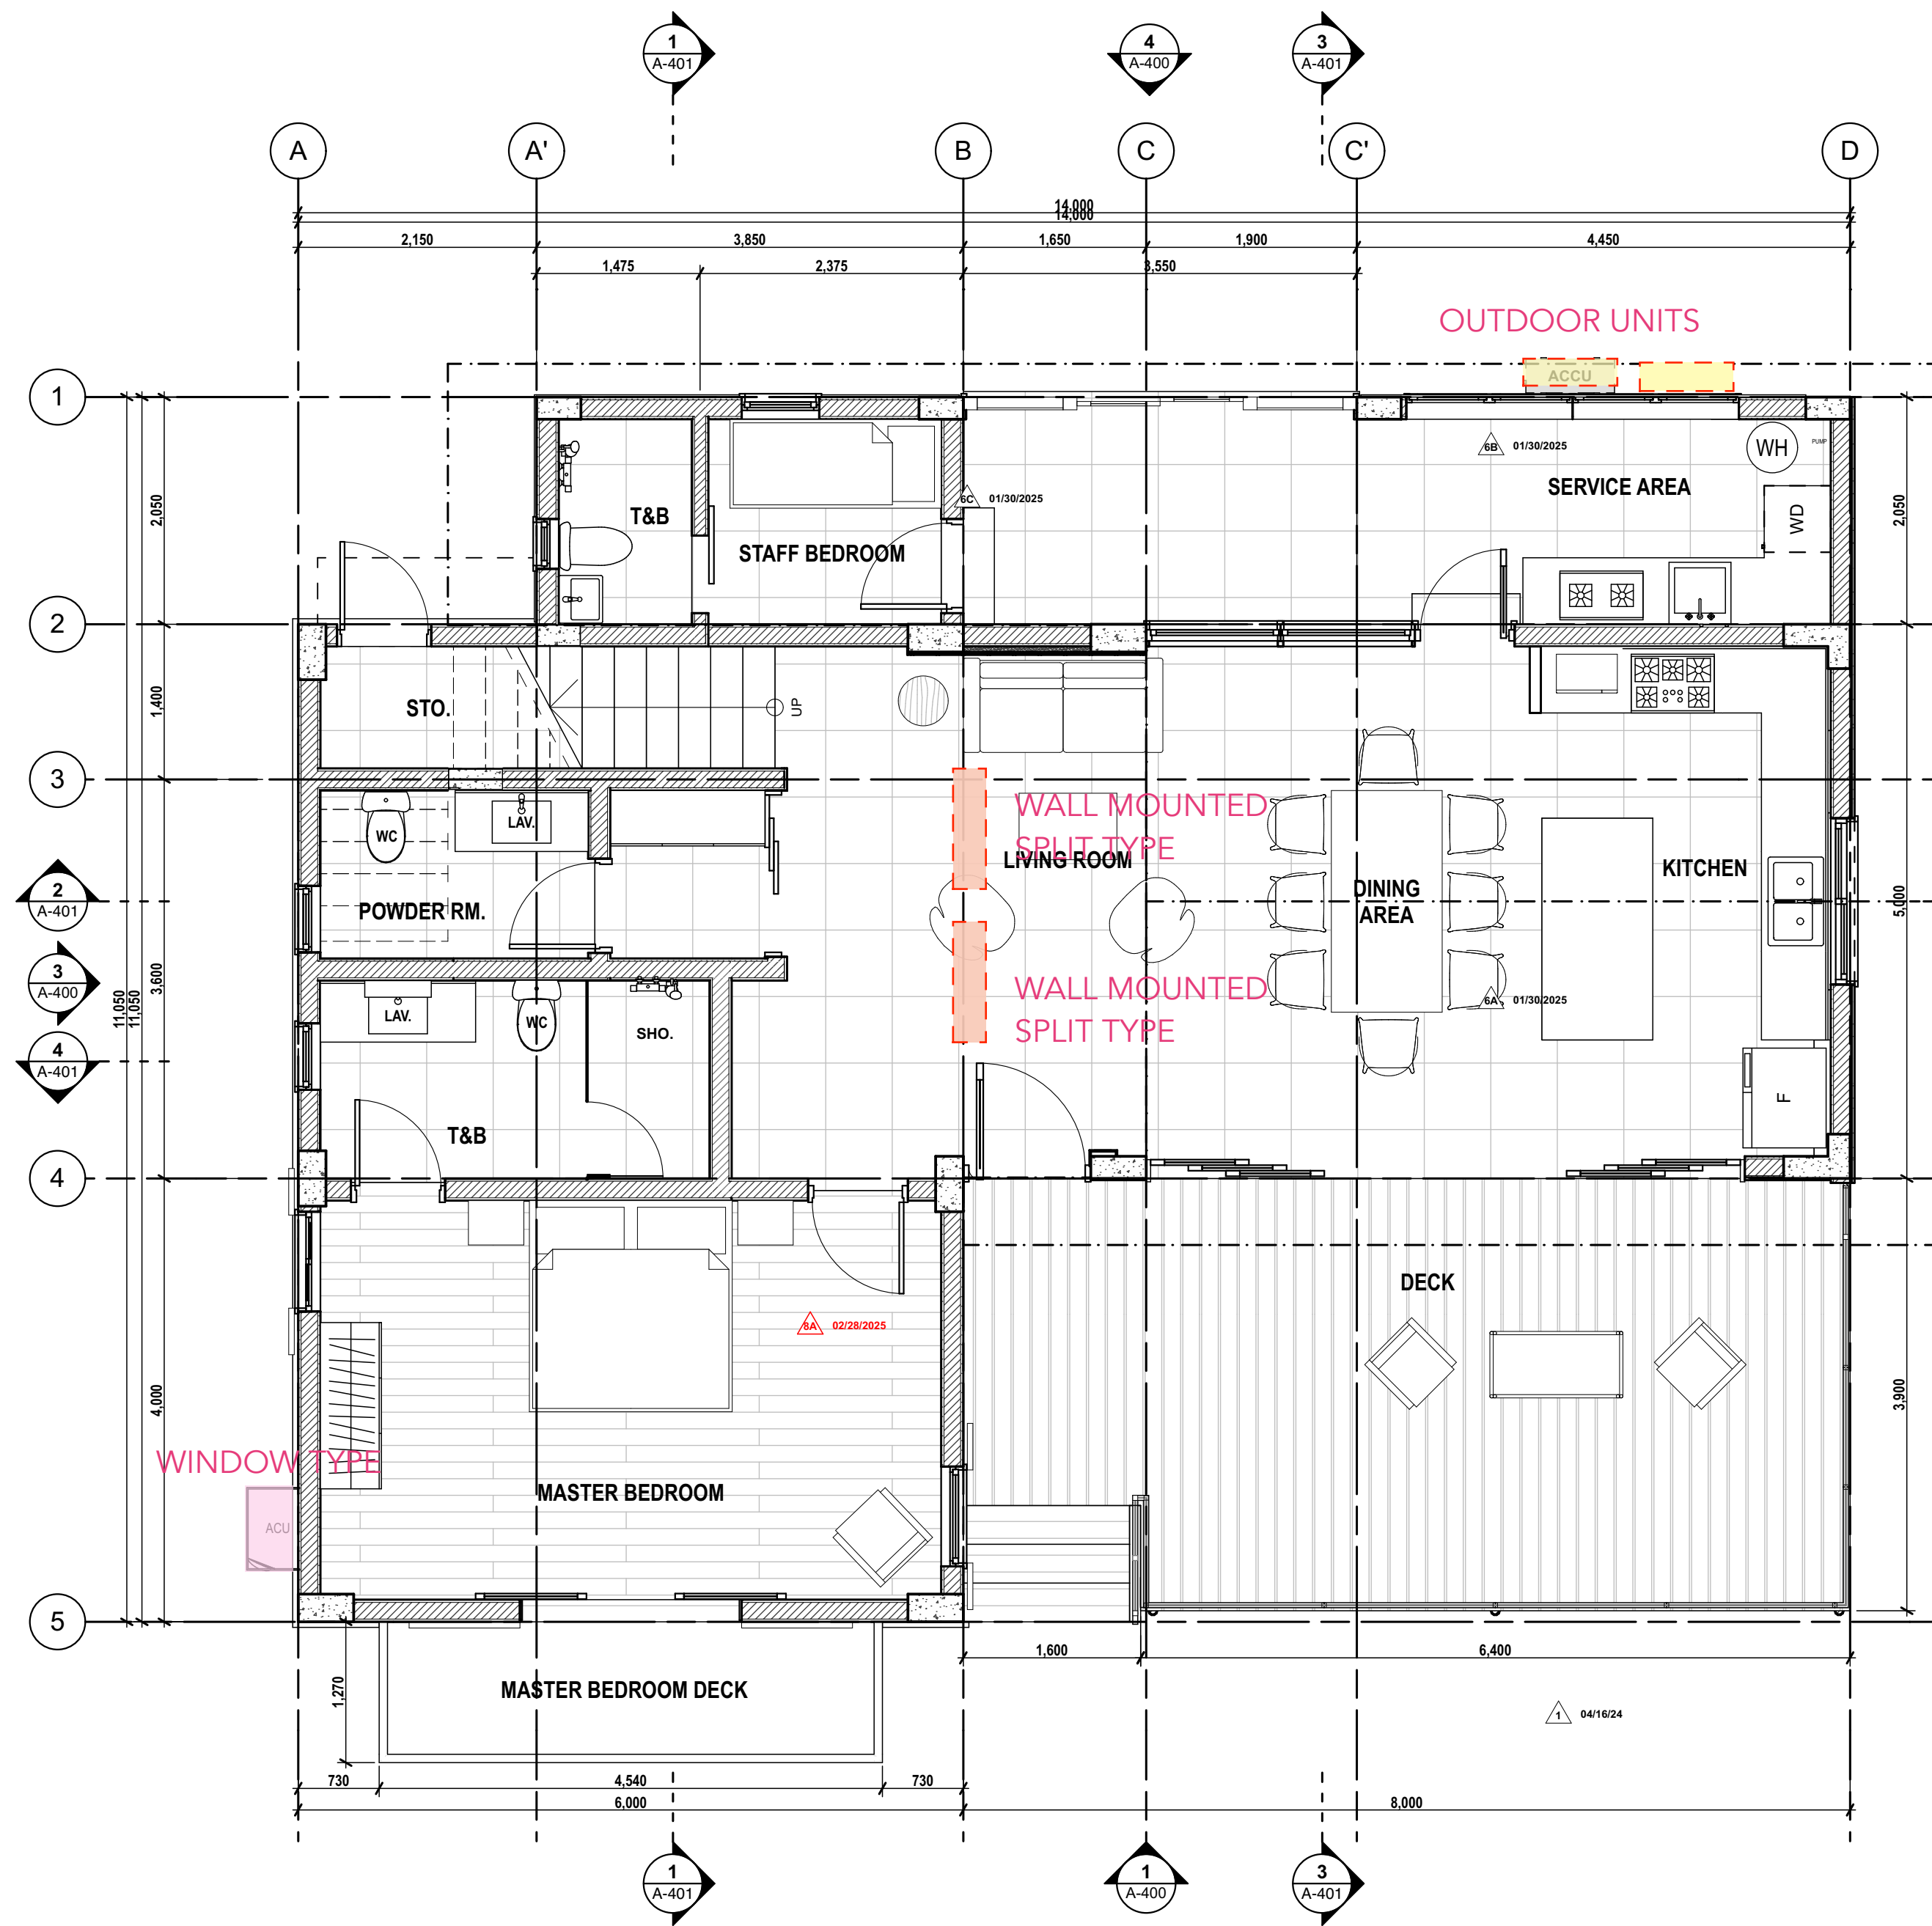

1 1/F FURNITURE PLAN
SCALE 1:50

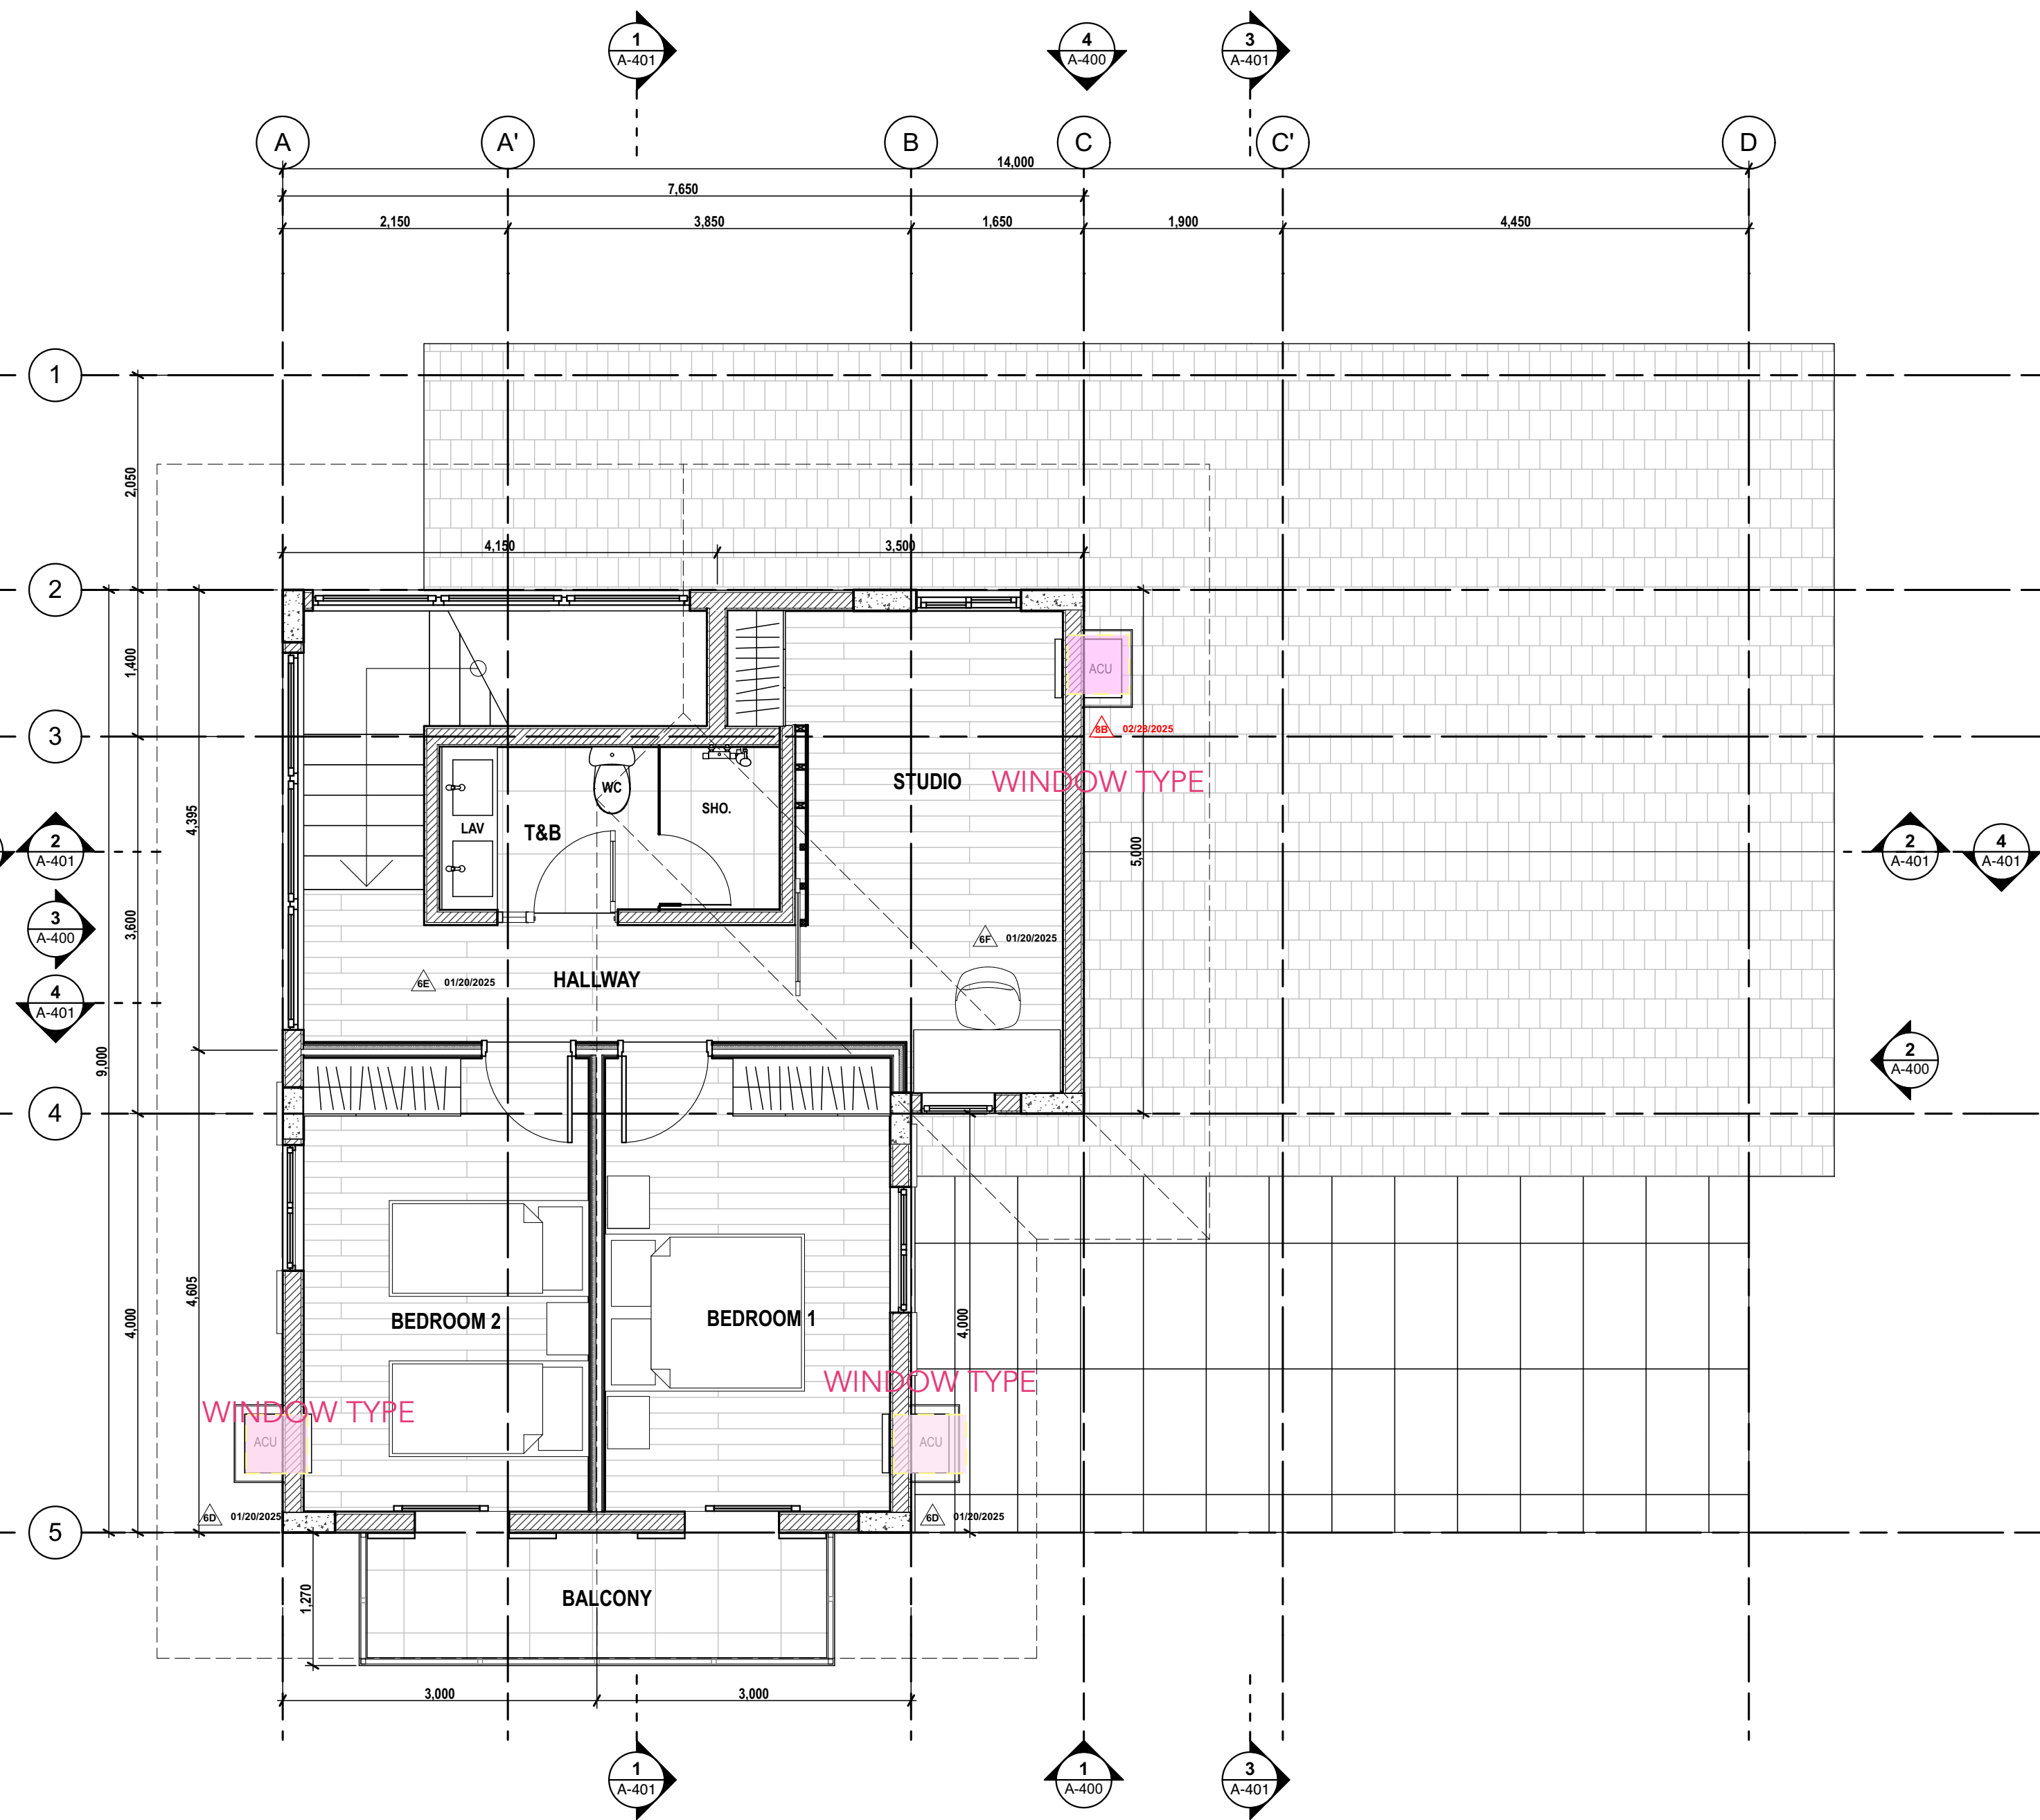

2 2/F FURNITURE LAYOUT
SCALE 1:50

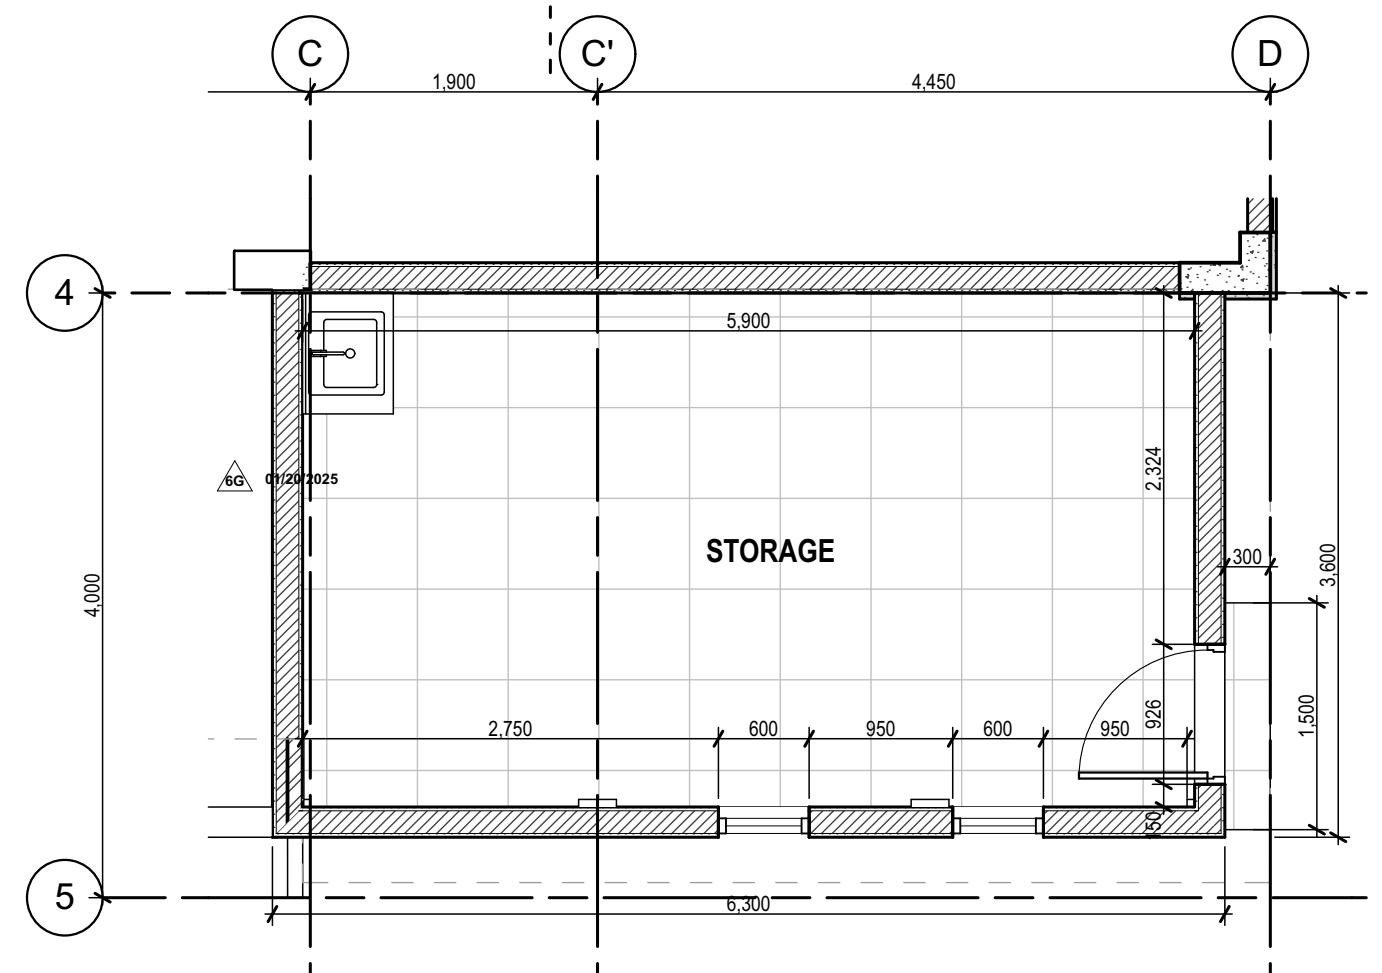

3 LOWER LEVEL STORAGE
SCALE 1:50

ISSUES & REVISIONS		DATE
FOR PERMIT		AUGUST 9, 2023
FOR CONSTRUCTION		MARCH 21, 2024
FOR CONSTRUCTION		MARCH 25, 2024
CONSTRUCTION BULLETIN #1		MAY 07, 2024
CONSTRUCTION BULLETIN #2		NOVEMBER 14, 2024
FOR OWNER APPROVAL		JANUARY 30, 2025
CONSTRUCTION BULLETIN #3		FEBRUARY 20, 2025
OWNER APPROVED PLANS		FEBRUARY 28, 2025

REVISION NOTES	
MAY 07, 2024	FLIPPED PLANS AND ADDITION OF BASEMENT
NOVEMBER 14, 2024	5A - REFLECTED THE FLOOR FINISH DROP/ELEVATION ON FLOOR FINISH PLAN
	5B - PROVIDED ADDITIONAL STEP-UP FOR BASEMENT ENTRY
	5C - VERIFIED ELEVATIONS
JANUARY 30, 2025	6A - RELAYOUT OF KITCHEN SINK AND STOVE AT MAIN KITCHEN AREA
	6B - RELAYOUT OF KITCHEN SINK AT SERVICE AREA
	6C - PROVISION OF SLIDING GLASS DOOR AT SERVICE AREA
	6D - RELOCATED WINDOW & ACU ON 2/F BEDROOMS
	6E - RELAYOUT OF TOILET AT 2/F AND ADDITION OF LAVATORY
	6F - ADDITION OF ACU AT STUDIO ROOM
	6G - ADDITION OF LAVATORY AT BASEMENT

UNIT 2C, 299 P. GUEVARA BLDG.
299 P. GUEVARA ST.
BGC LITTLE BAGUIO
SAN JUAN CITY 1500
PHILIPPINES

foro
CONSULTING, INC.
architects
designers

ARCHITECT:
ARCH. MICHAEL FRANCIS C. OLIVARES
REG. NO. 0010272
PTR NO. 1673420
NAPDA 15073 391565 062025
DATE 01/03/2024
LOCATION SAN JUAN CITY
DATE 06/30/2024


OWNER REPRESENTATIVES:
MR. JOSE C. LOPA
MRS. ANNA L. LOPEZ
MR. MICHAEL C. LOPA
Lopa Farm Marilau Highway Sitio Mayagay,
Brgy. Sampaloc, Tanay Rizal

PROJECT TITLE:
**LOPA COMPOUND
DEVELOPMENT**
Lopa Farm Marilau Highway Sitio Mayagay,
Brgy. Sampaloc, Tanay Rizal

SHEET CONTENTS:
**HOUSE 4
FURNITURE LAYOUT**

SCALE:	AS SHOWN	SHEET NO.:
DRAWN BY:	ADI, JJC, AAC, MMT, BCA	A-101
CHECKED BY:	MCO	
DATE:	02/20/2025	
REVISED:		

ALL DESIGN, PRINTS AND SPECIFICATIONS ARE THE PROPERTY OF FORO CONSULTING, INC. AND CANNOT BE USED WITHOUT THEIR WRITTEN PERMISSION. THE SAME SHALL BE RETURNED AT COMPLETION OF THE WORK. DO NOT SCALE DRAWINGS. ALL MEASUREMENTS MUST BE CHECKED AT THE SITE BY THE CONTRACTOR.

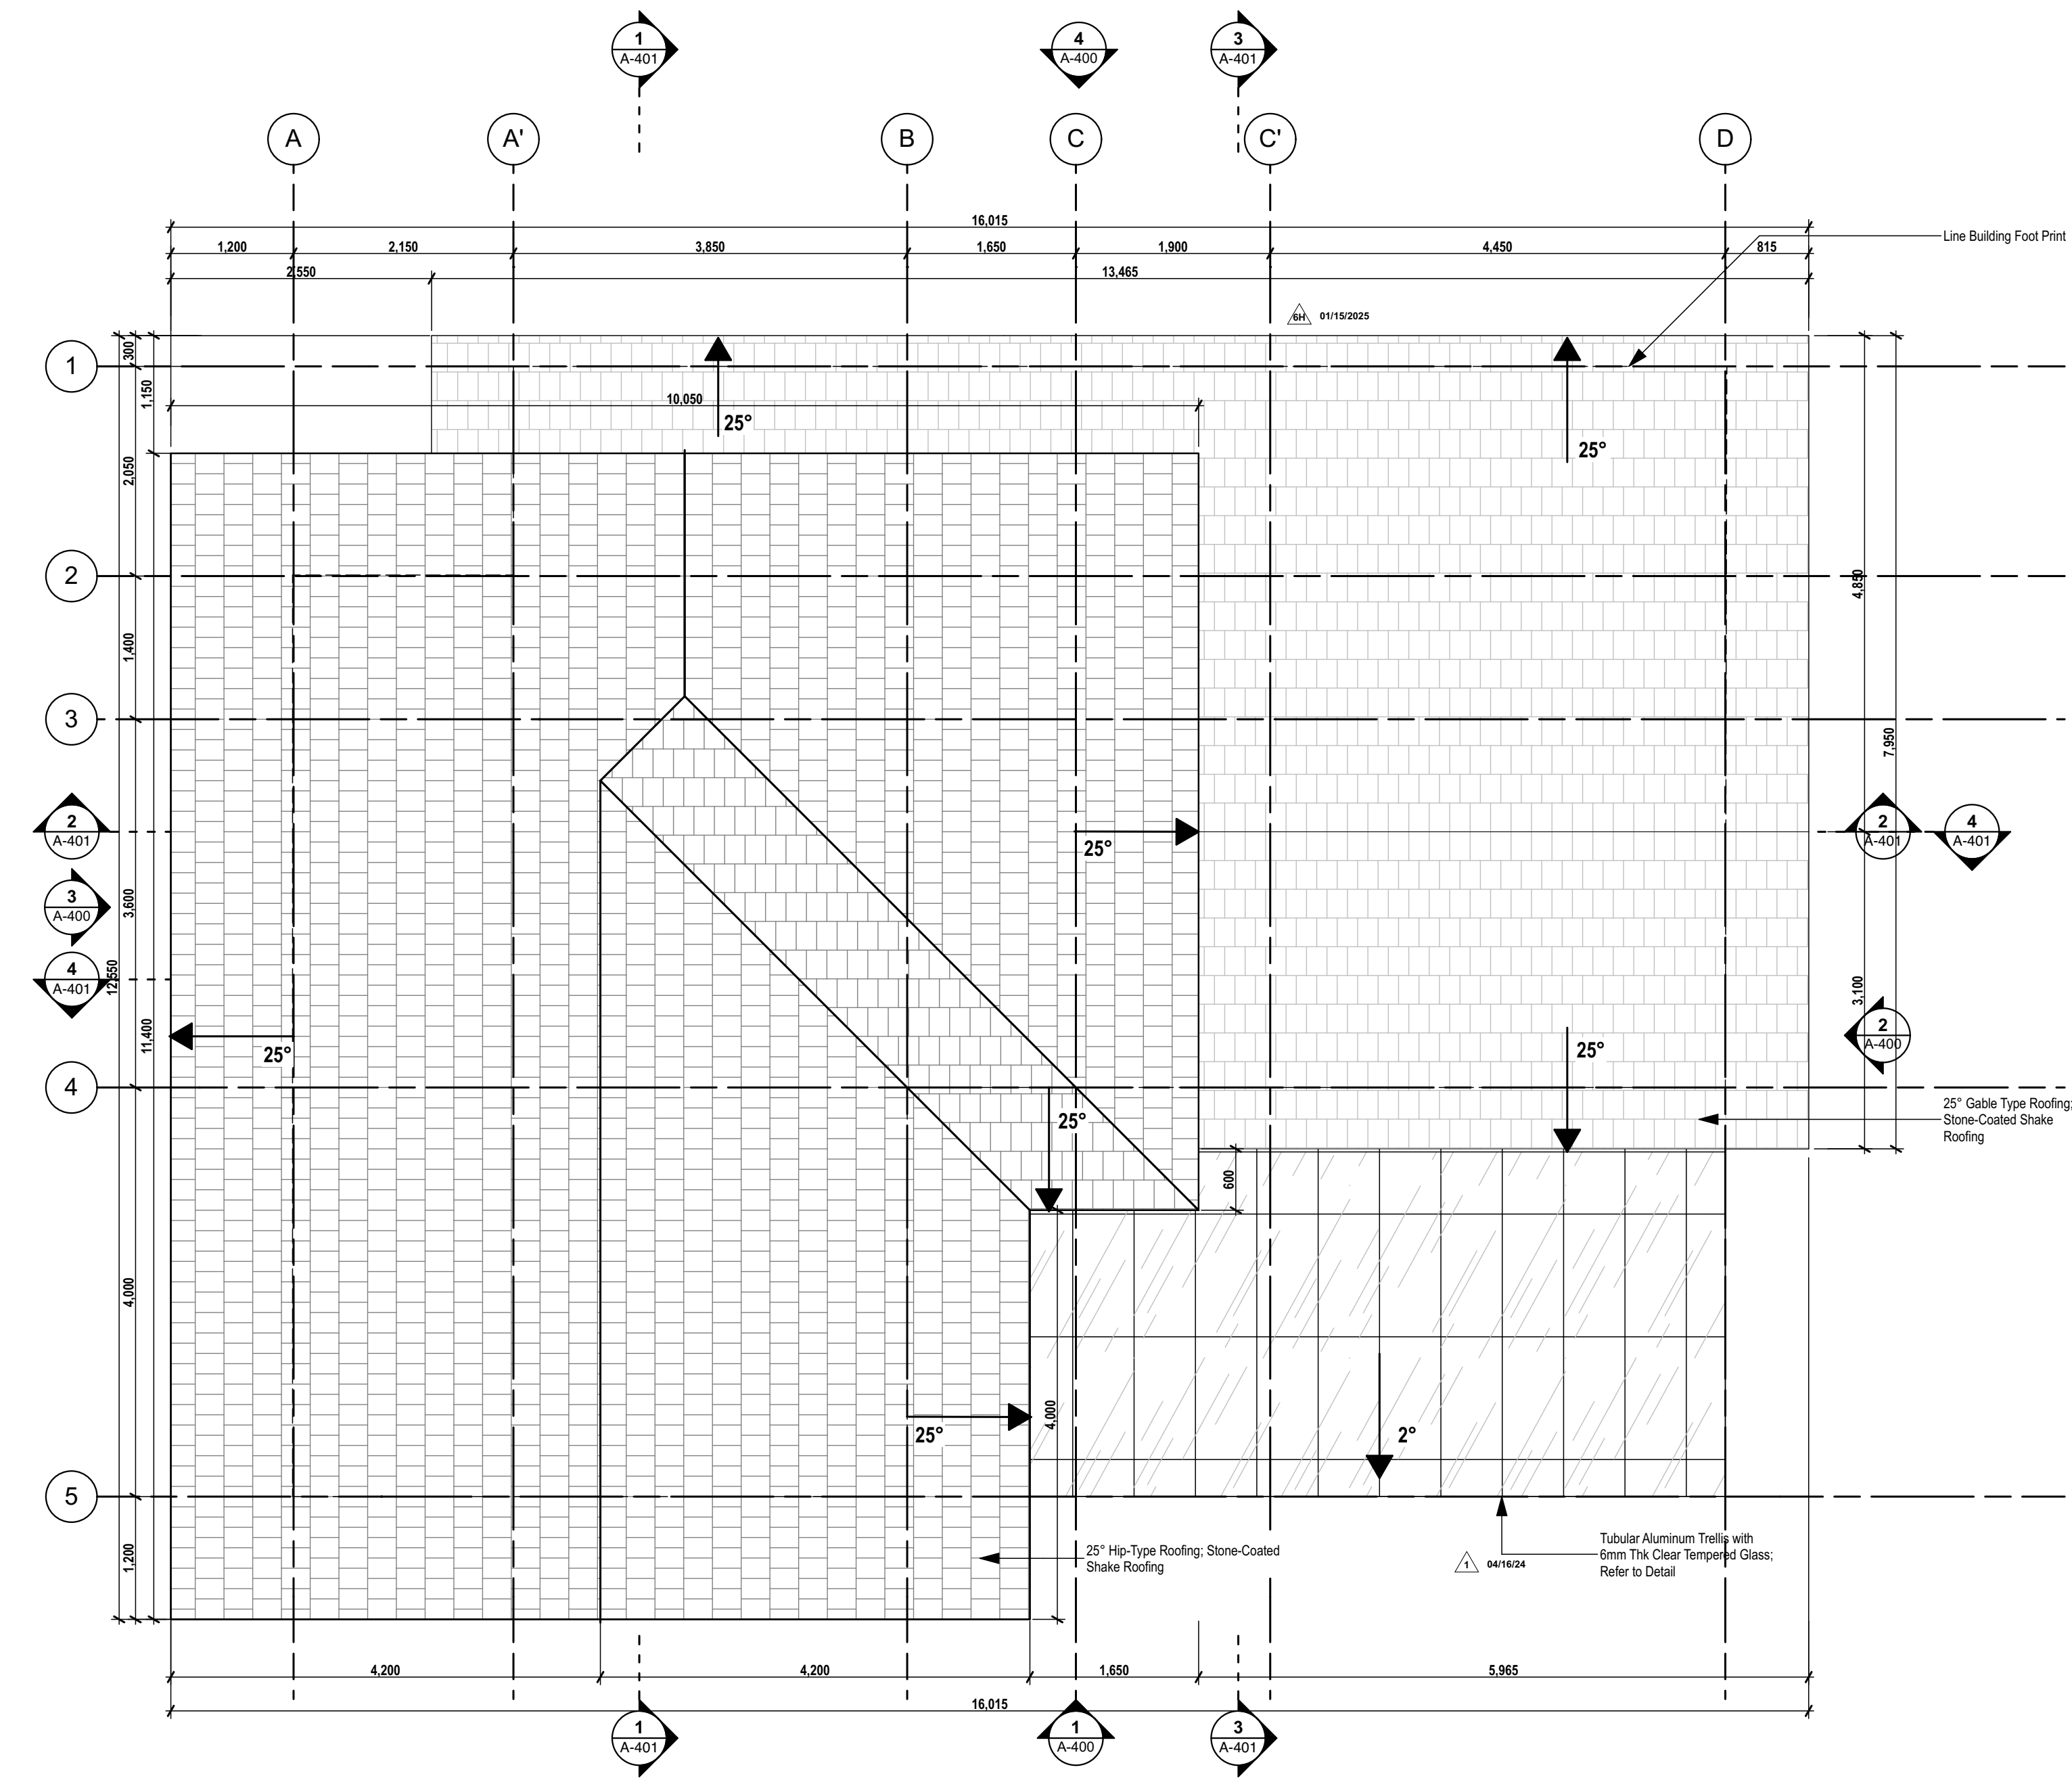

1 ROOF PLAN
A-102 SCALE: 1/50

ISSUES & REVISIONS		DATE
FOR PERMIT		AUGUST 9, 2023
FOR CONSTRUCTION		MARCH 21, 2024
FOR CONSTRUCTION		MARCH 25, 2024
CONSTRUCTION BULLETIN #1		MAY 07, 2024
CONSTRUCTION BULLETIN #2		NOVEMBER 14, 2024
FOR OWNER APPROVAL		JANUARY 30, 2025
CONSTRUCTION BULLETIN #3		FEBRUARY 20, 2025
OWNER APPROVED PLANS		FEBRUARY 28, 2025

REVISION NOTES	
MAY 07, 2024	FLIPPED PLANS AND ADDITION OF BASEMENT
NOVEMBER 14, 2024	SA - REFLECTED THE FLOOR FINISH DROP/ELEVATION ON FLOOR FINISH PLAN
	SB - PROVIDED ADDITIONAL STEP-UP FOR BASEMENT ENTRY
	SC - VERIFIED ELEVATIONS
JANUARY 30, 2025	6H - EXTENSION OF ROOF AT SERVICE AREA

foro

FORO CONSULTING, INC.
architects designers

UNIT 2C, 299 P. GUEVARRA BLDG.
299 P. GUEVARRA ST.
BGC, LITTLE BAGUIO
SAN JUAN CITY 1500
PHILIPPINES

ARCHITECT:			
ARCH. MICHAEL FRANCIS C. OLIVARES			
REG. NO.	0010272	DATE	01/03/2024
PTR NO.	1673420	LOCATION	SAN JUAN CITY
NAPDA	15073 391565 063023	DATE	06/30/2024


OWNER REPRESENTATIVES :	
MR. JOSE C. LOPA	
MRS. ANNA L. LOPEZ	
MR. MICHAEL C. LOPA	
Lopa Farm Marilauw Highway Sitio Mayagay, Brgy. Sampaloc, Tanay Rizal	

PROJECT TITLE :	
LOPA COMPOUND DEVELOPMENT	
Lopa Farm Marilauw Highway Sitio Mayagay, Brgy. Sampaloc, Tanay Rizal	


SHEET CONTENTS :	
HOUSE 4	
ROOF PLAN	

SCALE:	AS SHOWN	SHEET NO. : A-102
DRAWN BY :	ADI, JJC, AAC, MMT, BCA	
CHECKED BY :	MCO	
DATE :	02/20/2025	
REVISED:		


ALL DESIGNS, PRINTS AND SPECIFICATIONS ARE THE PROPERTY OF FORO CONSULTING, INC. AND CANNOT BE USED WITHOUT THEIR WRITTEN PERMISSION. THE SAME SHALL BE RETURNED AT COMPLETION OF THE WORK.
DO NOT SCALE DRAWINGS. ALL MEASUREMENTS MUST BE CHECKED AT THE SITE BY THE CONTRACTOR.

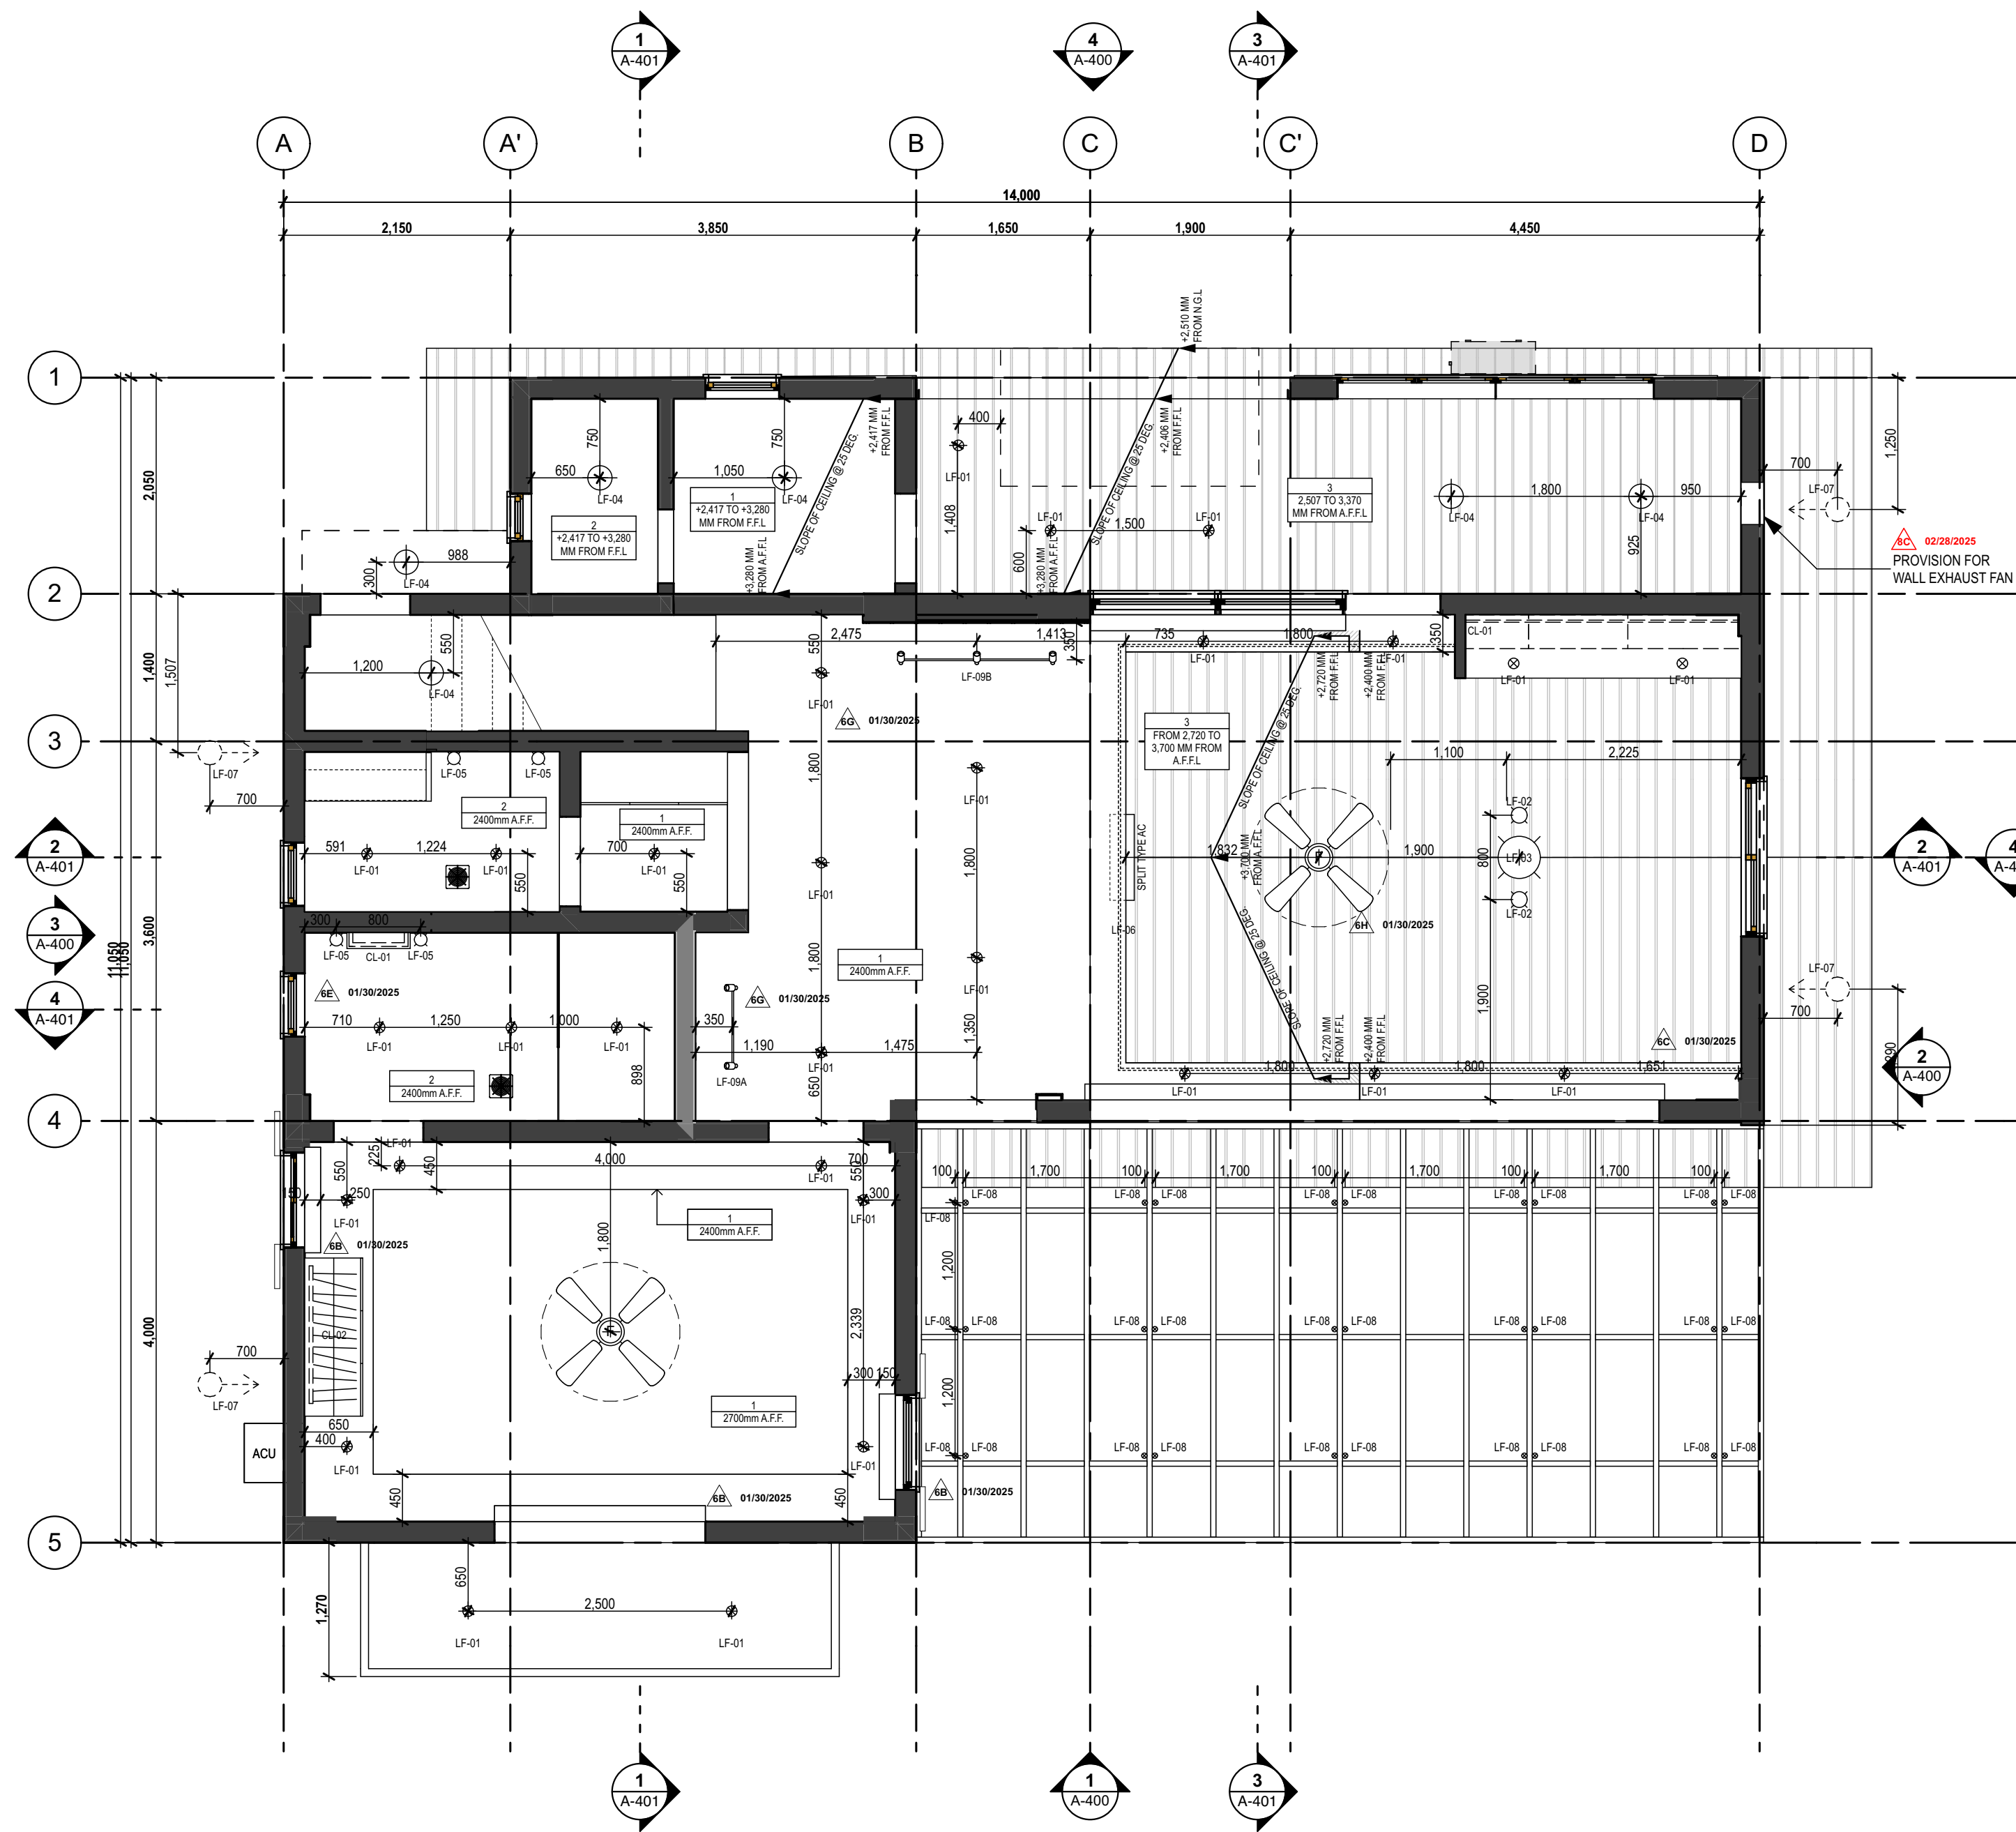

1 1/F REFLECTED CEILING PLAN
SCALE: 1:50

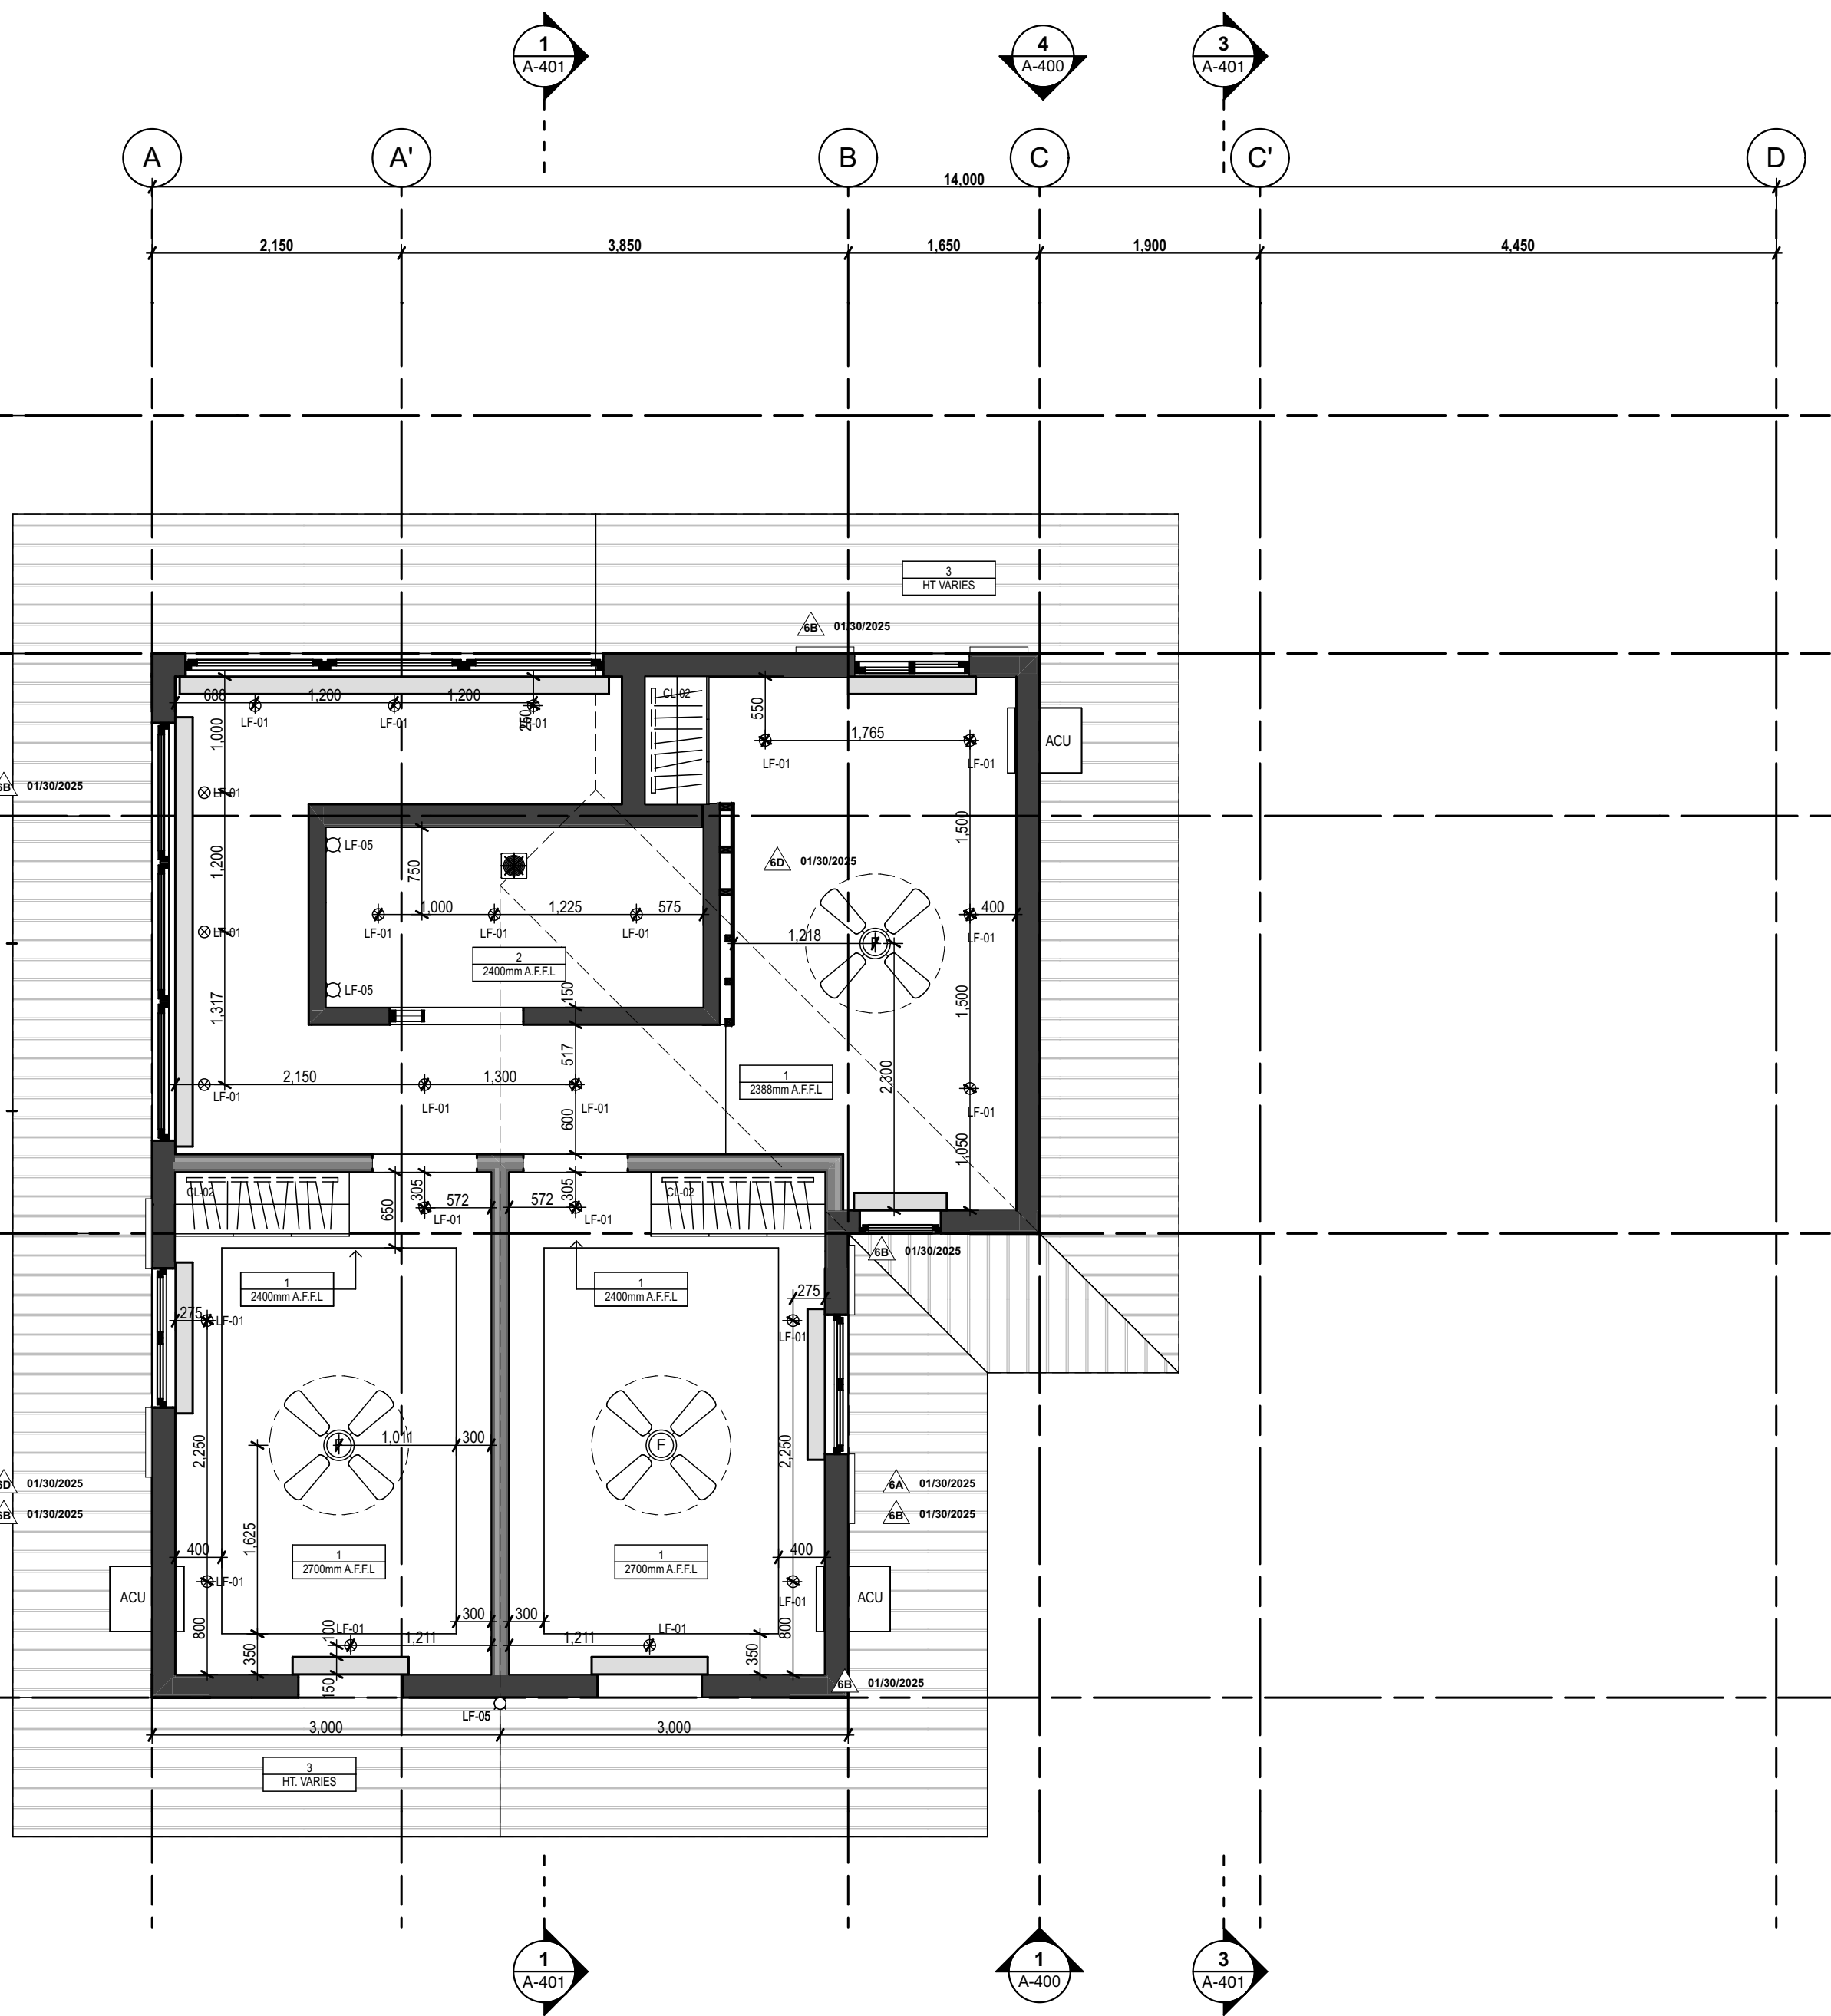

2 2/F REFLECTED CEILING PLAN
SCALE: 1:50

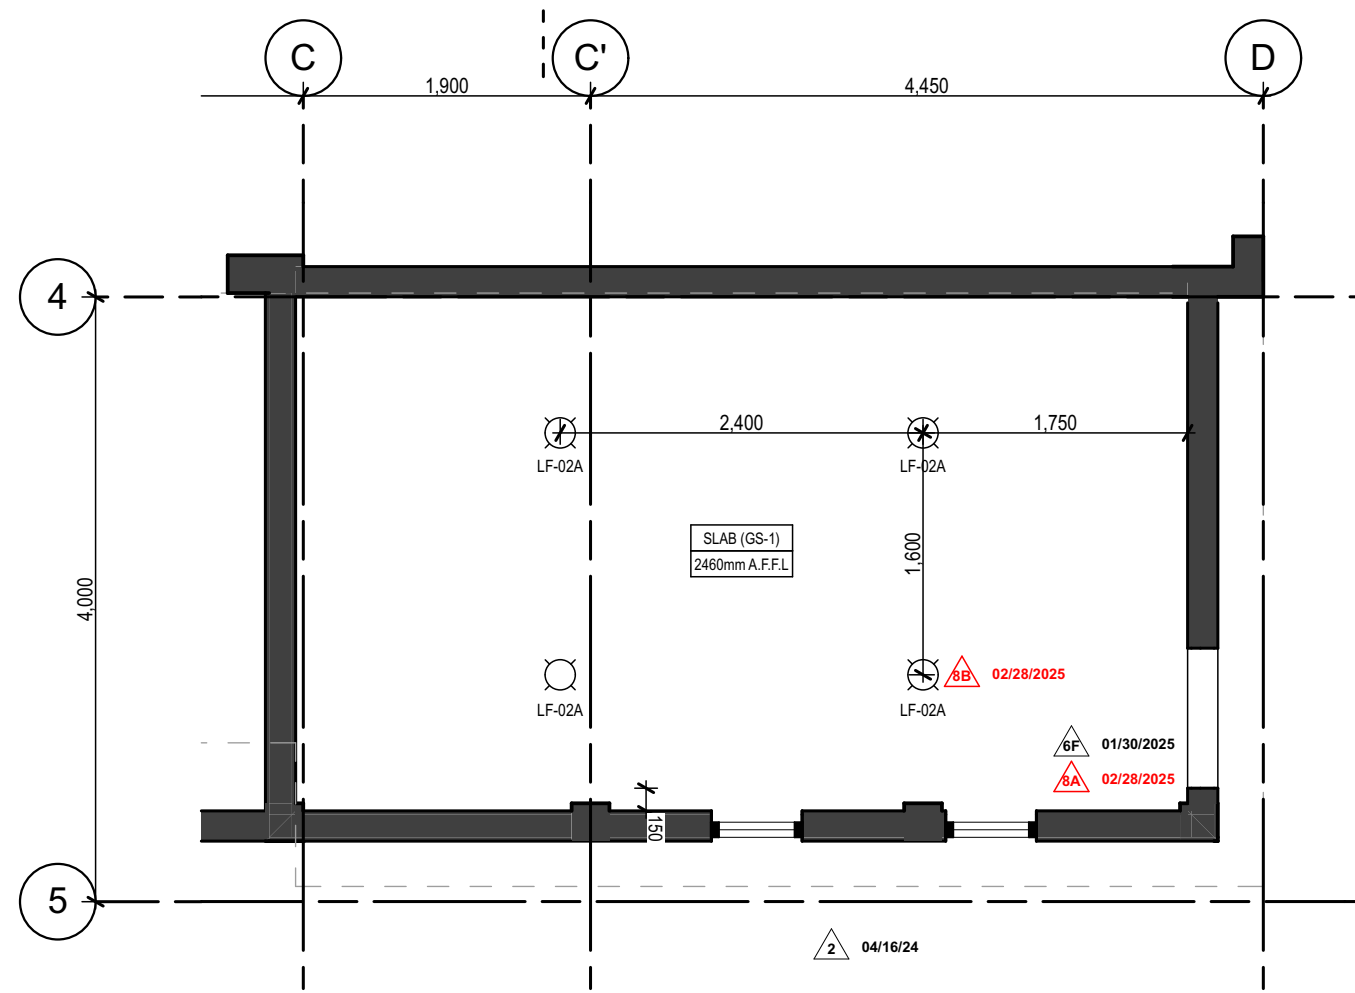

3 LOWER LEVEL STORAGE
SCALE: 1:50

LEGEND: CEILING FINISHES	
1	12mm Thk. Gypsum Ceiling on Light Gauge Metal Furring in Flat Latex Paint Finish: White
2	12mm Thk. Moisture Resistant Gypsum Ceiling on Light Gauge Metal Furring in Flat Latex Paint Finish: White
3	WPC in Wood Grain Finish
4	12mm Thk. Gypsum Cove Ceiling on Light Gauge Metal Furring in Flat Latex Paint Finish: Black

NOTE:
1) Verify actual height of bottom of beams.

LEGEND: LIGHT FIXTURES	
LF-01	Recessed Downlight Fixture: Size: 4" Ø Lamp: 6W LED
LF-02	Pendant Lighting Fixture: Size: For Approval Lamp: 12W LED
LF-02A	Pendant Lighting Fixture: Size: For Approval Lamp: 12W LED
LF-03	Pendant Lighting Fixture: Size: For Approval Lamp: 18W LED
LF-04	Surface Mounted Lighting Fixture: Size: For Approval Lamp: 12W LED
LF-05	Wall Mounted Lighting Fixture IP44 Size: For Approval Lamp: 6W LED
LF-06	Cove Lighting Fixture: Size: For Approval Lamp: LED Strip Light 14W per meter
LF-07	In-Ground Landscape Flood Lighting Fixture IP65 Size: For Approval Lamp: 25W LED
LF-08	Exterior Wall Mounted Light Fixture: Size: 31mm Ø Lamp: 6W LED
LF-09A	Track Mounted Spotlight Fixture: Size: For Approval Lamp: 7W LED
LF-09B	Track Mounted Spotlight Fixture: Size: For Approval Lamp: 7W LED
CL-01	Kitchen / T&B Cabinet Lighting Fixture: Size: For Approval Lamp: LED Strip Light 14W per meter
CL-02	Closest Lighting Fixture: Size: For Approval Lamp: LED Strip Light 5W per meter

ISSUES & REVISIONS		DATE
△	FOR PERMIT	AUGUST 9, 2023
△	FOR CONSTRUCTION	MARCH 21, 2024
△	FOR CONSTRUCTION	MARCH 25, 2024
△	CONSTRUCTION BULLETIN #1	MAY 07, 2024
△	CONSTRUCTION BULLETIN #2	NOVEMBER 14, 2024
△	FOR OWNER APPROVAL	JANUARY 30, 2025
△	CONSTRUCTION BULLETIN #3	FEBRUARY 20, 2025
△	OWNER APPROVED PLANS	FEBRUARY 28, 2025
△		
△		

REVISION NOTES	
MAY 07, 2024	FLIPPED PLANS AND ADDITION OF BASEMENT
NOVEMBER 14, 2024	5A- REFLECTED THE FLOOR FINISH DROP/ELEVATION ON FLOOR FINISH PLAN
	5B- PROVIDED ADDITIONAL STEP-UP FOR BASEMENT ENTRY
	5C- VERIFIED ELEVATIONS
JANUARY 30, 2025	6A- RELOCATED WINDOW & ACU ON 2/F BEDROOMS
	6B- ADDITION OF CURTAIN COVE AT EXTERIOR GLASS DOORS AND WINDOWS
	6C- EXTENSION OF COVE LIGHT AND ADDITION OF GENERAL LIGHTING AT LIVING AND DINING AREA
	6D- ADDED CEILING FAN ON 2/F STUDIO AND RELOCATED PIN LIGHT
	6E- STRIP LIGHTS ON TOP AND BOTTOM PANEL OF MEDICINE CABINET
	6F- ADDED A COVE LIGHT AND RELOCATION OF LIGHT AT BASEMENT
	6G- ADDITION OF LIGHTS
	6H- ADDITION OF CEILING FAN AT COMMON AREA
FEBRUARY 28, 2025	8A- REMOVAL OF COVE CEILING AND DRYSPUN CEILING AT BASEMENT
	8B- REPLACED PINLIGHTS AND COVE LIGHT AT BASEMENT WITH DROP LIGHTS
	8C- ADDITION OF PROVISION FOR WALL EXHAUST FAN AT SERVICE AREA



ARCHITECT:	
ARCH. MICHAEL FRANCIS C. OLIVERAS	
REG. NO. 0010272	DATE 01/03/2024
PTR NO. 1673420	LOCATION SAN JUAN CITY
NAPDA 15073 91545 042023	DATE 06/30/2024

OWNER REPRESENTATIVES :	
MR. JOSE C. LOPA	
MRS. ANNA L. LOPEZ	
MR. MICHAEL C. LOPA	
Lopa Farm Marilau Highway Sitio Mayagay, Brgy. Sampaloc, Tanay Rizal	

PROJECT TITLE :	
LOPA COMPOUND DEVELOPMENT	
Lopa Farm Marilau Highway Sitio Mayagay, Brgy. Sampaloc, Tanay Rizal	

SHEET CONTENTS :	
HOUSE 4	
REFLECTED CEILING PLAN	

SCALE: AS SHOWN	SHEET NO. :
DRAWN BY: ADI, JC, AC, MMT, RCA	A-200
CHECKED BY: MCO	
DATE: 02/20/2025	

ALL DESIGNS, PRINTS AND SPECIFICATIONS ARE THE PROPERTY OF FORO CONSULTING, INC. AND CANNOT BE USED WITHOUT THEIR WRITTEN PERMISSION. THE SAME SHALL BE RETURNED AT COMPLETION OF THE WORK. DO NOT SCALE DRAWINGS. ALL MEASUREMENTS MUST BE CHECKED AT THE SITE BY THE CONTRACTOR.



ISSUES & REVISIONS		DATE:
	FOR PERMIT	AUGUST 9, 2023
	FOR CONSTRUCTION	MARCH 21, 2024
	FOR CONSTRUCTION	MARCH 25, 2024
	CONSTRUCTION BULLETIN #1	MAY 07, 2024
	CONSTRUCTION BULLETIN #2	NOVEMBER 14, 2024
	FOR OWNER APPROVAL	JANUARY 30, 2025
	CONSTRUCTION BULLETIN #3	FEBRUARY 20, 2025
	OWNER APPROVED PLANS	FEBRUARY 28, 2025
		
		
REVISION NOTES		
MAY 07, 2024	FLIPPED PLANS AND ADDITION OF BASEMENT	
NOVEMBER 14, 2024	SA - REFLECTED THE FLOOR FINISH DROP/ELEVATION ON FLOOR FINISH PLAN	
	SB - PROVIDED ADDITIONAL STEP-UP FOR BASEMENT ENTRY	
	SC - VERIFIED ELEVATIONS	
 UNIT 2C, 299 P. GUEYARRA BLDG. 299 P. GUEYARRA ST. BOJ. LITTLE BAGUHO SAN JUAN CITY 1500 PHILIPPINES FORO CONSULTING, INC. architects designers ARCHITECT: ARCH. MICHAEL FRANCIS C. OLIVARES BEG. NO. 0010272 PTR NO. 1673420 IAPDA 15073 391545 063023 DATE 01/03/2024 LOCATION SAN JUAN CITY DATE 06/30/2024 OWNER REPRESENTATIVES : MR. JOSE C. LOPA MRS. ANNA L. LOPEZ MR. MICHAEL C. LOPA Lopa Farm Marilauw Highway Sitio Mayagay, Brgy. Sampaloc, Tanay Rizal PROJECT TITLE : LOPA COMPOUND DEVELOPMENT Lopa Farm Marilauw Highway Sitio Mayagay, Brgy. Sampaloc, Tanay Rizal SHEET CONTENTS : HOUSE 4 WALL SCHEDULE SCALE: DRAWN BY: CHECKED BY: DATE: REVISOR: AS SHOWN ADJ, JAC, AEC, NMT, BEA MCO 02/20/2025 SHEET NO.: A-300 ALL DESIGNS, PERMITS AND SPECIFICATIONS ARE THE PROPERTY OF FORO CONSULTING, INC. AND CANNOT BE USED WITHOUT THEIR WRITTEN PERMISSION. THE SAME SHALL BE RETURNED AT COMPLETION OF THE WORK. DO NOT SCALE DRAWINGS. ALL MEASUREMENTS MUST BE CHECKED AT THE SITE BY THE CONTRACTOR.		



REVISION NOTES	
MAY 07, 2024	FLIPPED PLANS AND ADDITION OF BASEMENT
NOVEMBER 14, 2024	SA - REFLECTED THE FLOOR FINISH DROP/ELEVATION ON FLOOR FINISH PLAN
	SB - PROVIDED ADDITIONAL STEP-UP FOR BASEMENT ENTRY
	SC - VERIFIED ELEVATIONS

ARCHITECT:			
ARCH. MICHAEL FRANCIS C. OLIVARES			
REG. NO.	0010772	DATE	01/03/2024
PTR NO.	1673420	LOCATION	SAN JUAN CITY
JAPDA	15073 391565 063023	DATE	06/30/2024

PROJECT TITLE :

**LOPA COMPOUND
DEVELOPMENT**

Lopa Farm Marilaua Highway Sitio Mayagay,
Brgy. Sampaloc, Tanay Rizal


SCALE :	AS SHOWN
DRAWN BY :	ADJ, JJK, AEC, MMT, BCA
CHECKED BY :	IMO
DATE :	02/20/2025
REVISED :	

SHEET NO : A-301


ALL DESIGNS, PRINTS AND SPECIFICATIONS ARE THE PROPERTY OF FORO CONSULTING, INC. AND CANNOT BE USED WITHOUT THEIR WRITTEN PERMISSION. THE SAME SHALL BE RETURNED AT COMPLETION OF THE WORK. DO NOT SCALE DRAWINGS, ALL MEASUREMENTS MUST BE CHECKED AT THE SITE BY THE CONTRACTOR.




1 FRONT ELEVATION
SCALE:1/50

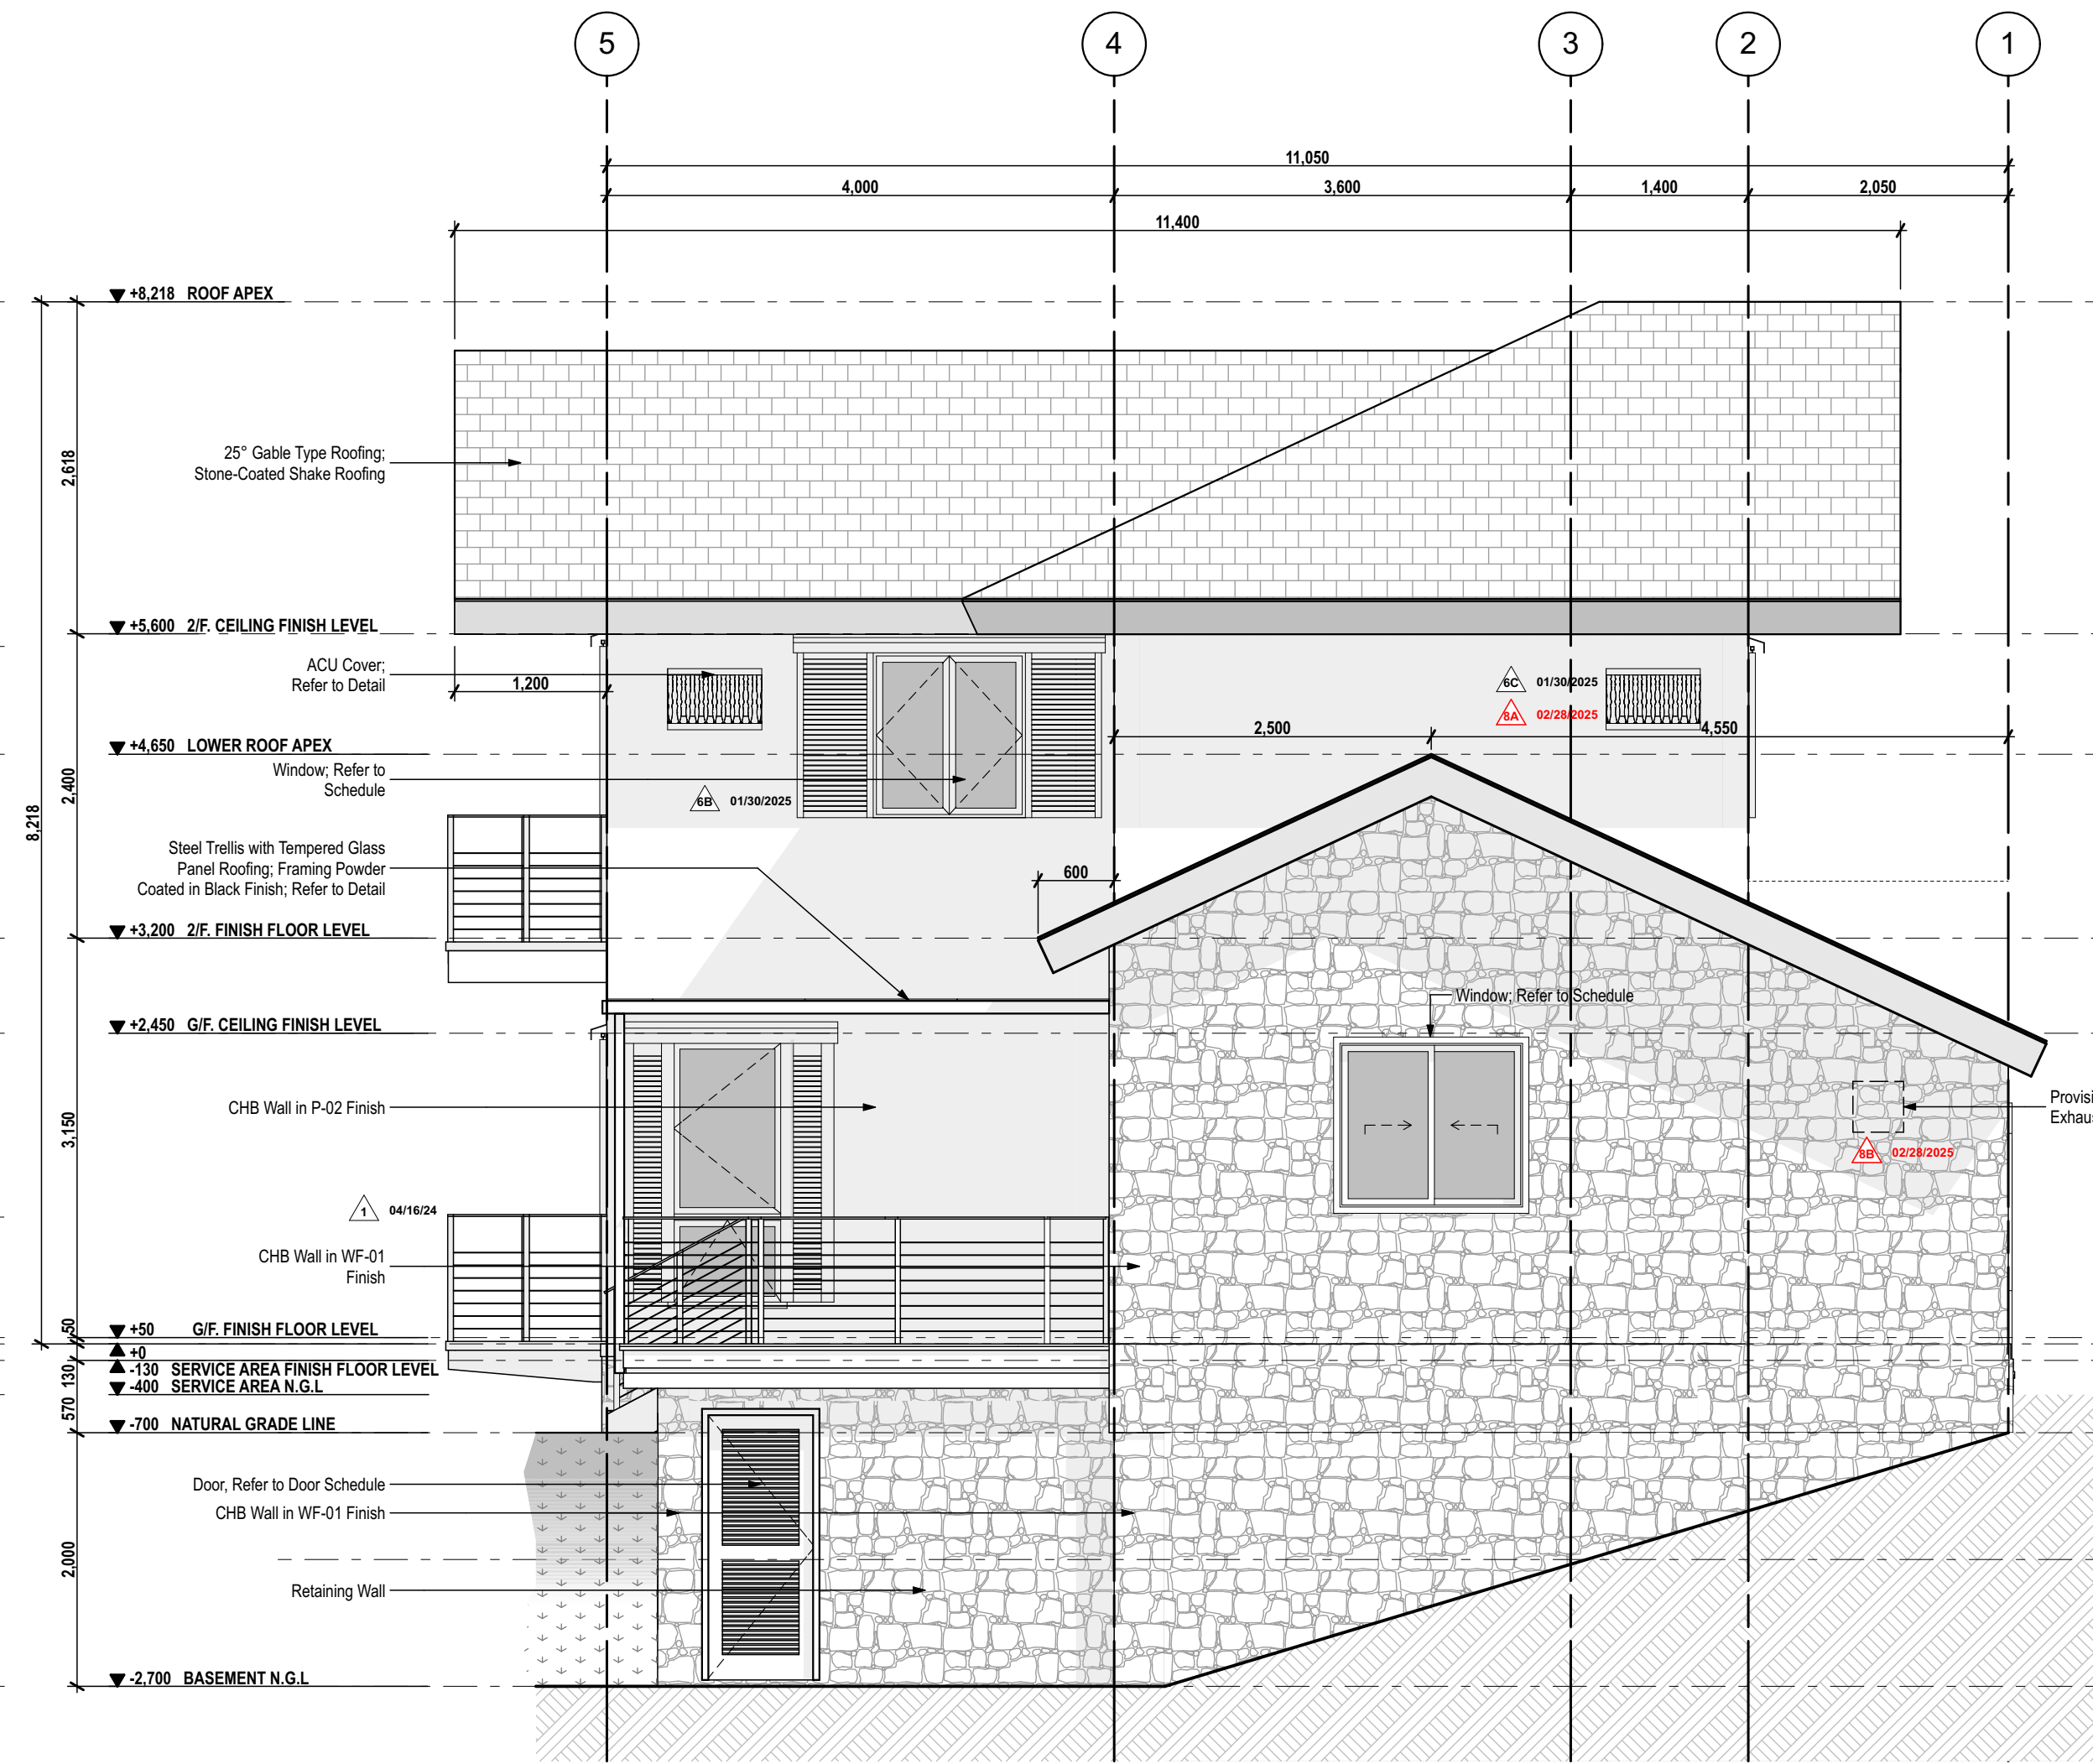

2 RIGHT SIDE ELEVATION
SCALE:1/50

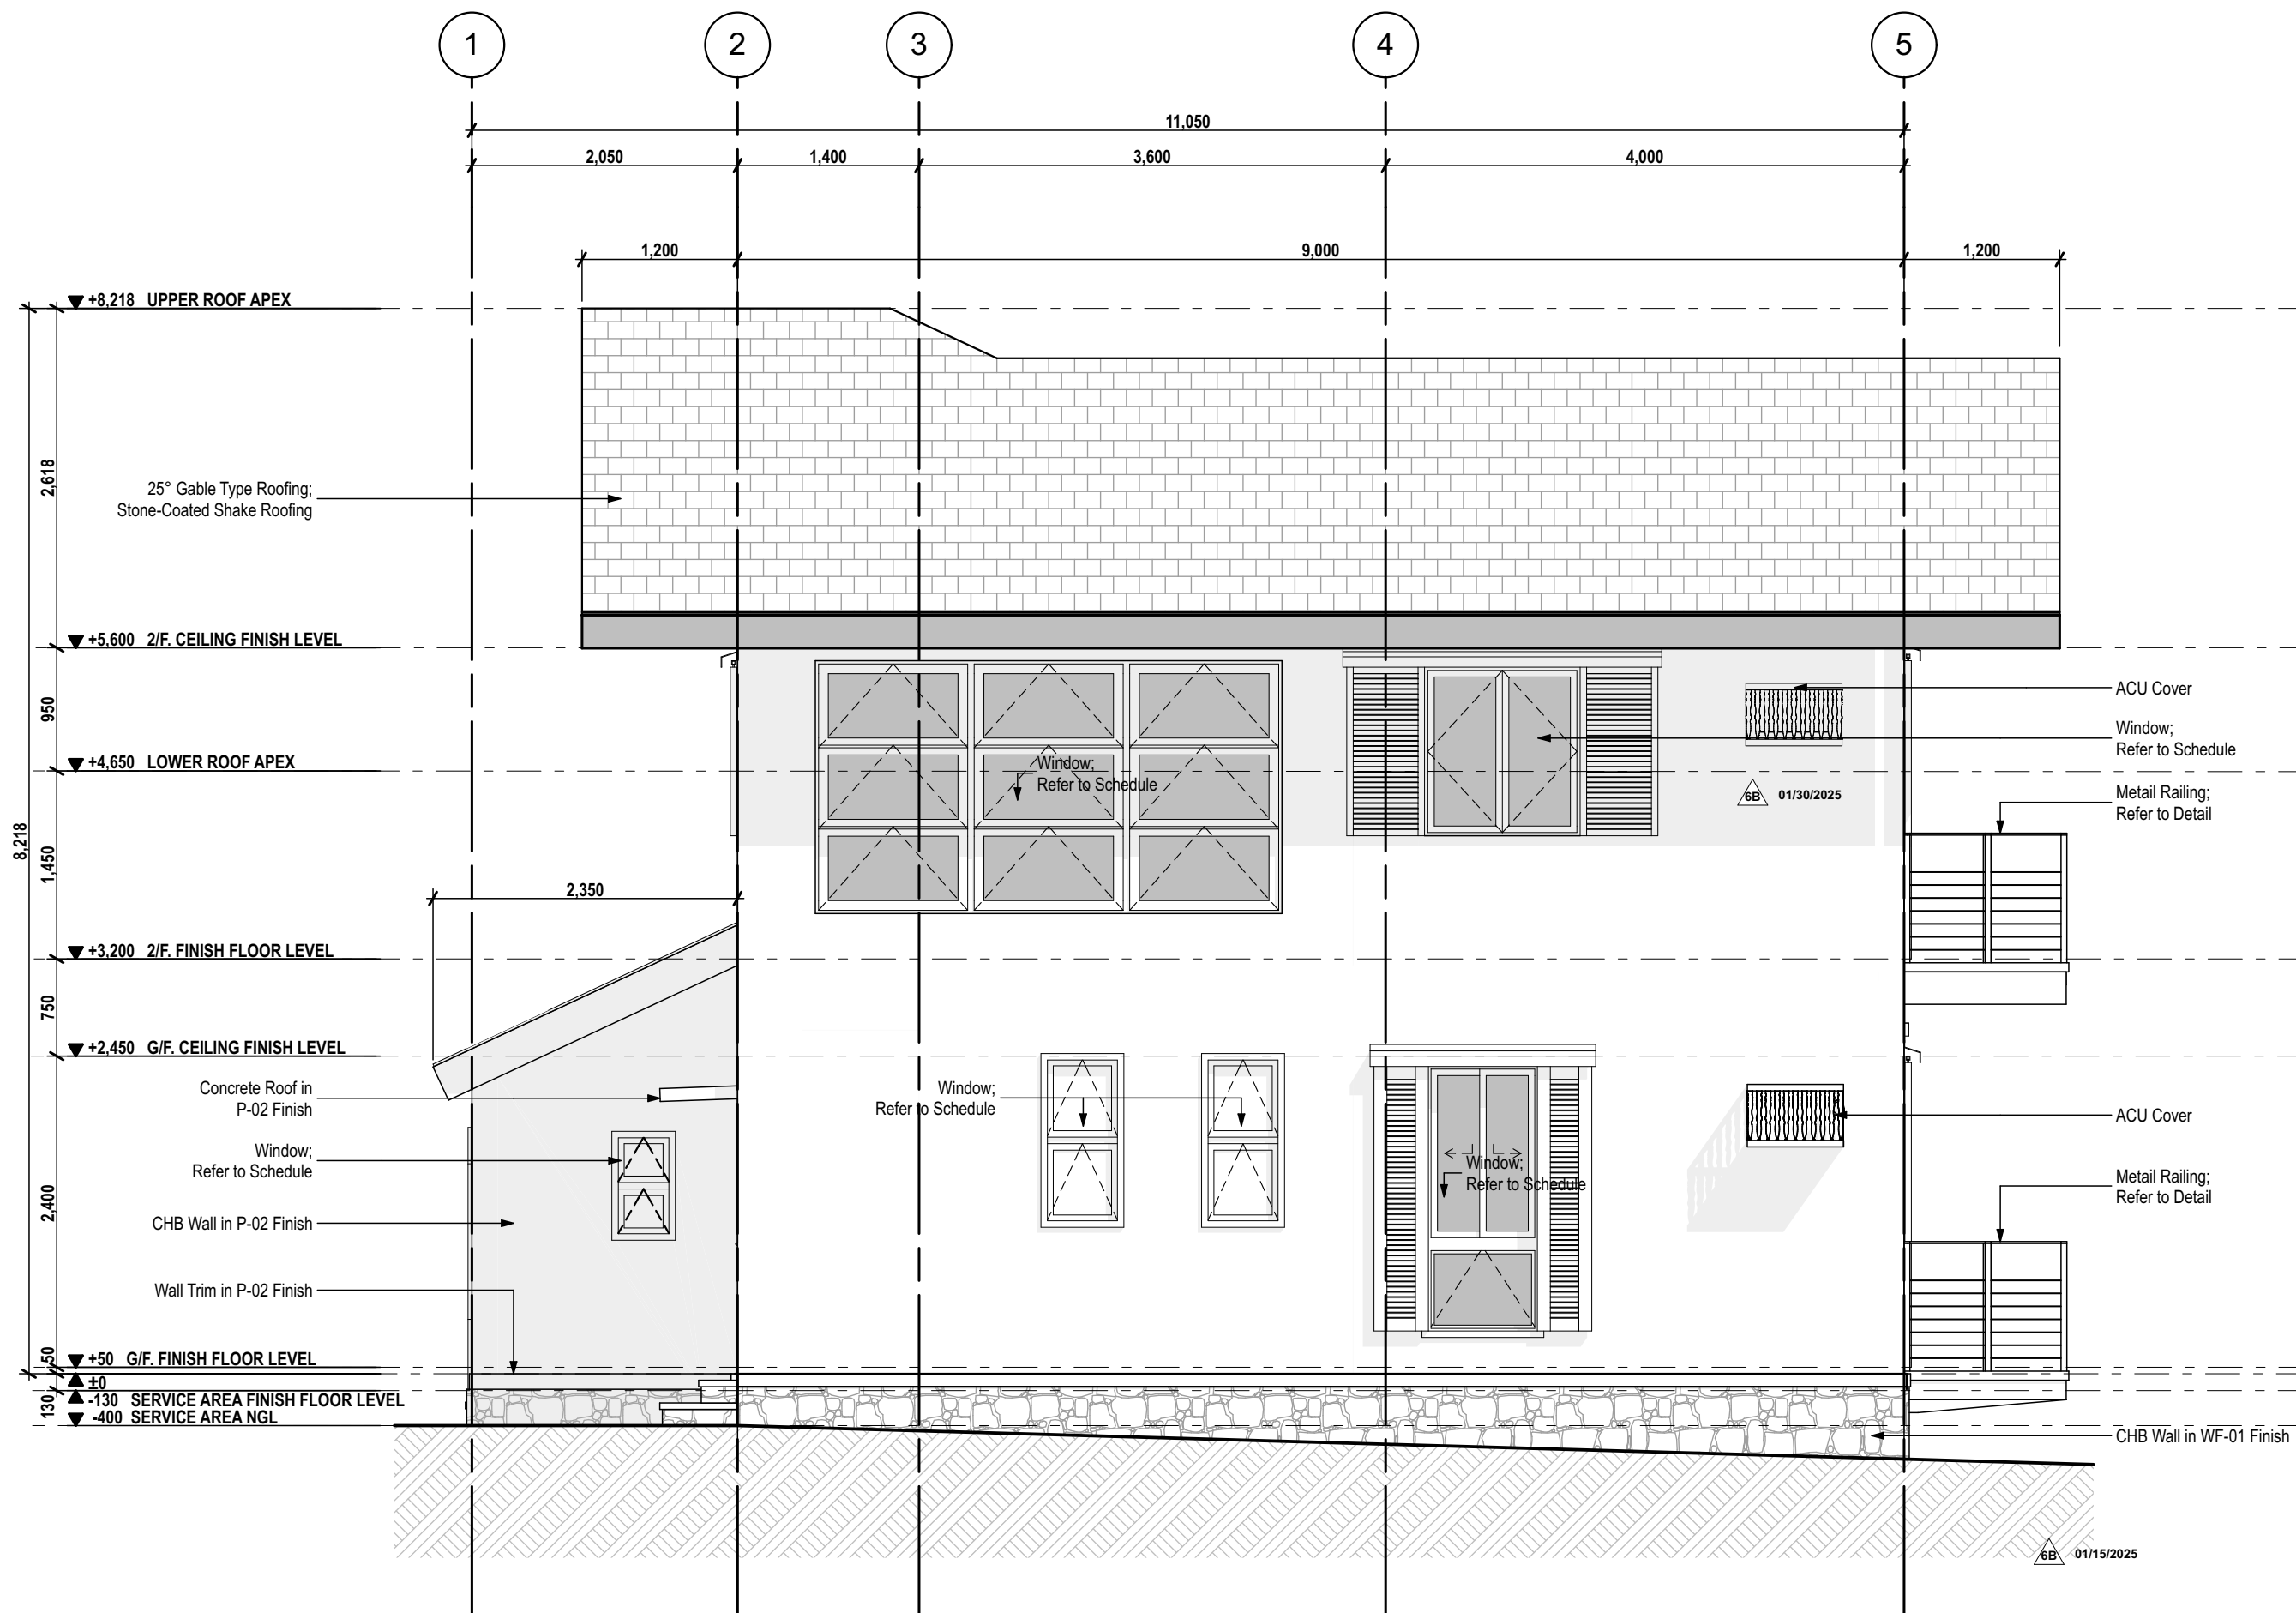

3 LEFT SIDE ELEVATION
SCALE:1/50

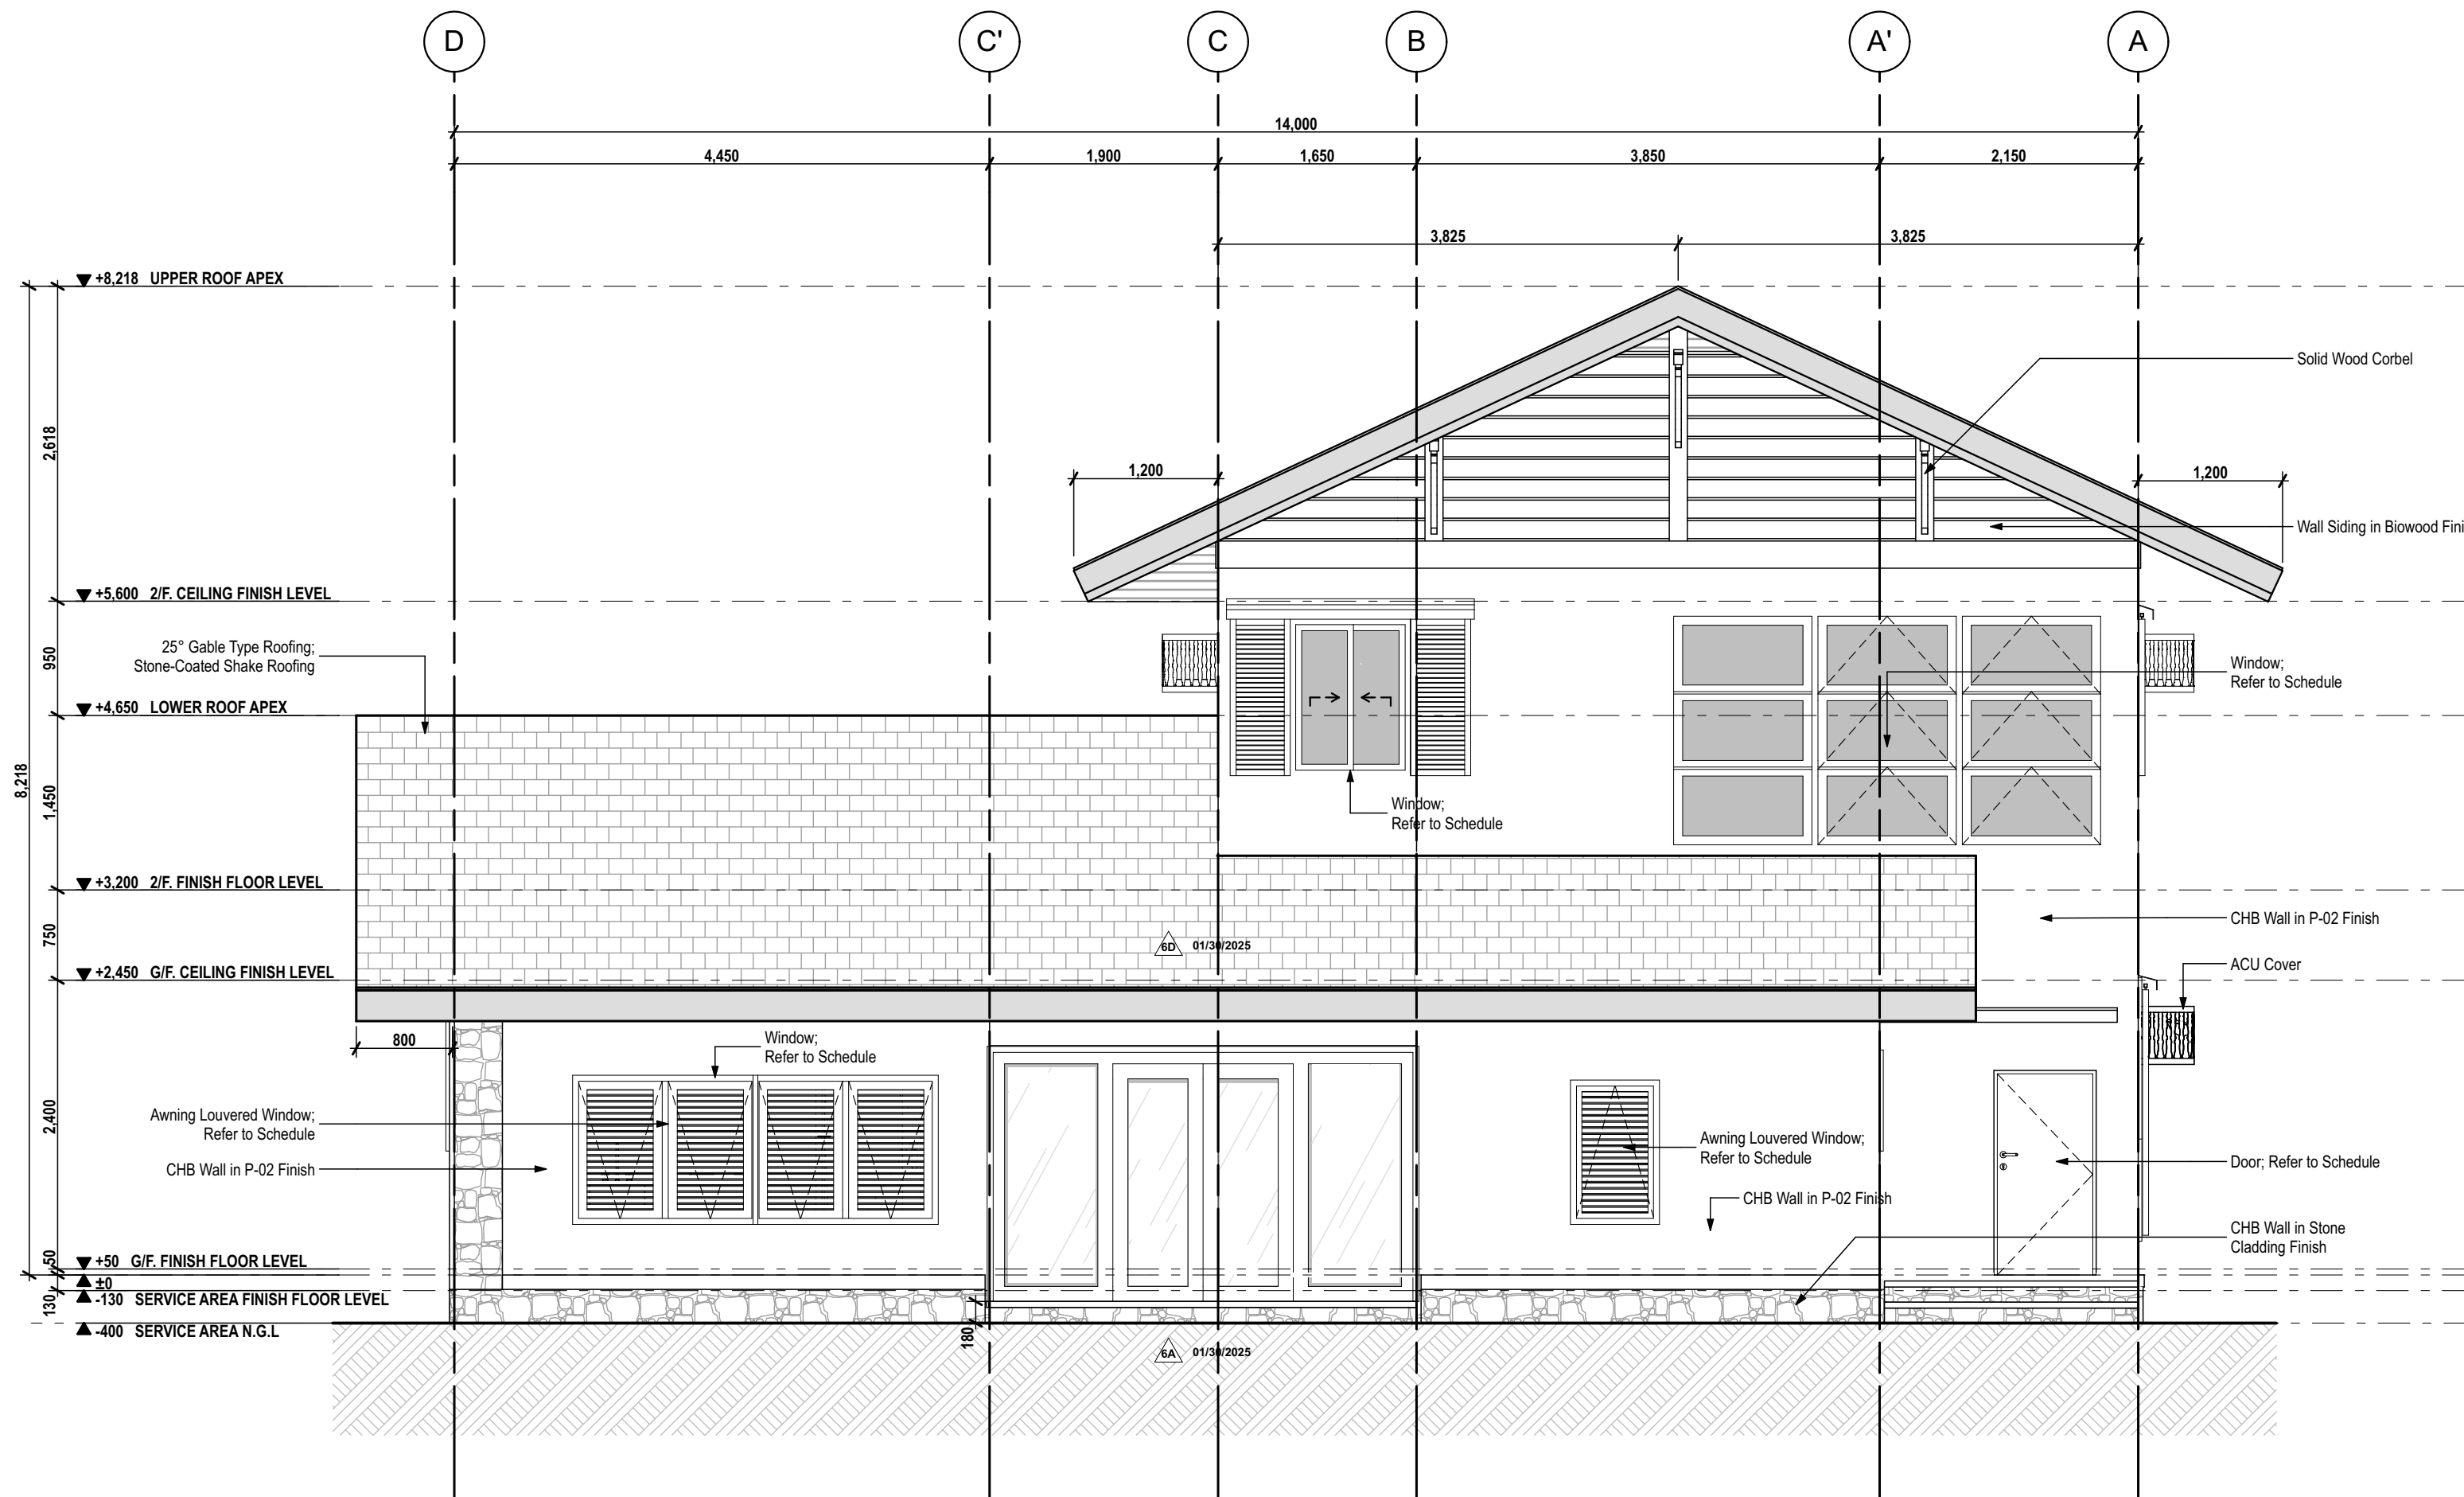

4 REAR ELEVATION
SCALE:1/50

NOTE:
The landscaping (including soil profile and driveway) shown in the current drawings are **preliminary and for illustrative purposes only**. The actual landscaping and land elevation will be determined and finalized separately by the **Bomanite team**.

ISSUES & REVISIONS		DATE:
FOR PERMIT		AUGUST 9, 2023
FOR CONSTRUCTION		MARCH 21, 2024
FOR CONSTRUCTION		MARCH 25, 2024
CONSTRUCTION BULLETIN #1		MAY 07, 2024
CONSTRUCTION BULLETIN #2		NOVEMBER 14, 2024
FOR OWNER APPROVAL		JANUARY 30, 2025
CONSTRUCTION BULLETIN #3		FEBRUARY 20, 2025
OWNER APPROVED PLANS		FEBRUARY 28, 2025

REVISION NOTES	
MAY 07, 2024	FLIPPED PLANS AND ADDITION OF BASEMENT
NOVEMBER 14, 2024	5A- REFLECTED THE FLOOR FINISH DROP/ELEVATION ON FLOOR FINISH PLAN
	5B- PROVIDED ADDITIONAL STEP-UP FOR BASEMENT ENTRY
	5C- VERIFIED ELEVATIONS
JANUARY 30, 2025	6A- PROVISION OF SLIDING GLASS DOOR AT SERVICE AREA
	6B- RELOCATED WINDOW & ACU ON 2/F BEDROOMS
	6C- ADDITION OF ACU AT STUDIO ROOM
	6D- EXTENSION OF ROOF AT SERVICE AREA
FEBRUARY 28, 2025	8A- RELOCATED THE AC POSITION AT STUDIO ROOM
	8B- PROVISION OF WALL EXHAUST FAN AT SERVICE AREA

UNIT 2C, 299 P. GUEVARA BLDG.
299 P. GUEVARA ST.
85C LITTLE BAGUIO
SAN JUAN CITY 1500
PHILIPPINES

foro
FORO CONSULTING, INC.
architects designers

ARCHITECT:
ARCH. MICHAEL FRANCIS C. OLIVARES
REG. NO. 0010272 DATE 01/03/2024
PTR NO. 1673420 LOCATION SAN JUAN CITY
NPOA 15073 391565 062025 DATE 06/30/2024

OWNER REPRESENTATIVES :

MR. JOSE C. LOPA

MRS. ANNA L. LOPEZ

MR. MICHAEL C. LOPA
Lopa Farm Marilau Highway Sitio Mayagay,
Brgy. Sampaloc, Tanay Rizal

PROJECT TITLE :

LOPA COMPOUND DEVELOPMENT
Lopa Farm Marilau Highway Sitio Mayagay,
Brgy. Sampaloc, Tanay Rizal


SHEET CONTENTS :

HOUSE 4


ELEVATIONS

SCALE:	AS SHOWN	SHEET NO.:
DRAWN BY:	ADI, JJC, ACC, MMT, BCA	A-400
CHECKED BY:	MCO	
DATE:	02/20/2025	
REVISED:		


ALL DESIGN, PRINTS AND SPECIFICATIONS ARE THE PROPERTY OF FORO CONSULTING, INC. AND CANNOT BE USED WITHOUT THEIR WRITTEN PERMISSION. THE SAME SHALL BE RETURNED AT COMPLETION OF THE WORK. DO NOT SCALE DRAWINGS. ALL MEASUREMENTS MUST BE CHECKED AT THE SITE BY THE CONTRACTOR.

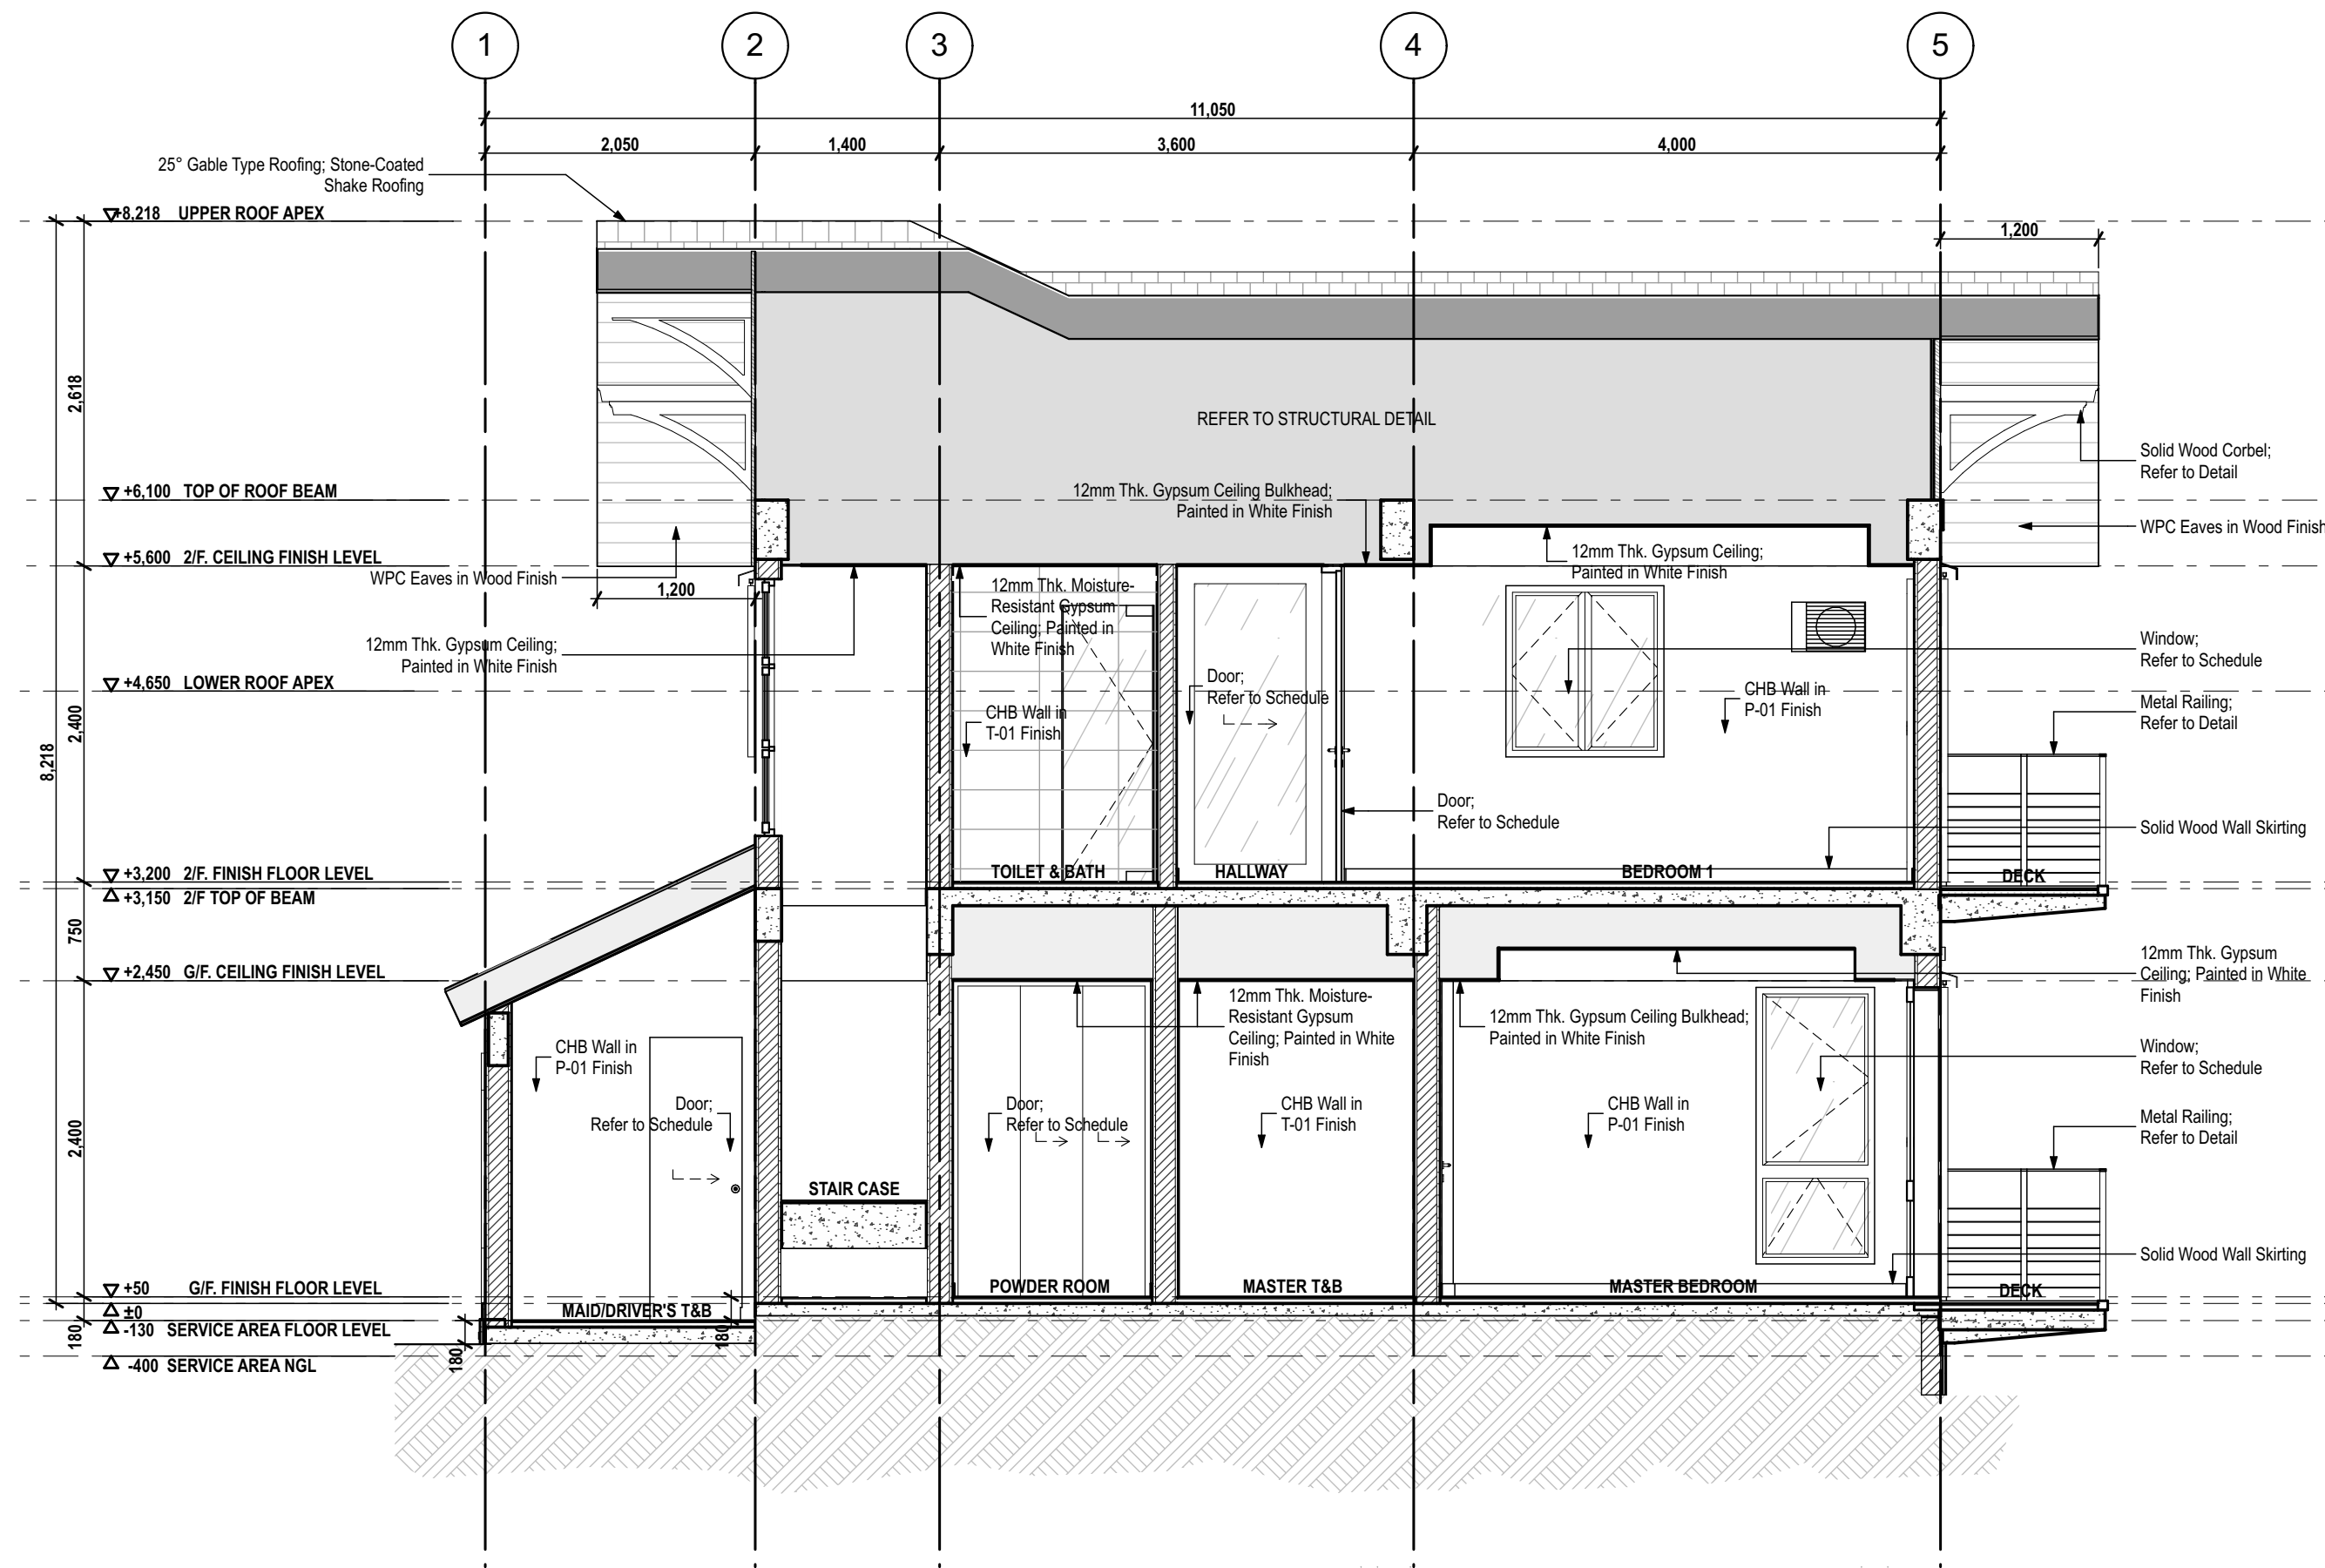


1
A-401
LONGITUDINAL SECTION A
SCALE 1:50

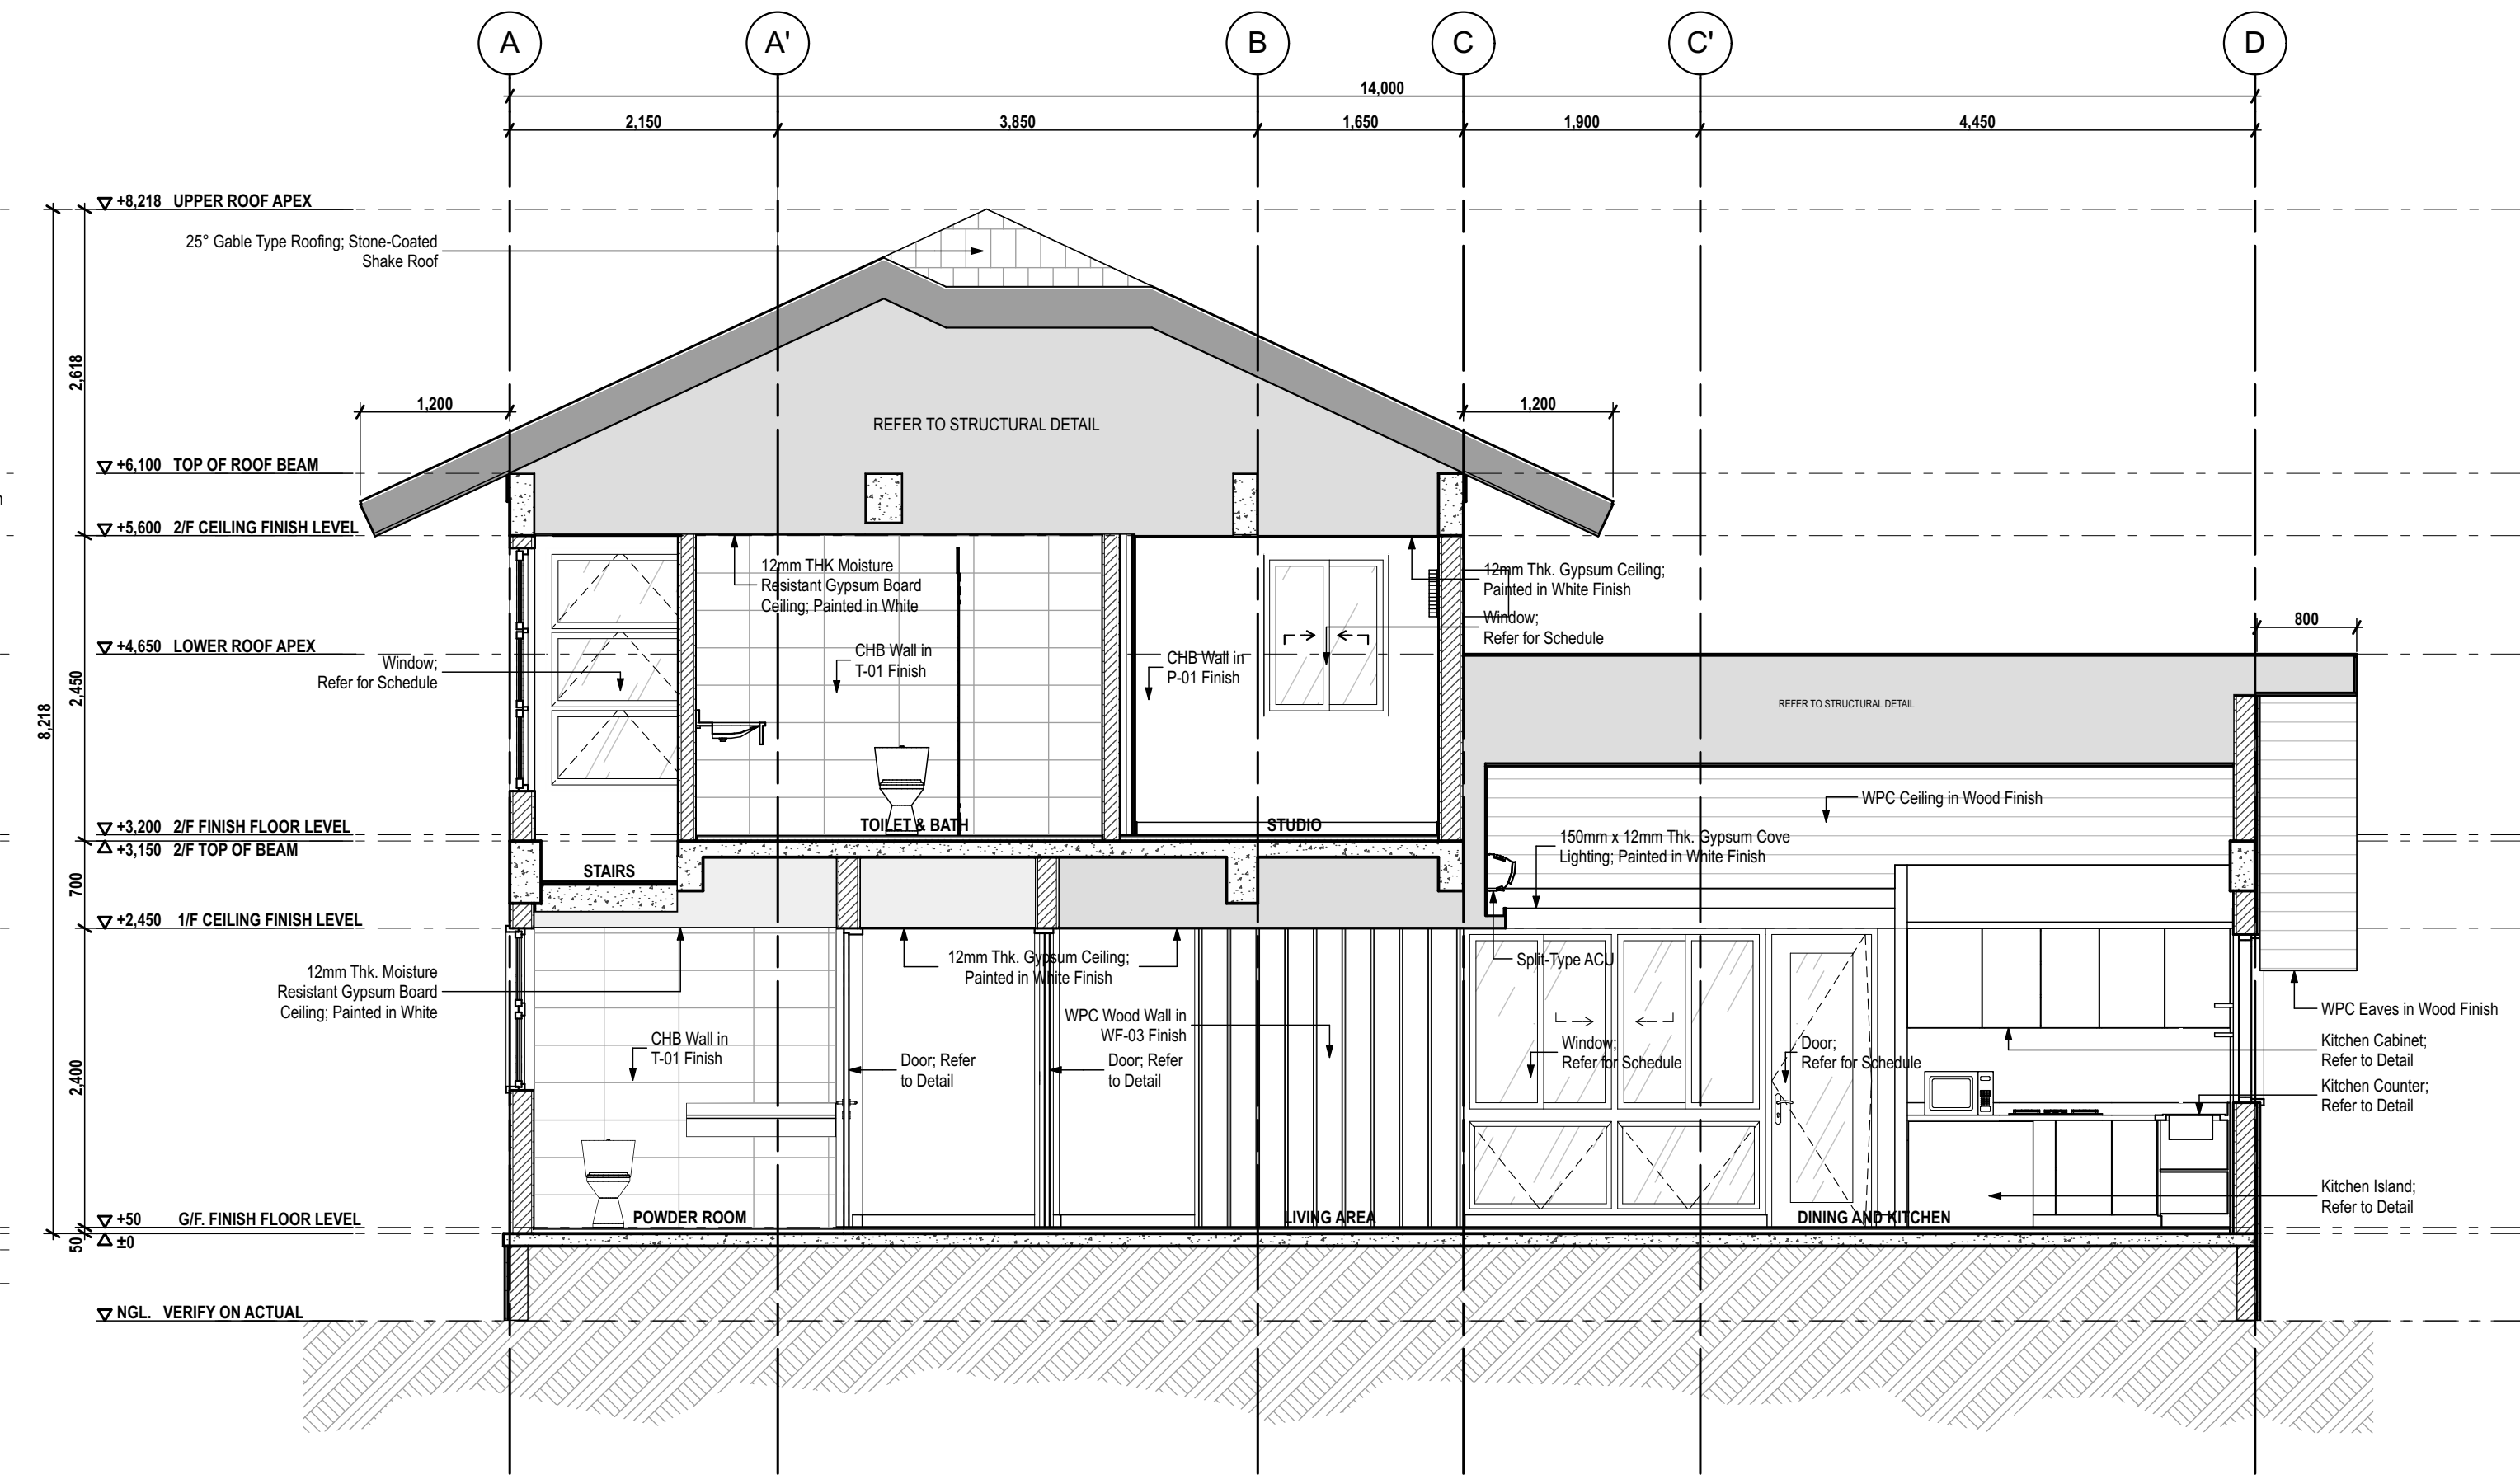

2
A-401
CROSS SECTION A
SCALE 1:50

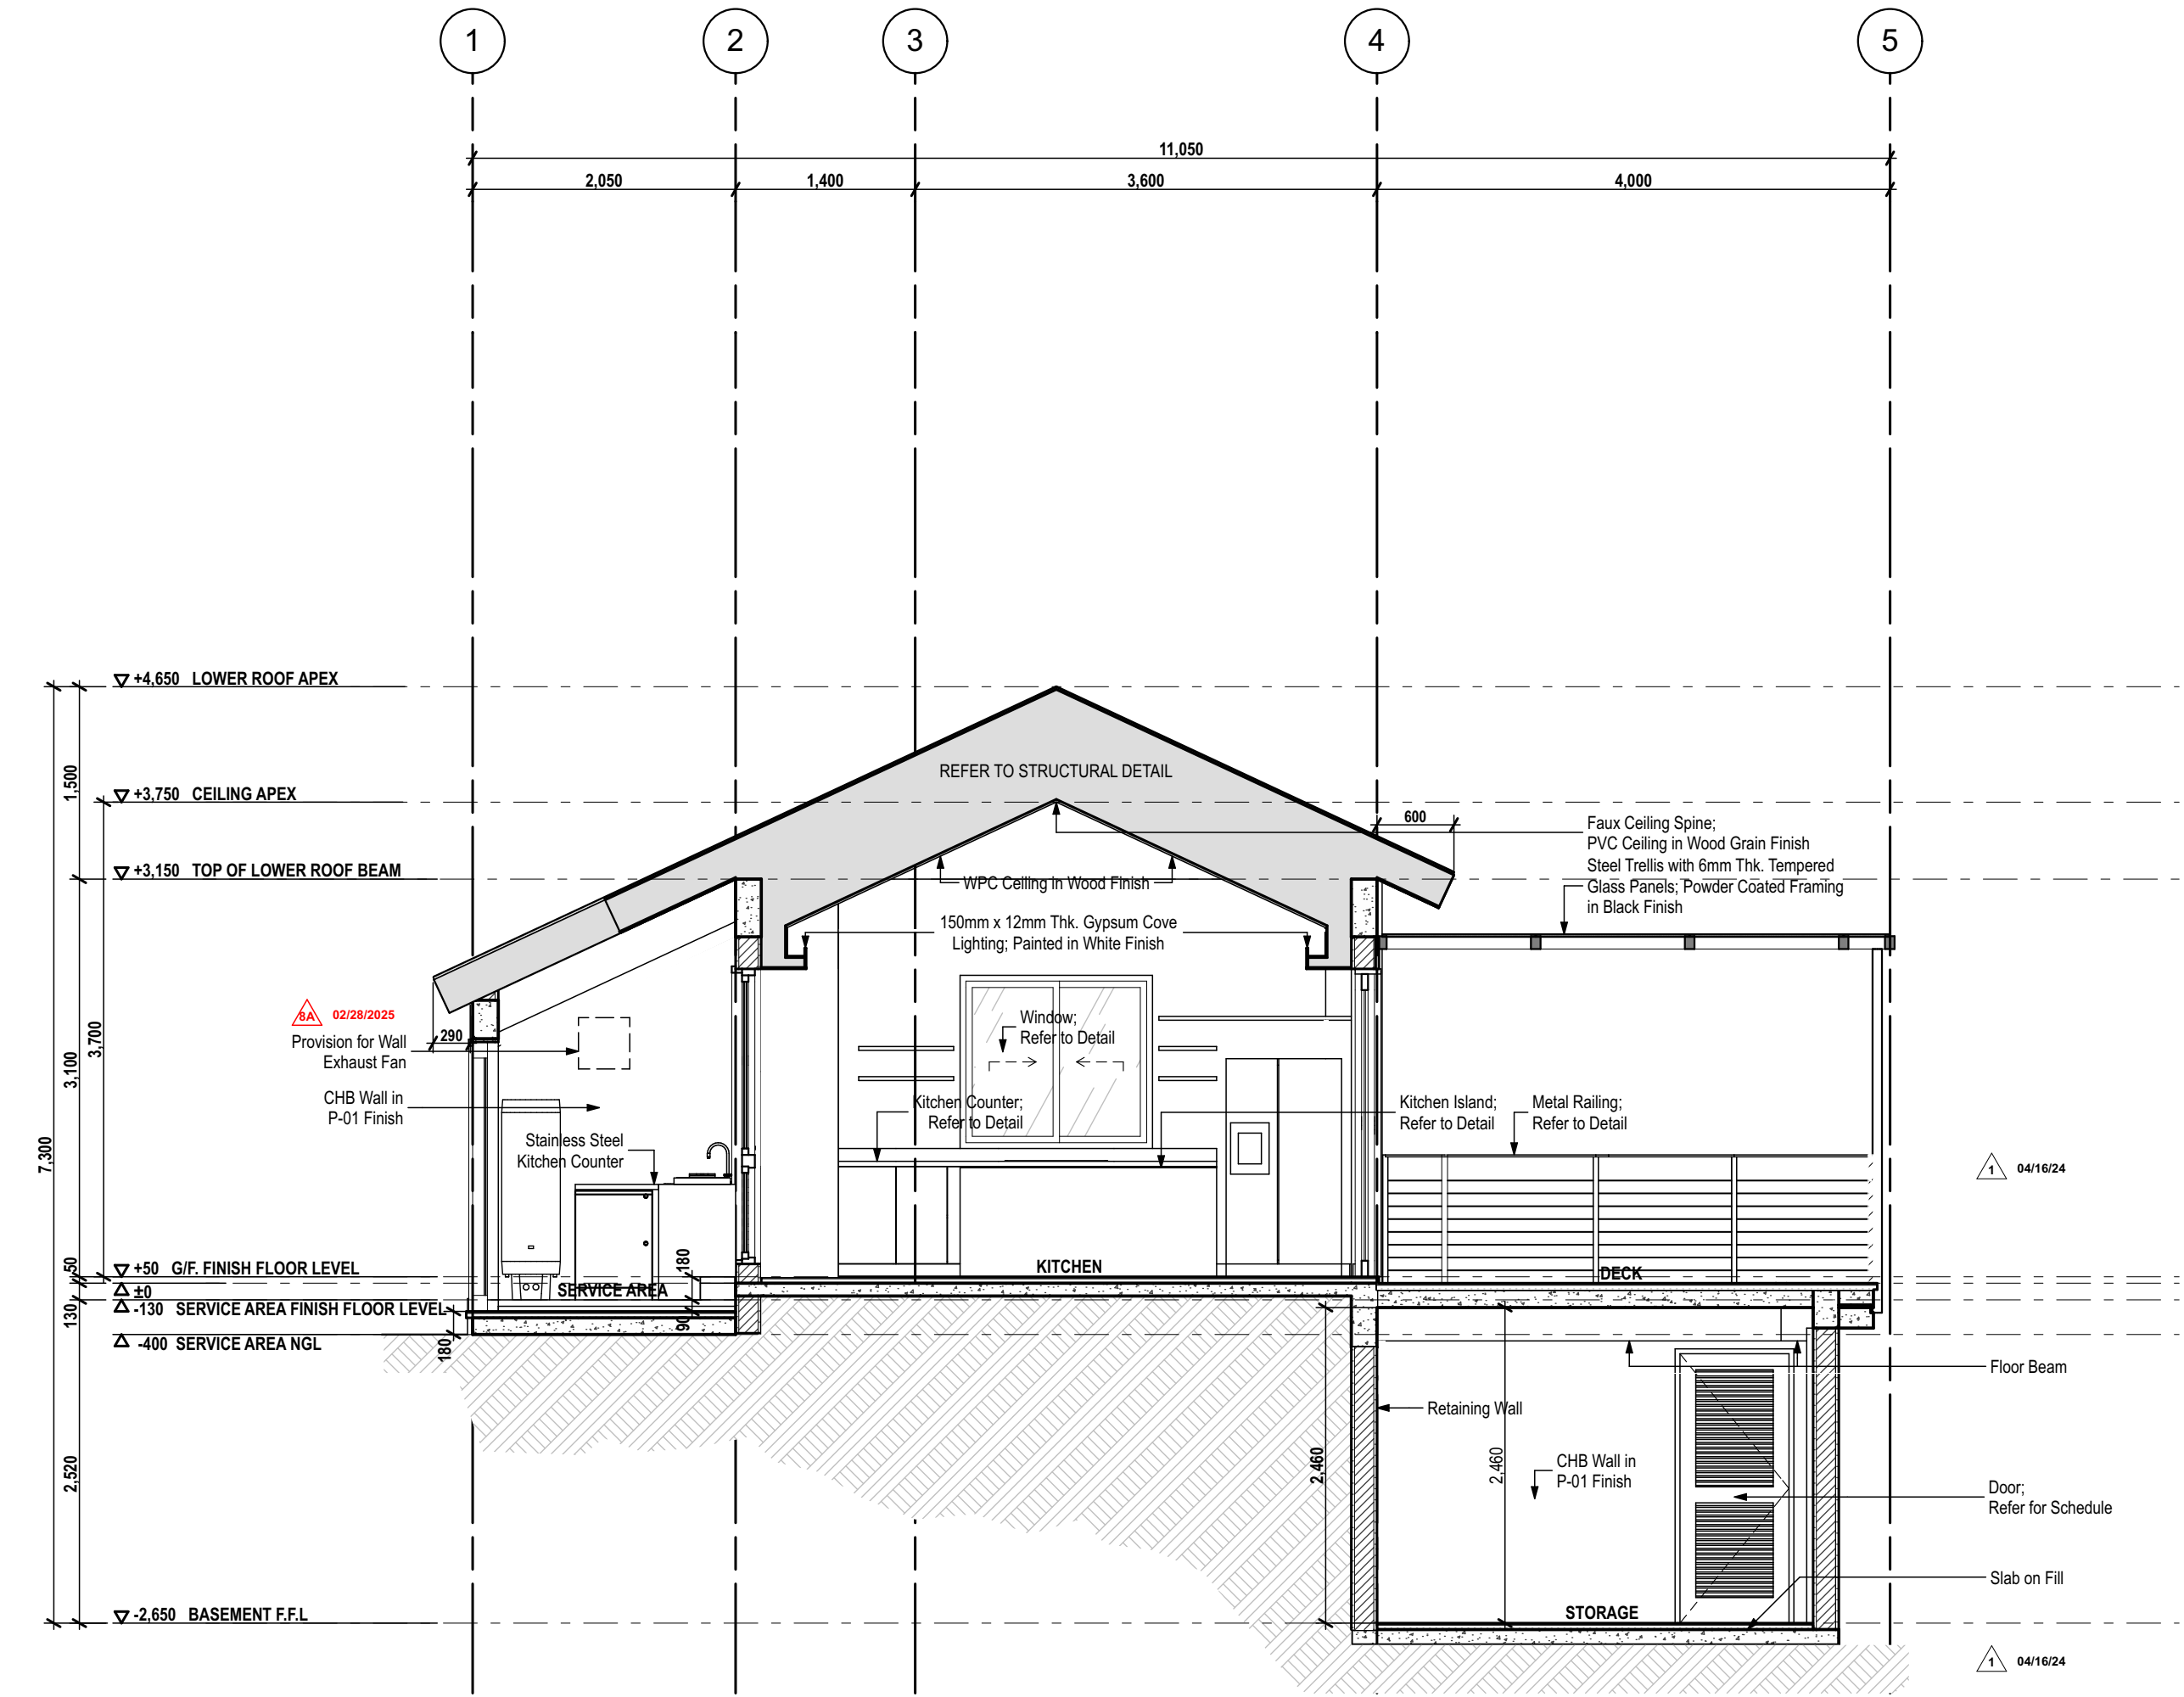

3
A-401
LONGITUDINAL SECTION B
SCALE 1:50

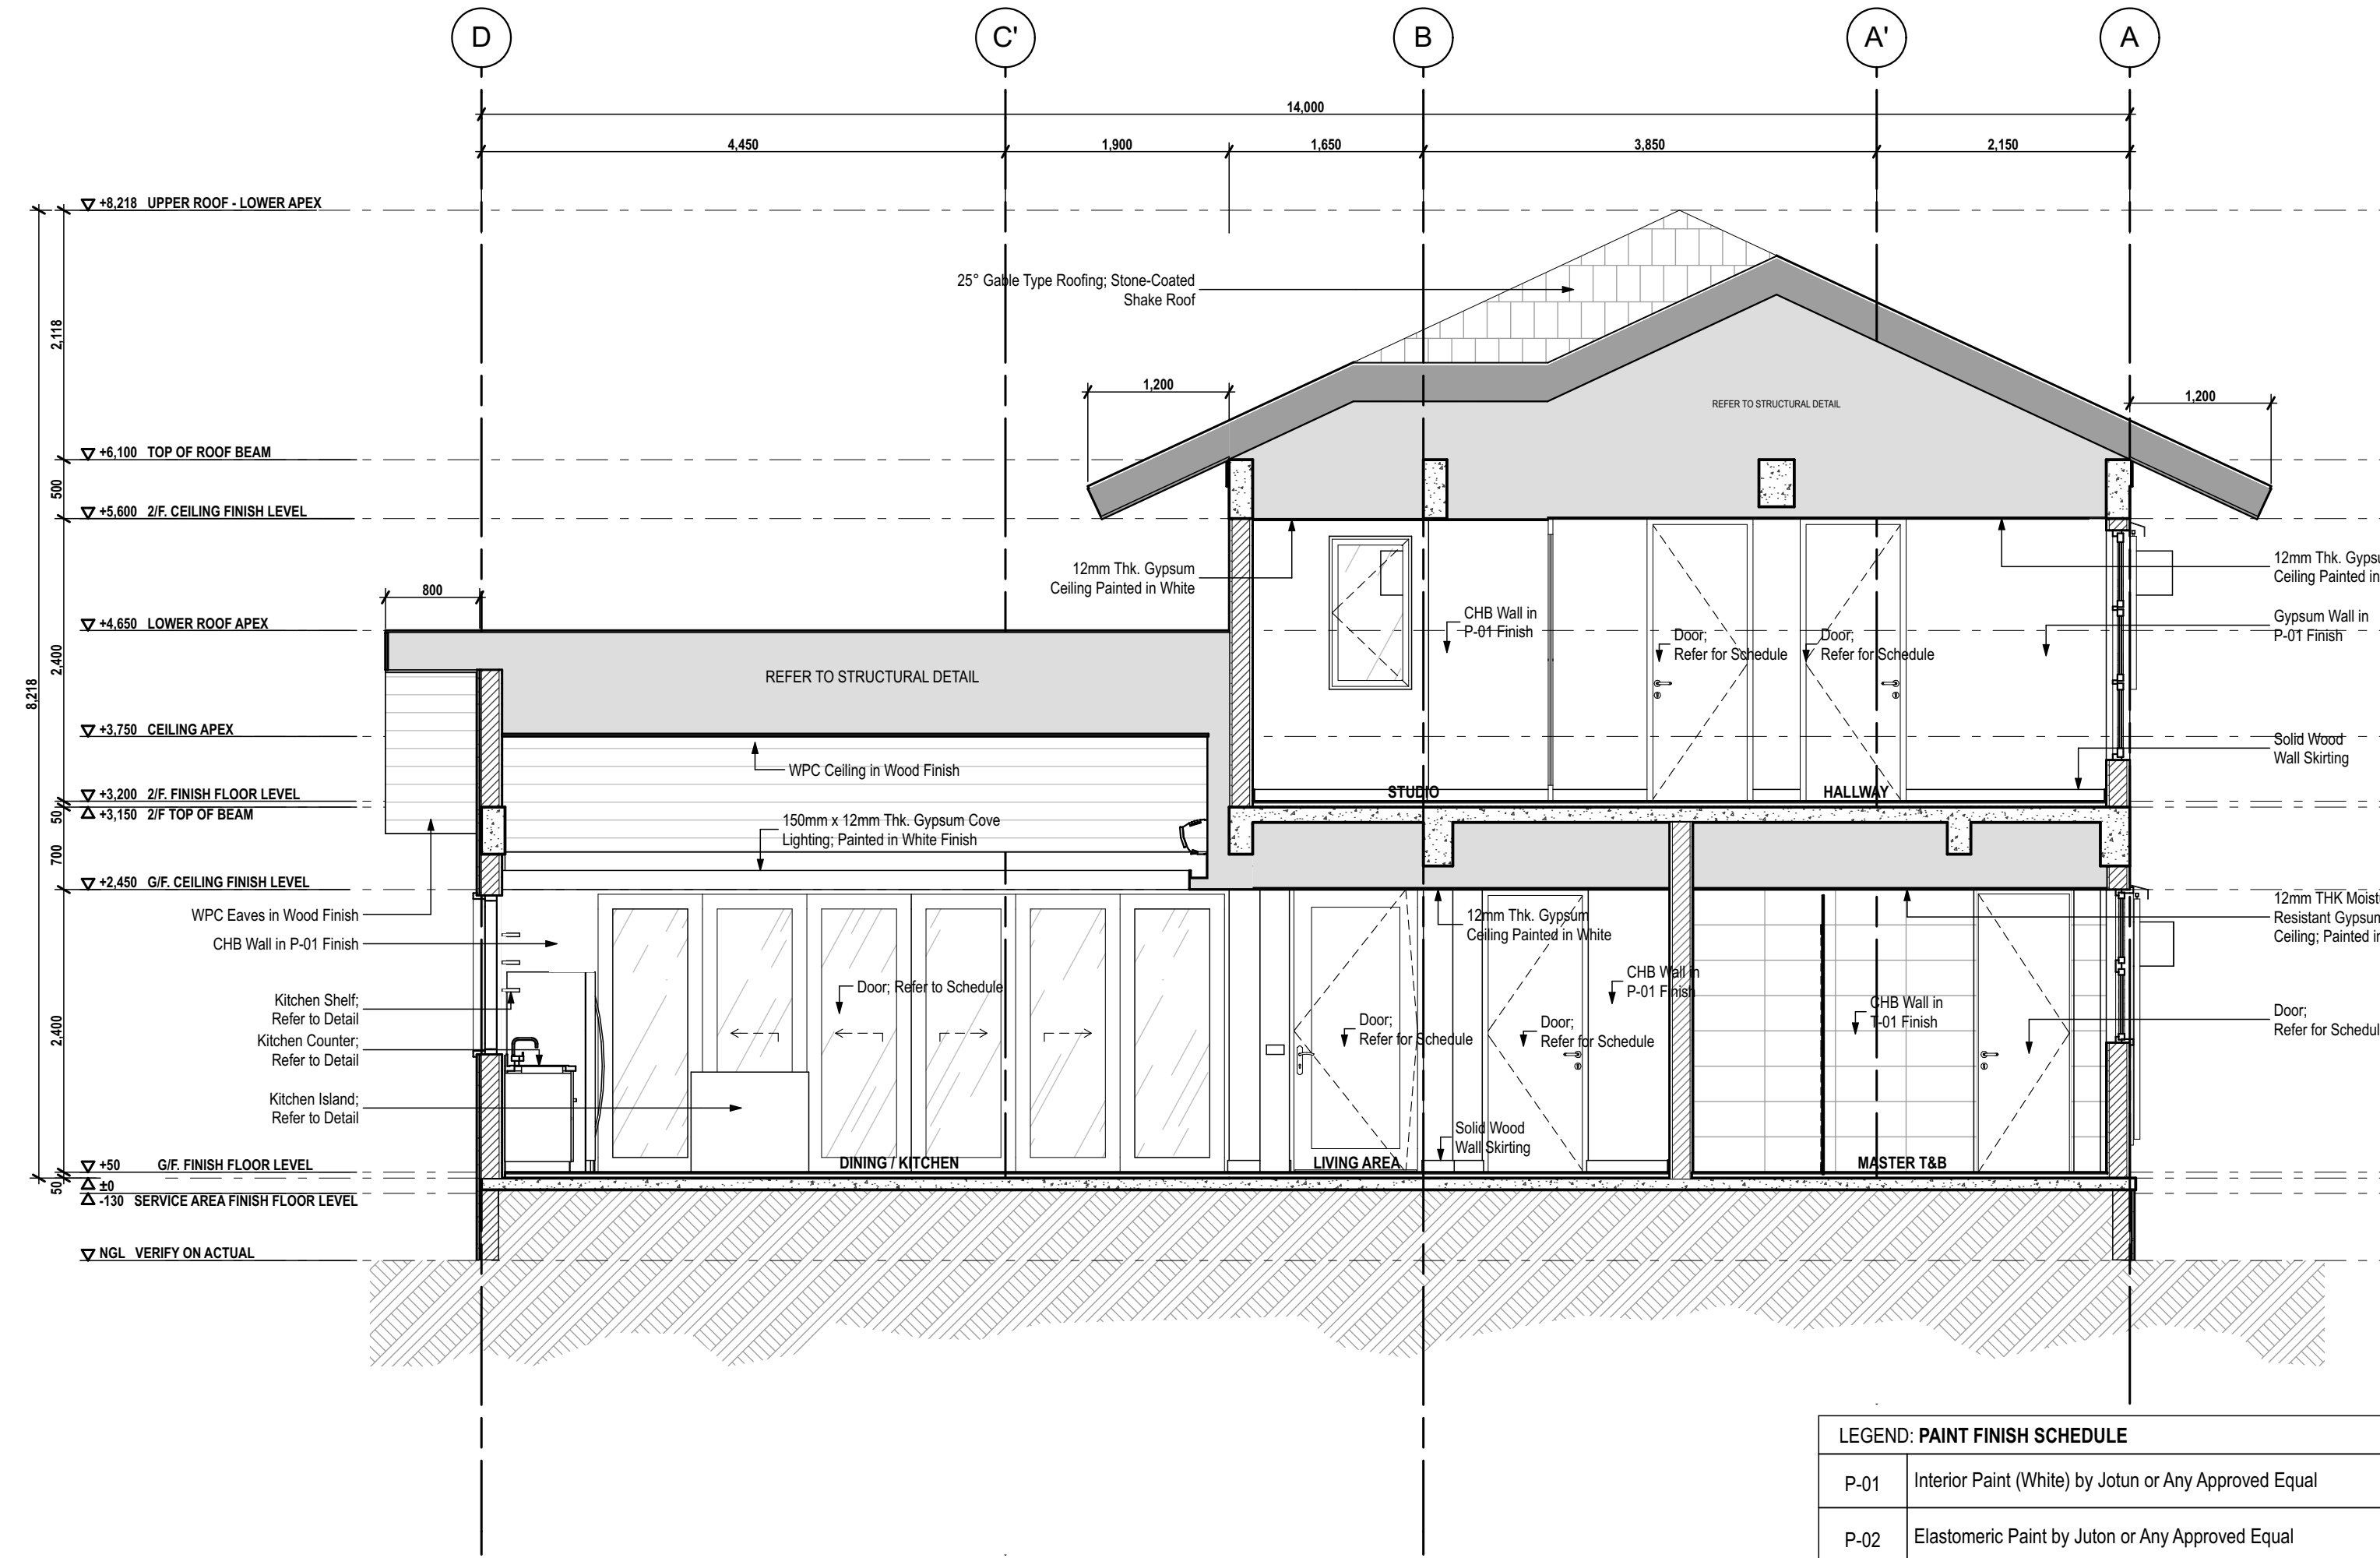

4
A-401
CROSS SECTION B
SCALE 1:50

NOTE:
The landscaping (including soil profile and driveway) shown in the current drawings are *preliminary and for illustrative purposes only*. The actual landscaping and land elevation will be determined and finalized separately by the *Bonamite* team.

LEGEND: PAINT FINISH SCHEDULE	
P-01	Interior Paint (White) by Juton or Any Approved Equal
P-02	Elastomeric Paint by Juton or Any Approved Equal
T-01	300mm x 600mm Porcelain Tile Finish
WF-01	Natural Stone Cladding
WF-02	WPC Exterior Wood Siding
WF-03	Painted Gypsum Wall Siding

ISSUES & REVISIONS		DATE
△	FOR PERMIT	AUGUST 9, 2023
△	FOR CONSTRUCTION	MARCH 21, 2024
△	FOR CONSTRUCTION	MARCH 25, 2024
△	CONSTRUCTION BULLETIN #1	MAY 07, 2024
△	CONSTRUCTION BULLETIN #2	NOVEMBER 14, 2024
△	FOR OWNER APPROVAL	JANUARY 30, 2025
△	CONSTRUCTION BULLETIN #3	FEBRUARY 20, 2025
△	OWNER APPROVED PLANS	FEBRUARY 28, 2025
△		
△		

REVISION NOTES	
MAY 07, 2024	FLIPPED PLANS AND ADDITION OF BASEMENT
NOVEMBER 14, 2024	5A - REFLECTED THE FLOOR FINISH DROP/ELEVATION ON FLOOR FINISH PLAN
	5B - PROVIDED ADDITIONAL STEP-UP FOR BASEMENT ENTRY
	5C - VERIFIED ELEVATIONS
JANUARY 30, 2025	6A - RELAY-OUT OF KITCHEN SINK AND STOVE AT MAIN KITCHEN AREA
	6B - RELAY-OUT OF KITCHEN SINK AT SERVICE AREA
	6C - PROVISION OF SLIDING GLASS DOOR AT SERVICE AREA
	6D - RELOCATED WINDOW & ACU ON 2/F BEDROOMS
	6E - RELAY-OUT OF TOILET AT 2/F AND ADDITION OF LAVATORY
	6F - ADDITION OF ACU AT STUDIO ROOM
	6G - ADDITION OF LAVATORY AT BASEMENT
	6I - ADDITION OF CURTAIN COVE AT EXTERIOR GLASS DOORS AND WINDOWS
	6J - EXTENSION OF COVE LIGHT AND ADDITION OF GENERAL LIGHTING AT LIVING AND DINING AREA
	6K - ADDED CEILING FAN ON 2/F STUDIO AND RELOCATED PIN LIGHT
	6M - ADDED A COVE LIGHT AND RELOCATION OF LIGHT AT BASEMENT
FEBRUARY 28, 2025	8A - PROVISION OF WALL EXHAUST FAN AT SERVICE AREA

UNIT 2C, 299 P. GUEVARA BLDG.
299 P. GUEVARA ST.
863 LITTLE BAGUIO
SAN JUAN CITY 1500
PHILIPPINES

foro
CONSULTING, INC.
architects designers

ARCHITECT:
ARCH. MICHAEL FRANCIS C. OLIVARES
REG. NO. 0010272 DATE 01/03/2024
PTR NO. 1673420 LOCATION SAN JUAN CITY
NPOA 15073 91545 063023 DATE 06/30/2024


OWNER REPRESENTATIVES :
MR. JOSE C. LOPA
MRS. ANNA L. LOPEZ
MR. MICHAEL C. LOPA
Lopa Farm Marilau Highway Sitio Mayagay,
Brgy. Sampaloc, Tanay Rizal

PROJECT TITLE :
LOPA COMPOUND DEVELOPMENT
Lopa Farm Marilau Highway Sitio Mayagay,
Brgy. Sampaloc, Tanay Rizal


SHEET CONTENTS :
HOUSE 4
SECTIONS

SCALE:	AS SHOWN	SHEET NO.:
DRAWN BY:	ADI, JC, AC, MMT, RCA	
CHECKED BY:	MCO	
DATE:	02/20/2025	
REVISED:		
		A-401


ALL DESIGN, PRINTS AND SPECIFICATIONS ARE THE PROPERTY OF FORO CONSULTING, INC. AND CANNOT BE USED WITHOUT THEIR WRITTEN PERMISSION. THE SAME SHALL BE RETURNED AT COMPLETION OF THE WORK. DO NOT SCALE DRAWINGS. ALL MEASUREMENTS MUST BE CHECKED AT THE SITE BY THE CONTRACTOR.

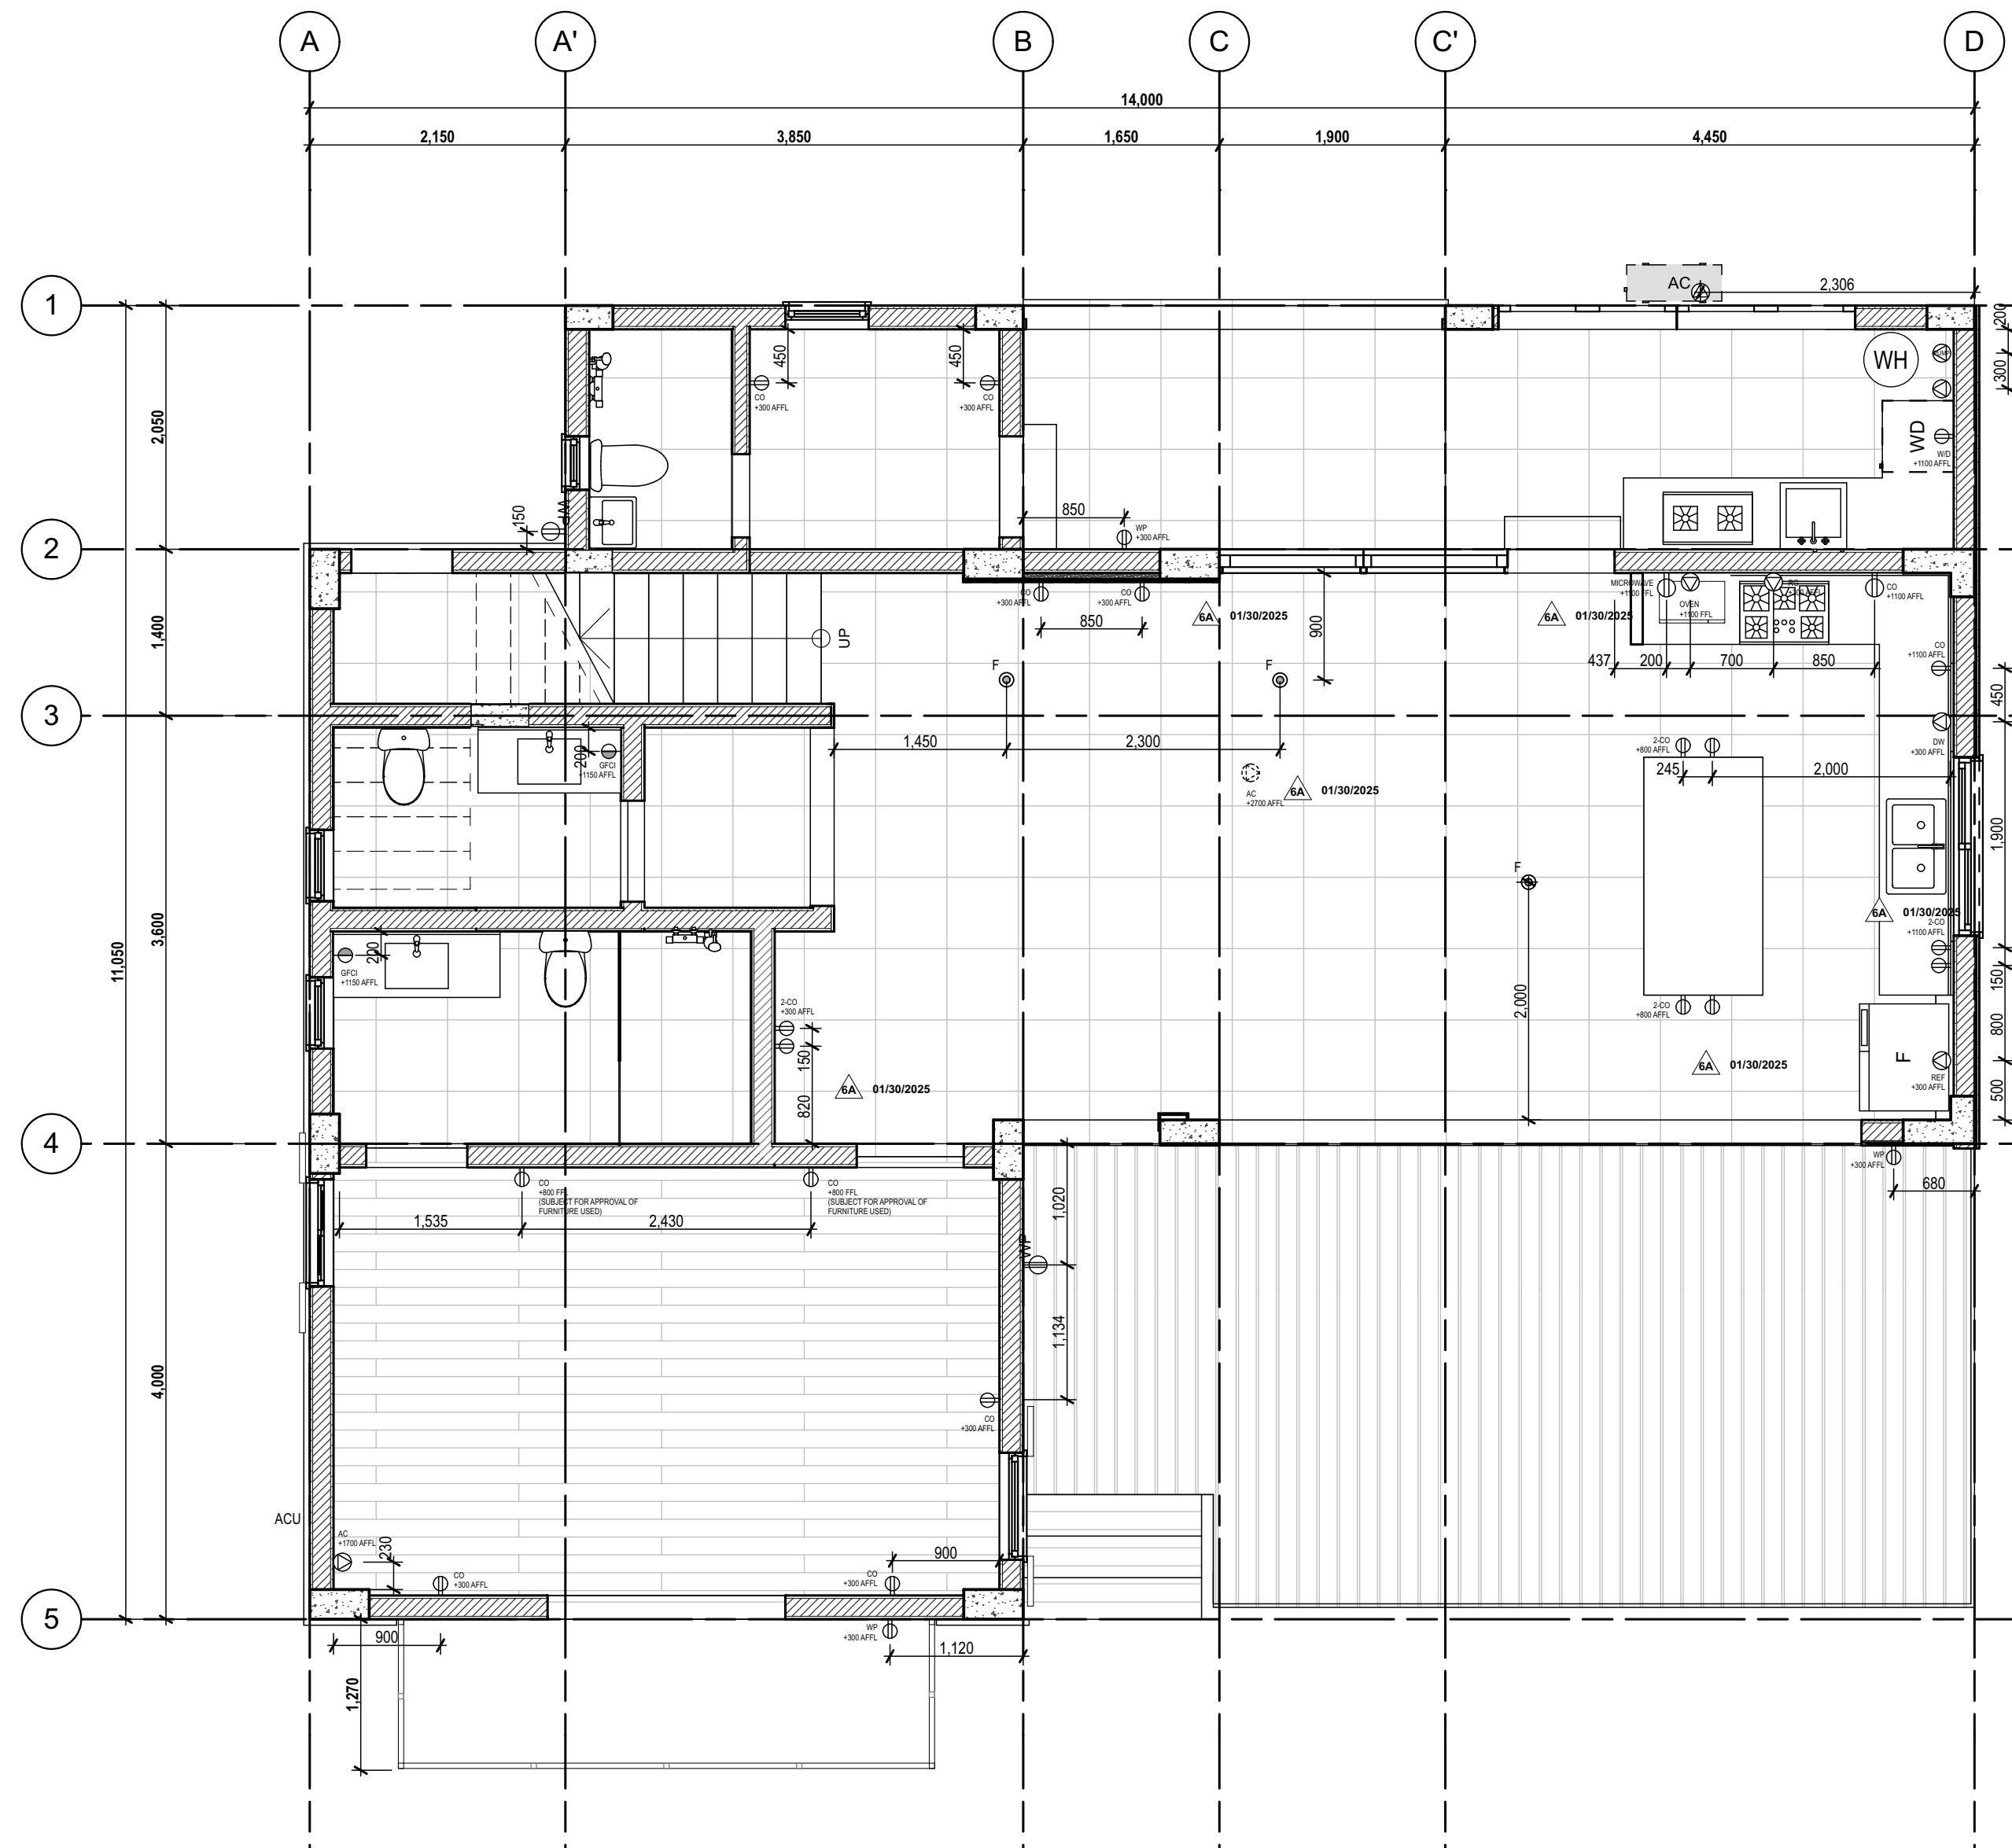

1 1/F POWER LAYOUT
SCALE:1/50
E-100

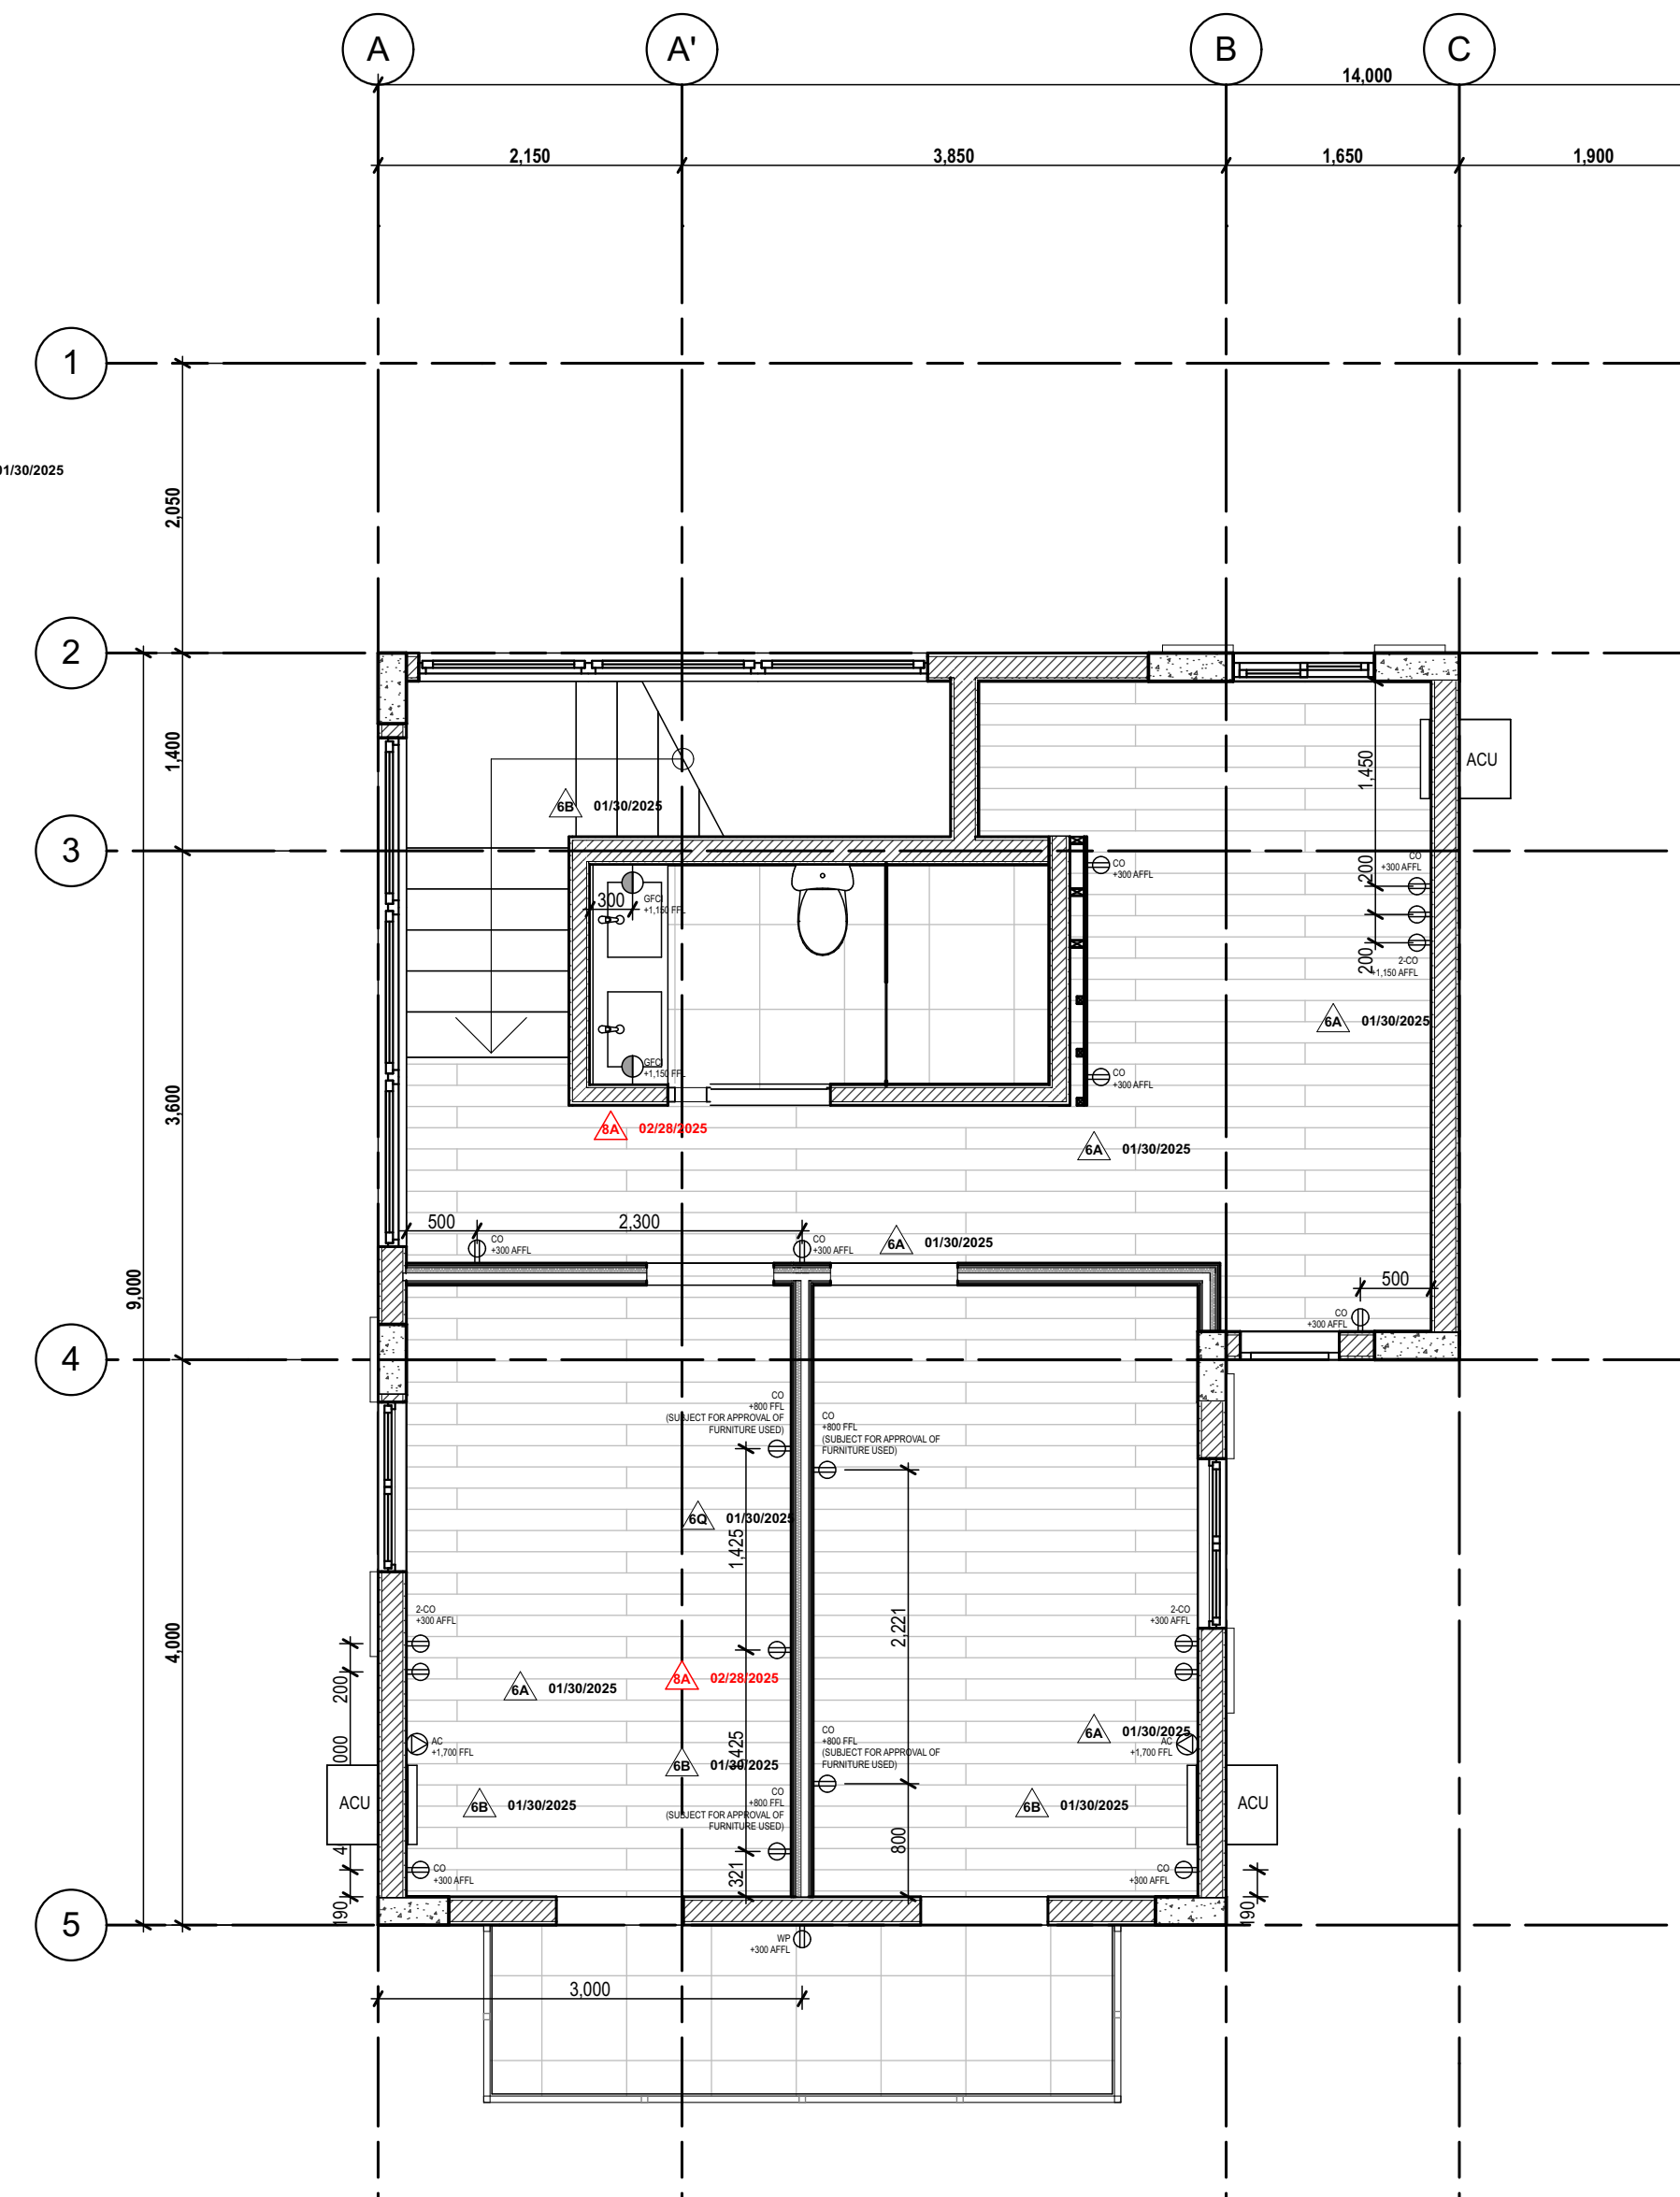

2 2/F POWER LAYOUT
SCALE:1/50
E-100

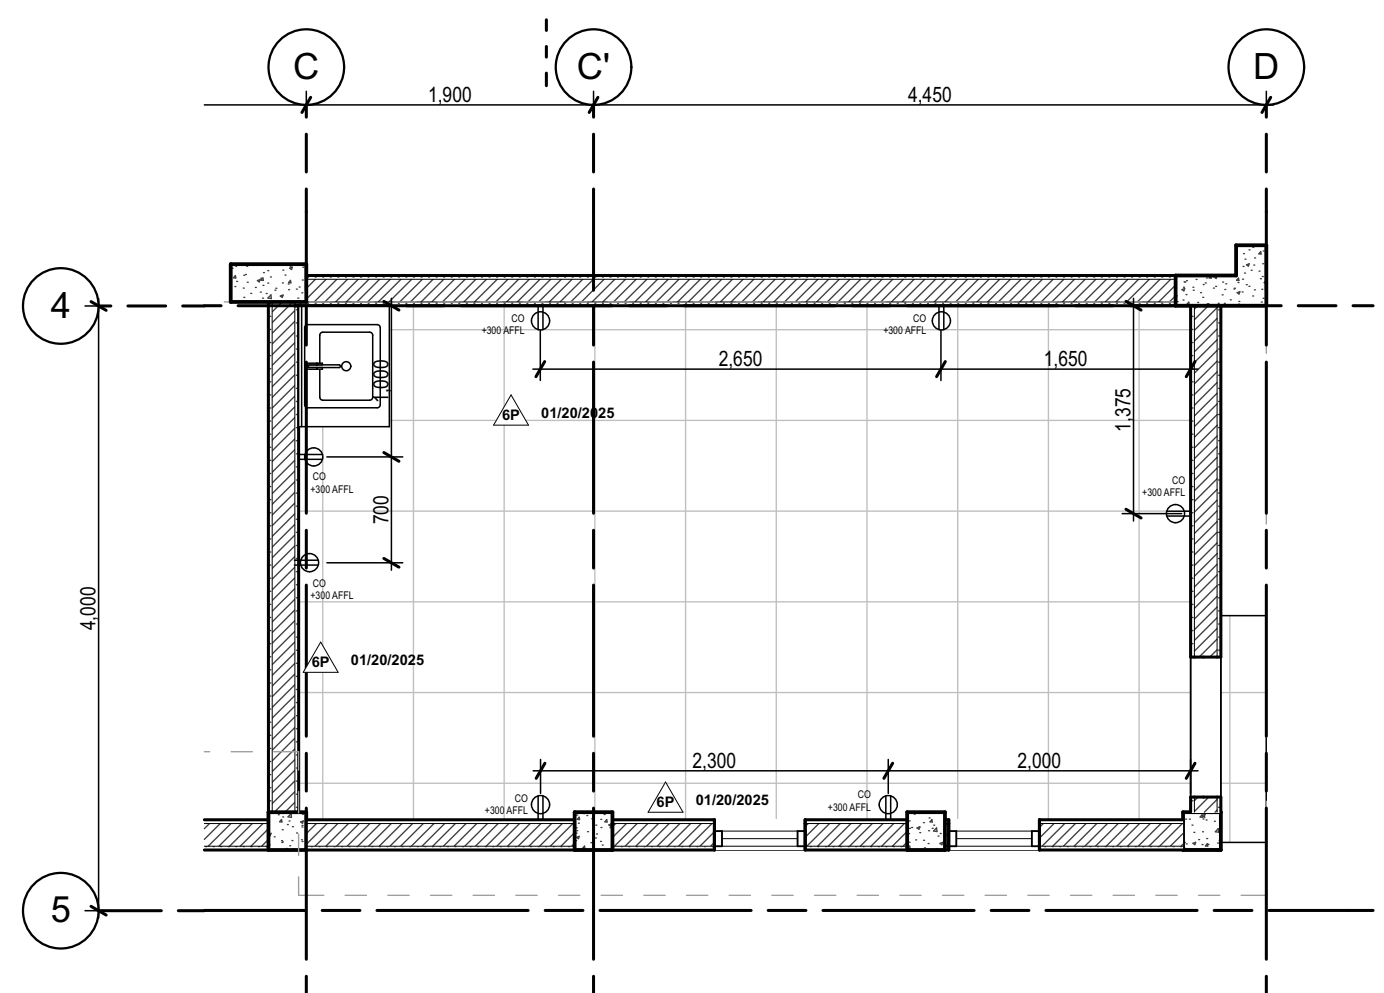

3 LOWER LEVEL STORAGE
SCALE:1/50
E-100

LEGEND: POWER FIXTURES	
	Wall-Mounted Duplex Receptacle
	Single Receptacle Ground Fault Circuit Interrupter (GFCI)
	Air-Condition Unit Special Outlet
	Special Outlet for Washing Machine /Dryer /Dish Washer / Refrigerator/ Water Heater
	Duplex Receptacle Weather-Proof Outlet
	Pop-Up Duplex Receptacle GFCI Outlet (Floor Mounted)
	Telephone Provision: Wall-Mounted
	Switch
	Cabinet Micrometer Switch

ISSUES & REVISIONS		DATE
	FOR PERMIT	AUGUST 9, 2023
	FOR CONSTRUCTION	MARCH 21, 2024
	FOR CONSTRUCTION	MARCH 25, 2024
	CONSTRUCTION BULLETIN #1	MAY 07, 2024
	CONSTRUCTION BULLETIN #2	NOVEMBER 14, 2024
	FOR OWNER APPROVAL	JANUARY 30, 2025
	CONSTRUCTION BULLETIN #3	FEBRUARY 20, 2025
	OWNER APPROVED PLANS	FEBRUARY 28, 2025

REVISION NOTES	
MAY 07, 2024	FLIPPED PLANS AND ADDITION OF BASEMENT
NOVEMBER 14, 2024	5A - REFLECTED THE FLOOR FINISH DROP/ELEVATION ON FLOOR FINISH PLAN
	5B - PROVIDED ADDITIONAL STEP-UP FOR BASEMENT ENTRY
	5C - VERIFIED ELEVATIONS
JANUARY 30, 2025	6A - ADDED OUTLETS
	6B - RELOCATED OUTLETS
FEBRUARY 28, 2025	8A - ADDED OUTLETS

UNIT 2C, 299 P. GUEVARRA BLDG.
299 P. GUEVARRA ST.
855 LITTLE BAGUIO
SAN JUAN CITY 1500
PHILIPPINES

foro

FORO CONSULTING, INC.
architects designers

ARCHITECT:

ARCH. MICHAEL FRANCIS C. OLIVARES
REG. NO. 0010272 DATE 01/03/2024
PTR NO. 1673420 LOCATION SAN JUAN CITY
NAPDA 15073 391565 063023 DATE 06/30/2024

OWNER REPRESENTATIVES :

MR. JOSE C. LOPA

MRS. ANNA L. LOPEZ

MR. MICHAEL C. LOPA

Lopa Farm Marilau Highway Sitio Mayagay,
Brgy. Sampaloc, Tanay Rizal

PROJECT TITLE :

LOPA COMPOUND
DEVELOPMENT

Lopa Farm Marilau Highway Sitio Mayagay,
Brgy. Sampaloc, Tanay Rizal

SHEET CONTENTS :

HOUSE 4

POWER LAYOUT

SCALE: AS SHOWN
DRAWN BY: ADI, JJC, AAC, MMT, BCA
CHECKED BY: MCO
DATE: 02/20/2025
REVISED:

SHEET NO :

E-100

ALL DESIGNS, PRINTS AND SPECIFICATIONS ARE THE PROPERTY OF FORO CONSULTING, INC. AND CANNOT BE USED WITHOUT THEIR WRITTEN PERMISSION. THE SAME SHALL BE RETURNED AT COMPLETION OF THE WORK. DO NOT SCALE DRAWINGS, ALL MEASUREMENTS MUST BE CHECKED AT THE SITE BY THE CONTRACTOR.